




PLAN	SURVEYED	DATE
	PLOTTED	BY
	CHECKED	
	AT	
	FILE NAME	
	NO.	

PROFILE	SURVEYED	DATE
	PLOTTED	BY
	CHECKED	
	AT	
	FILE NAME	
	NO.	

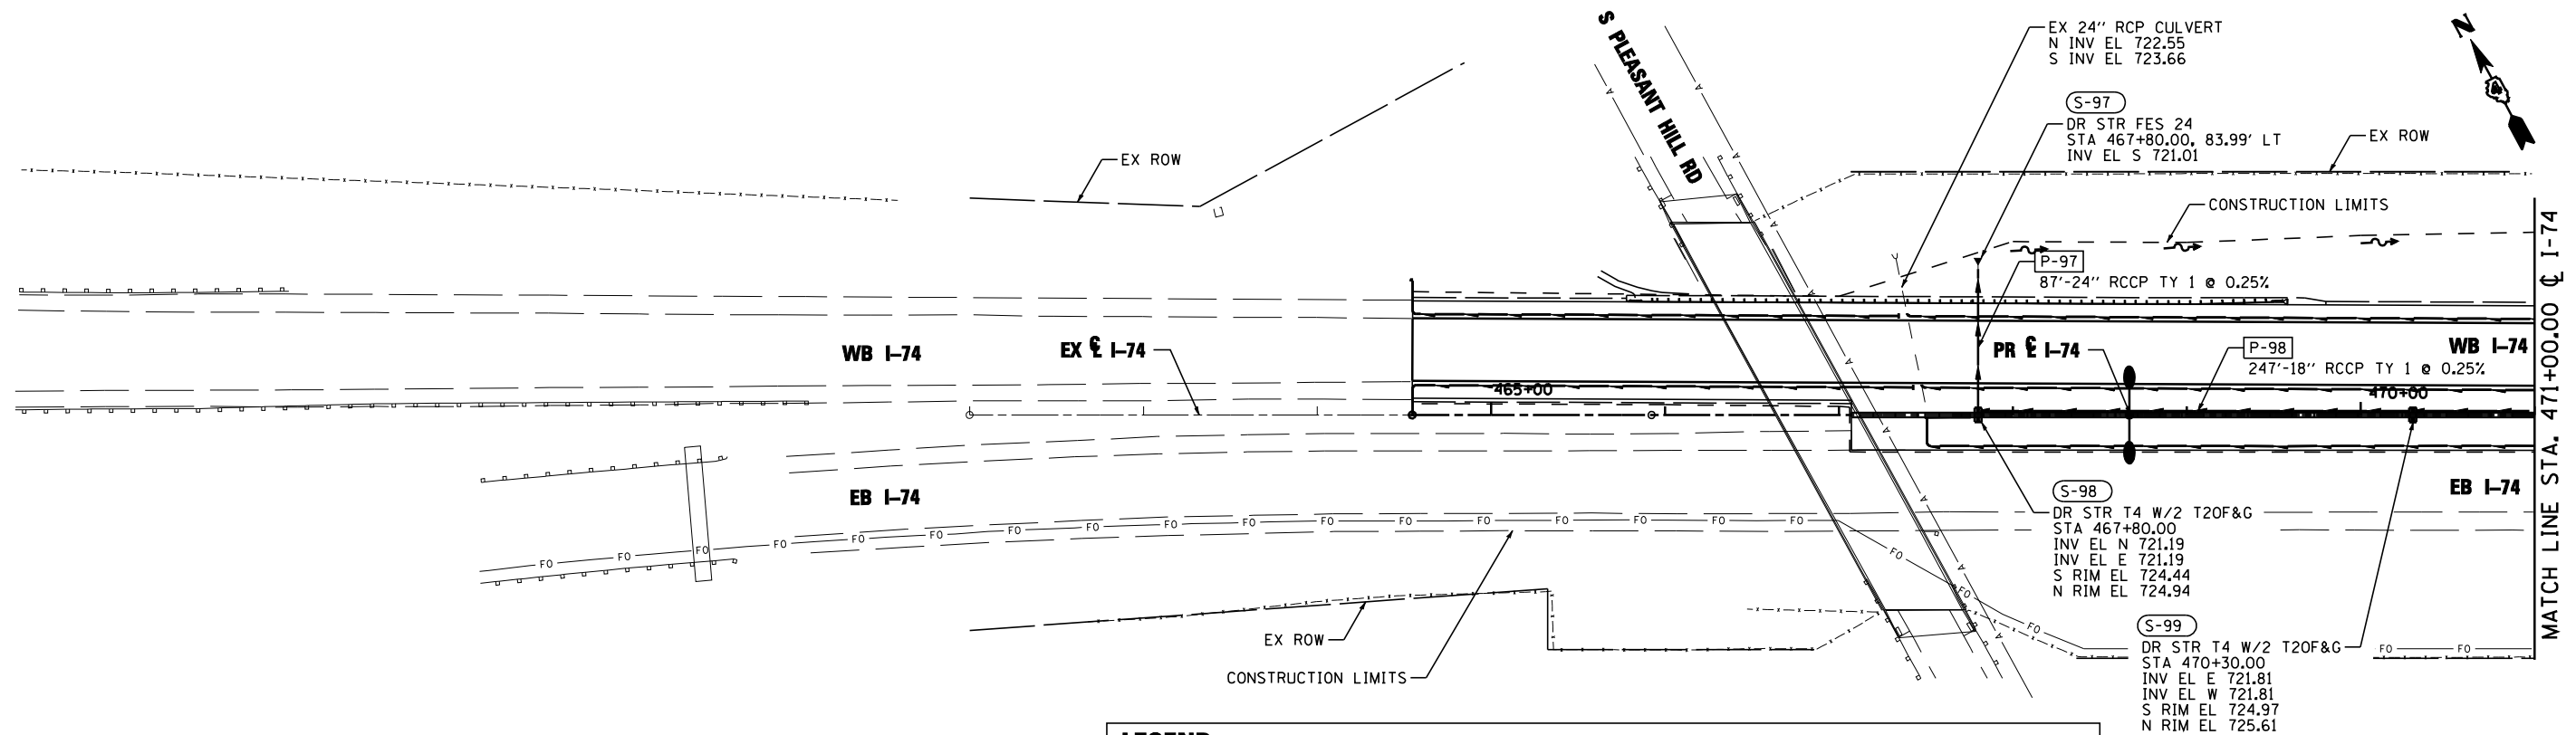

LEGEND:

—A—	EXISTING AERIAL LINE	—S—	PROPOSED STORM SEWER
—CTV—	EXISTING UNDERGROUND CABLE TV	—P—	PROPOSED PIPE UNDERDRAIN
—E—	EXISTING UNDERGROUND ELECTRIC	(S-101B)	PROPOSED STORM SEWER STRUCTURE CALLOUTS
—FO—	EXISTING UNDERGROUND FIBER OPTIC	(P-101)	PROPOSED STORM SEWER PIPE CALLOUTS
—IG—	EXISTING UNDERGROUND GAS LINE	—SAG—	SAG
—T—	EXISTING UNDERGROUND SANITARY SEWER	—SUMMIT—	SUMMIT
—TW—	EXISTING UNDERGROUND TELEPHONE	—DITCH—	DITCH
—W—	EXISTING UNDERGROUND WATER	—SWALE—	SWALE
		—MANHOLE—	MANHOLE

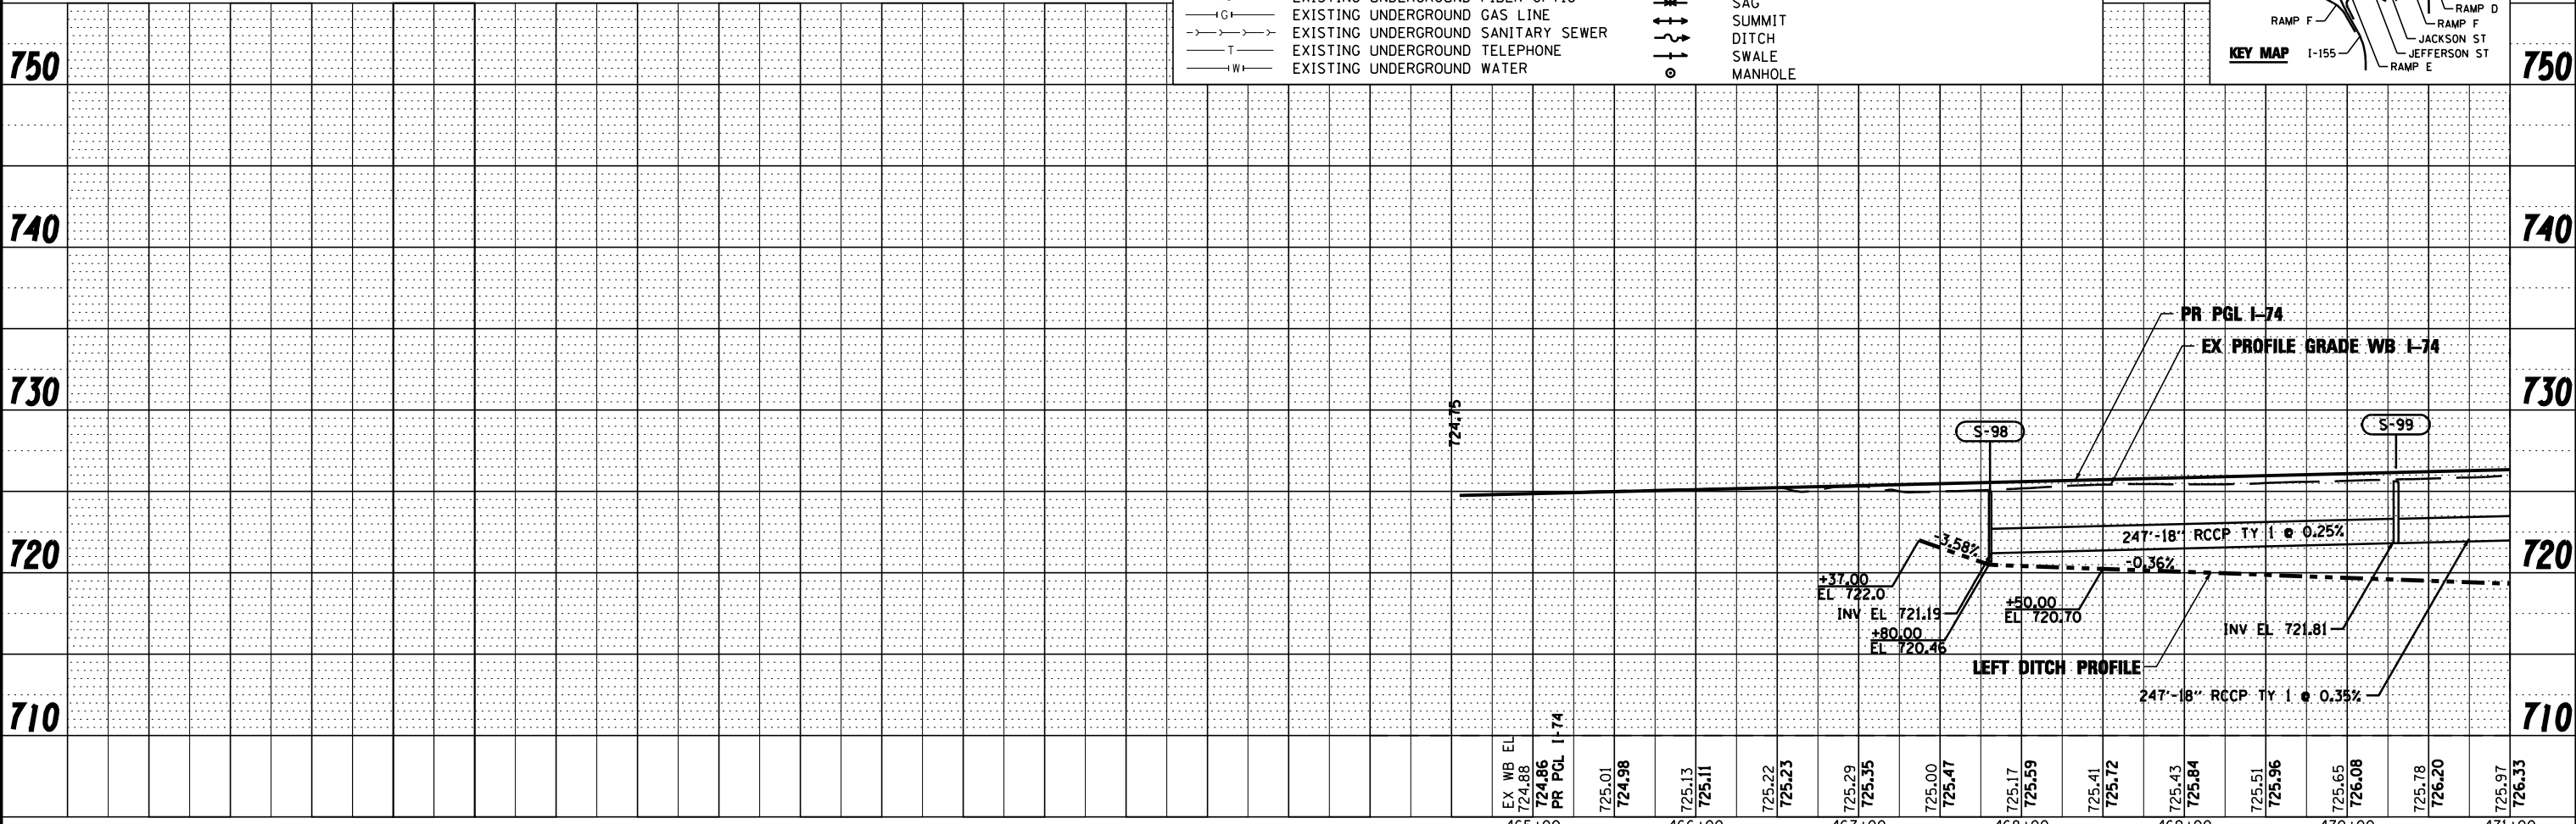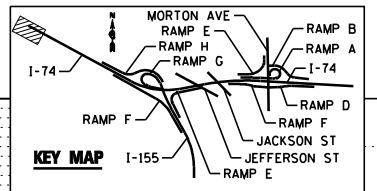

FILE NAME =	DESIGNED - EJA	REVISED -		STATE OF ILLINOIS DEPARTMENT OF TRANSPORTATION		DRAINAGE AND UTILITY PLAN AND PROFILE I-74		F.A.I. SECTION	COUNTY	TOTAL SHEETS	SHEET NO.
...D468620-sht-1-74-drain01.dgn	DRAWN - TMB	REVISED -						90-114R(14HB-4,14,14HVB)BR	TAZEWELL	2433	1414
USER NAME = toddbenk	CHECKED - JNR	REVISED -						CONTRACT NO. 68620			
PLOT DATE = 7/17/2012	DATE - JULY 20, 2012	REVISED -						ILLINOIS FED. AID PROJECT			