




PLAN	SURVEYED	DATE
NOTE BOOK	PLOTTED	BY
NO.	CHECKED	
	DATE	
	FILE NAME	

PROFILE	SURVEYED	DATE
NOTE BOOK	GRADES CHECKED	BY
NO.	STRUCTURE	
	NOTATIONS CHD	

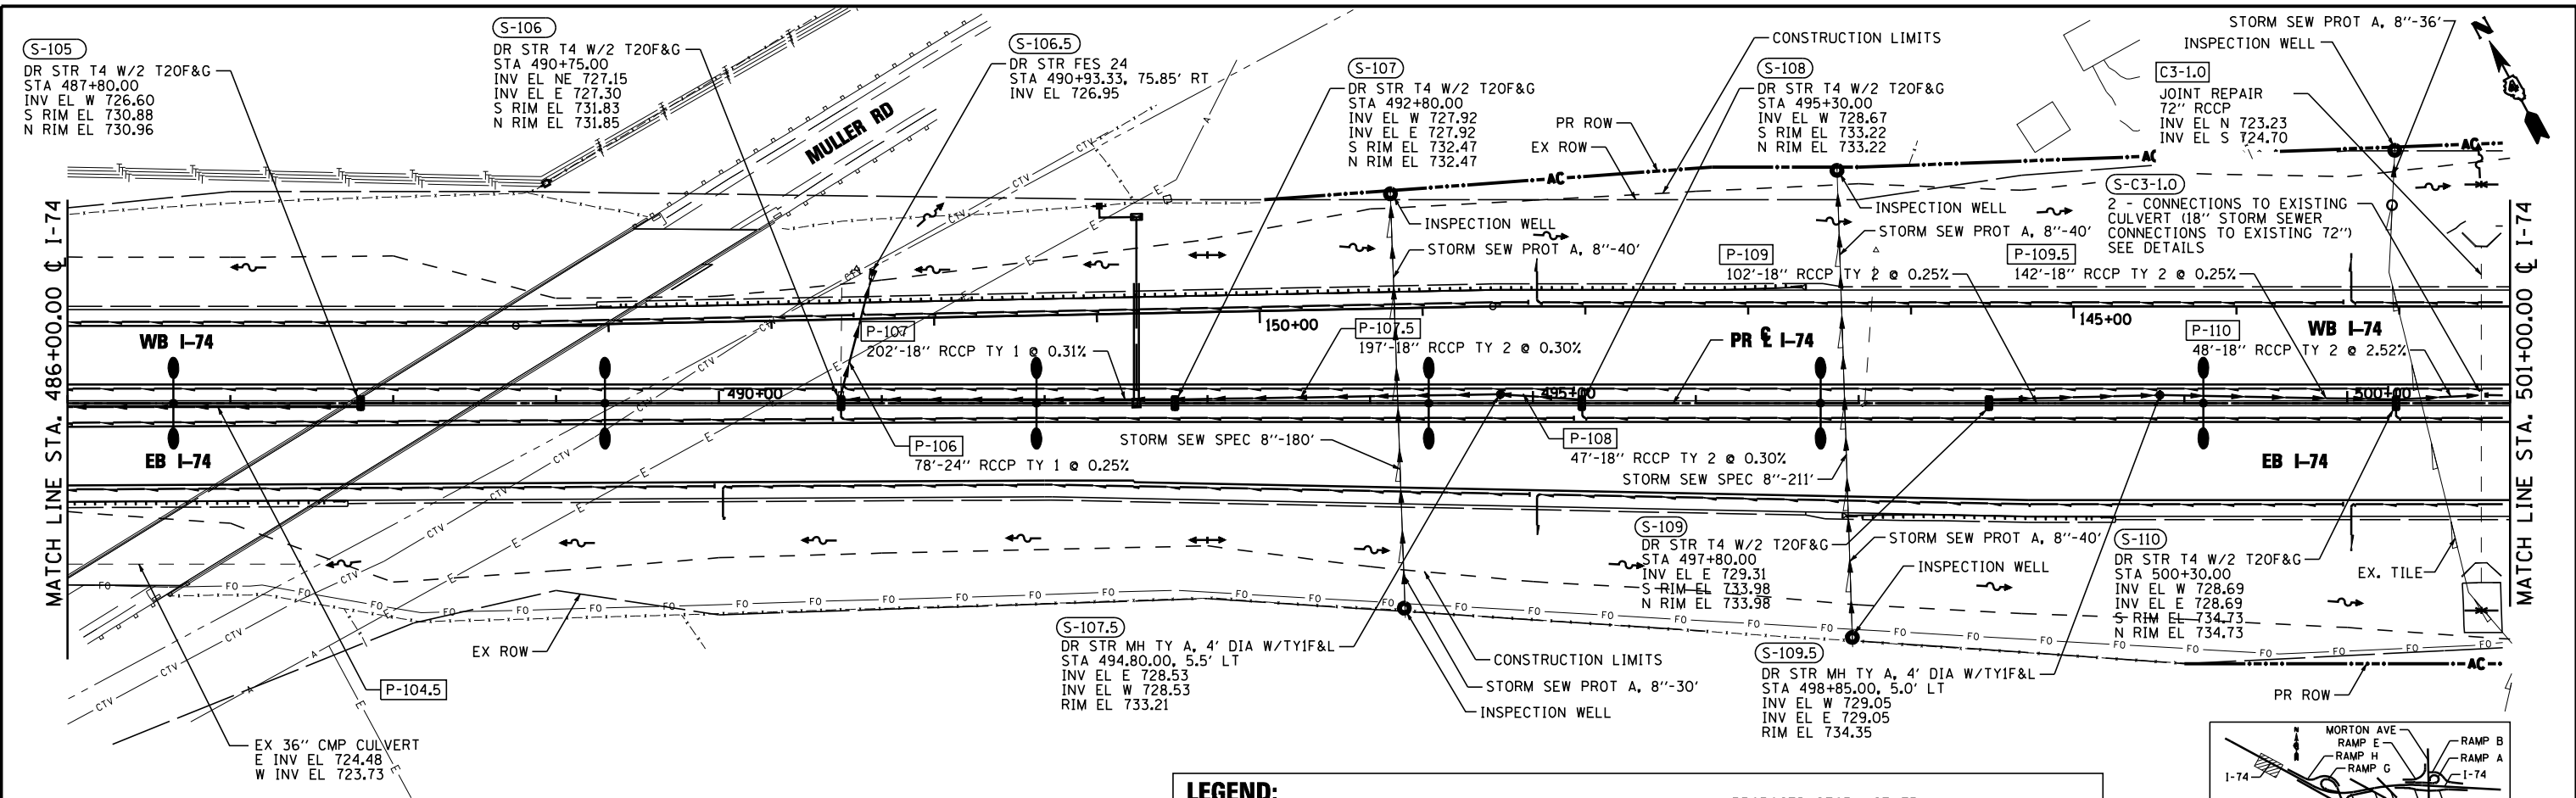

LEGEND:

- A — EXISTING AERIAL LINE
- CTV — EXISTING UNDERGROUND CABLE TV
- E — EXISTING UNDERGROUND ELECTRIC
- FO — EXISTING UNDERGROUND FIBER OPTIC
- IG — EXISTING UNDERGROUND GAS LINE
- S — EXISTING UNDERGROUND SANITARY SEWER
- T — EXISTING UNDERGROUND TELEPHONE
- W — EXISTING UNDERGROUND WATER
- — PROPOSED STORM SEWER
- — PROPOSED PIPE UNDERDRAIN
- — PROPOSED STORM SEWER STRUCTURE CALLOUTS
- — PROPOSED STORM SEWER PIPE CALLOUTS
- — SAG
- — SUMMIT
- — DITCH
- — SWALE
- — MANHOLE

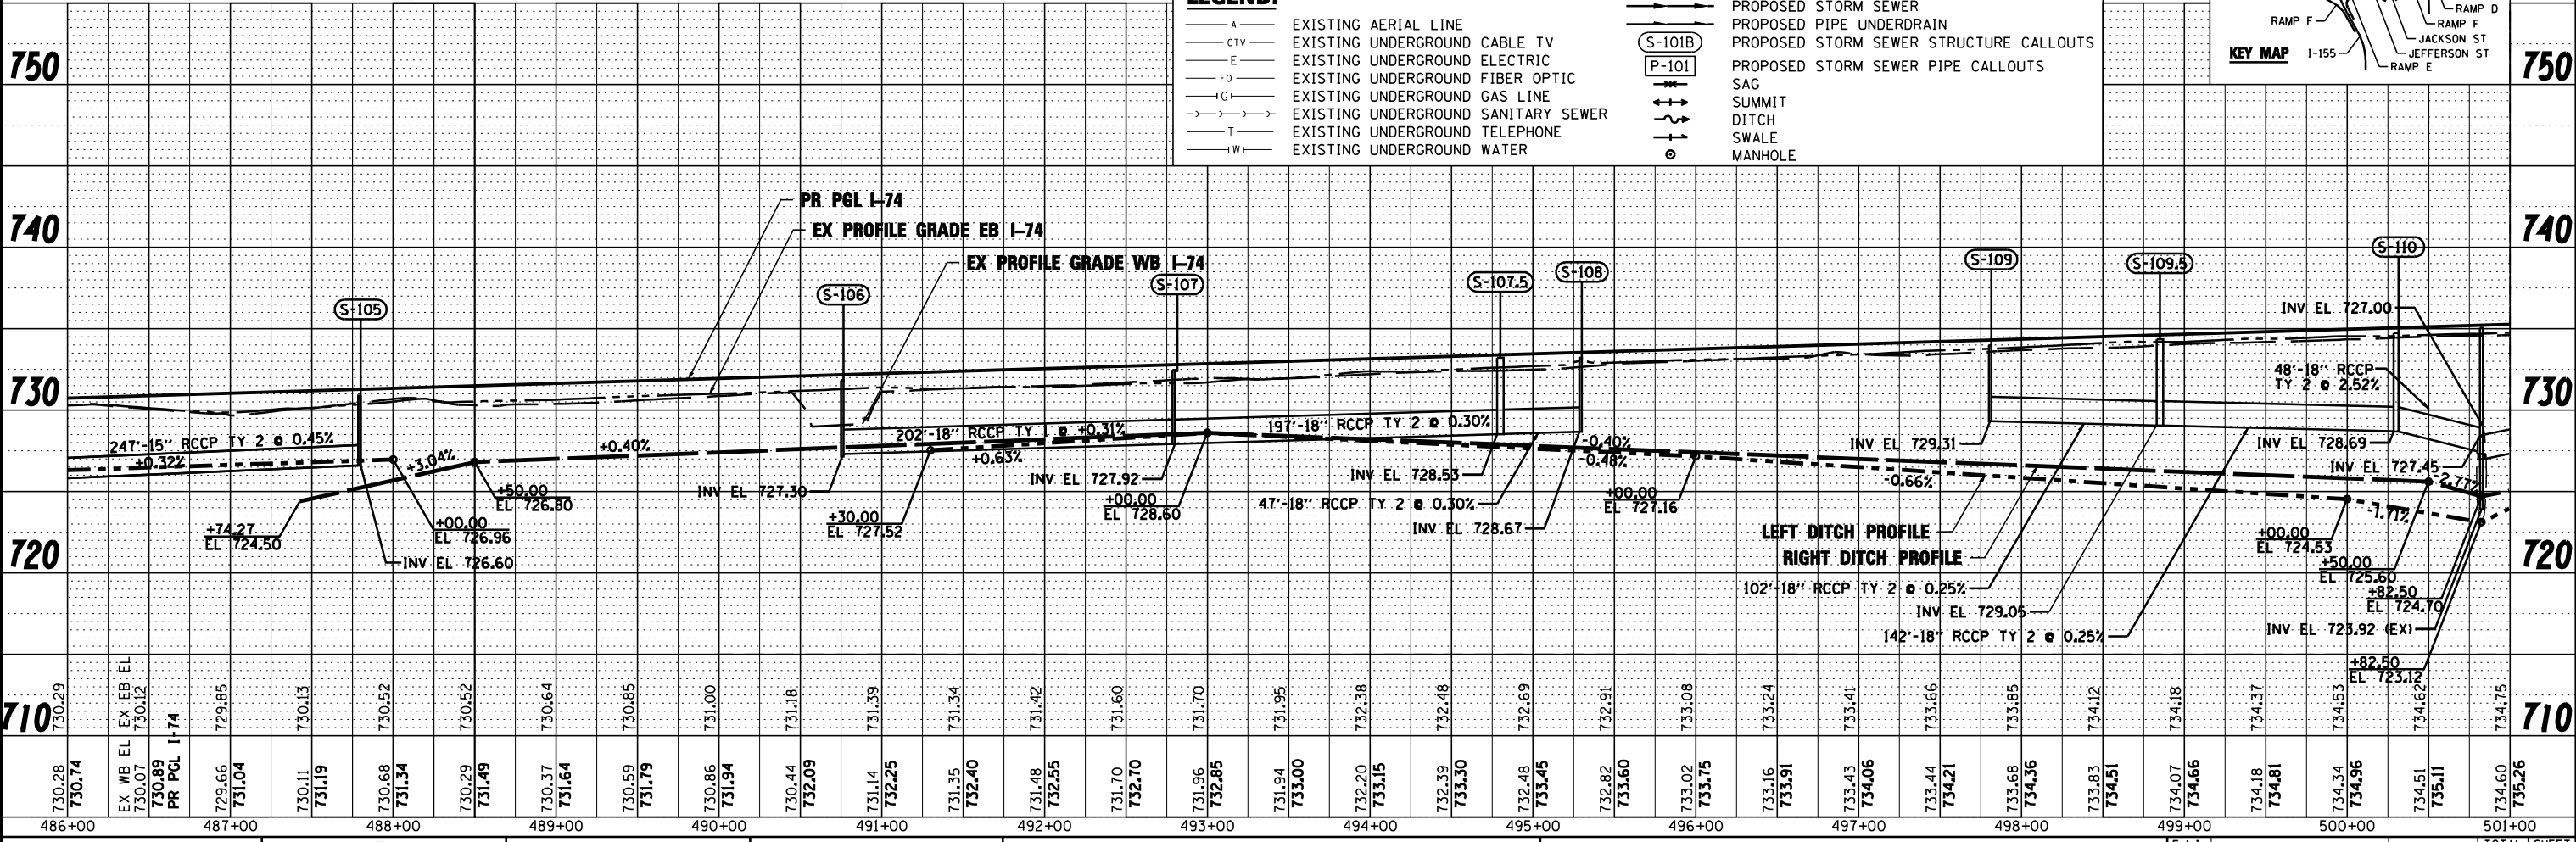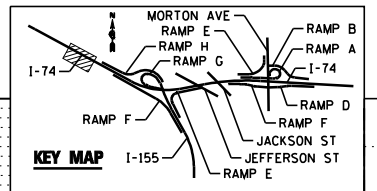

FILE NAME =	DESIGNED - EJA	REVISED -		STATE OF ILLINOIS DEPARTMENT OF TRANSPORTATION		DRAINAGE AND UTILITY PLAN AND PROFILE I-74		F.A.I. R.T.E.	SECTION	COUNTY	TOTAL SHEETS	SHEET NO.
...D468620-sh1-1-74-drain03.dgn	DRAWN - TMB	REVISED -						90-114R(14HB-4,14,14HVB)BR	TAZEWELL	2433	1416	
USER NAME = toddbenk	CHECKED - JNR	REVISED -						CONTRACT NO. 68620				
PLOT DATE = 7/18/2012	DATE - JULY 20, 2012	REVISED -						ILLINOIS FED. AID PROJECT				