


PLAN	SURVEYED	DATE
	PLOTTED	BY
	CHECKED	
	AT	
	FILE NAME	
	NO.	



PROFILE	SURVEYED	DATE
	PLOTTED	BY
	CHECKED	
	AT	
	FILE NAME	
	NO.	

SEE I-74 DRAINAGE PLANS FOR ADDITIONAL INFORMATION

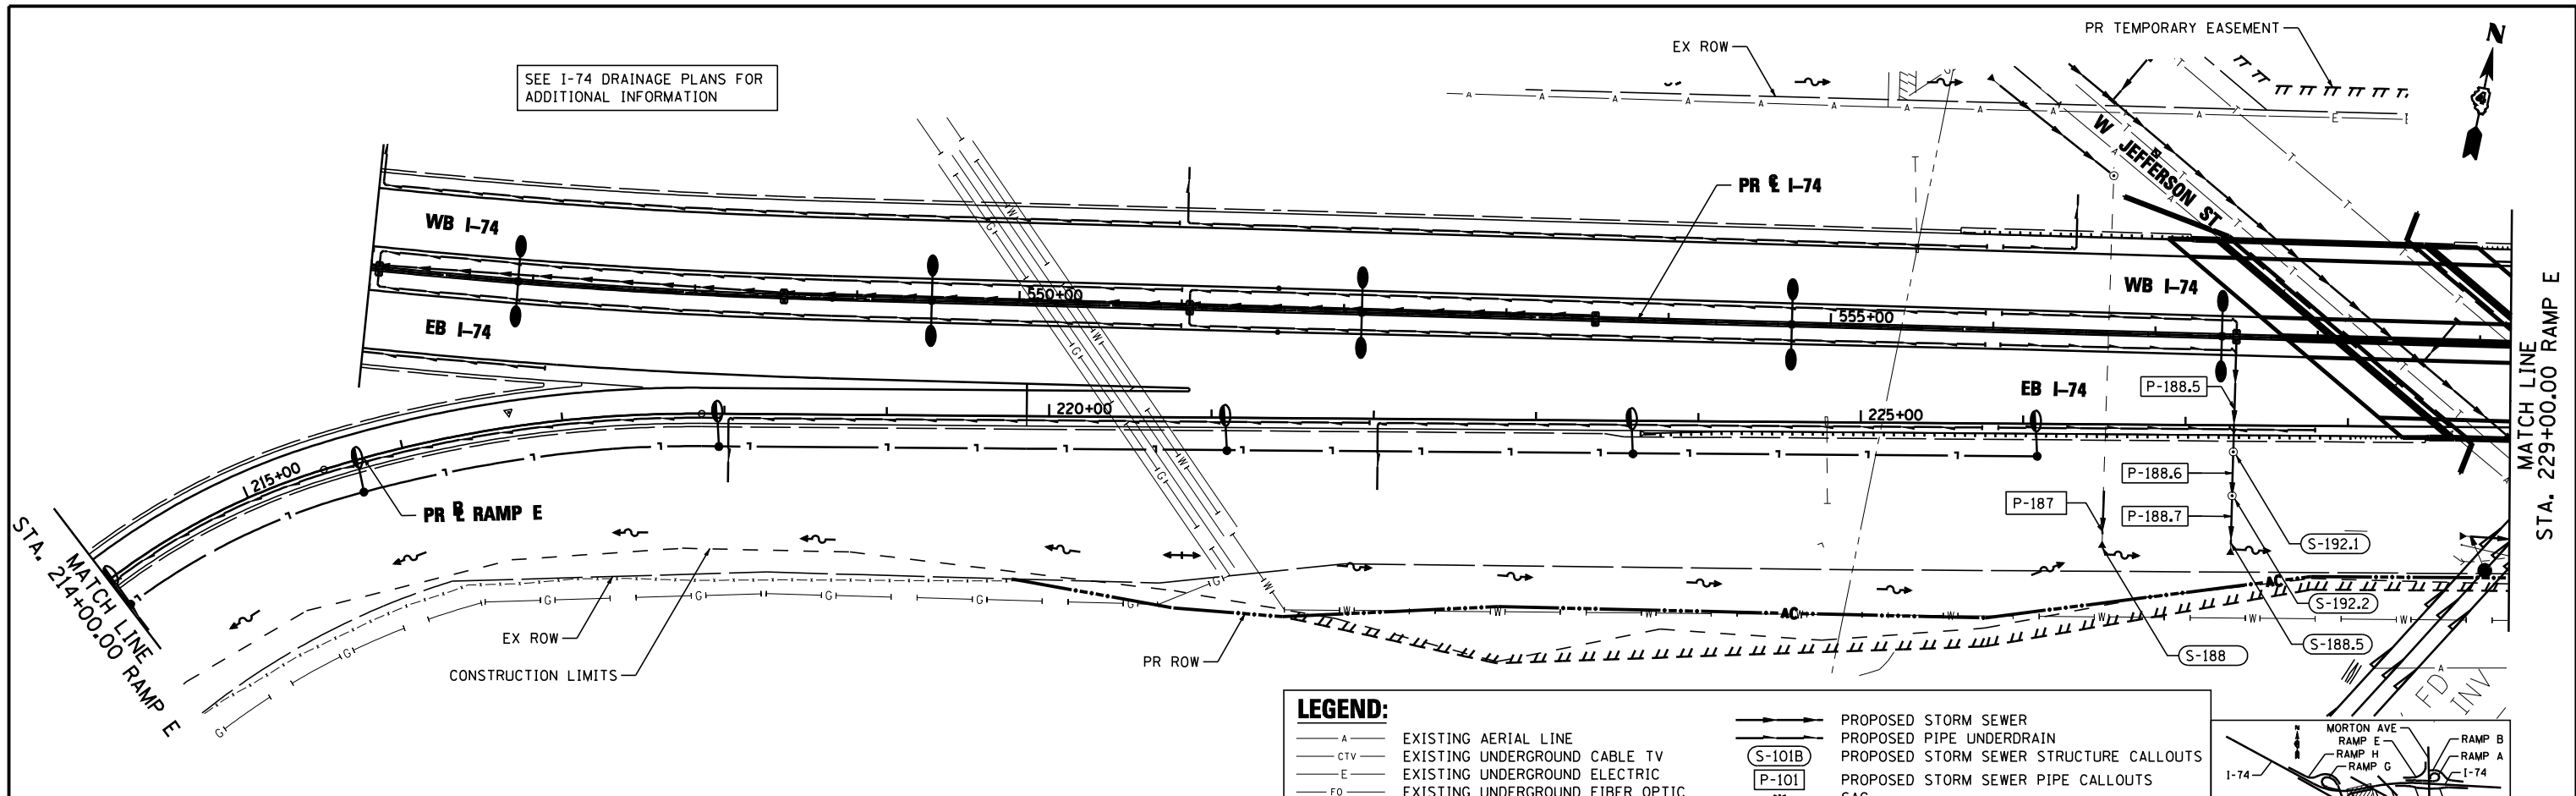

LEGEND:

— A —	EXISTING AERIAL LINE	— S —	PROPOSED STORM SEWER
— CTV —	EXISTING UNDERGROUND CABLE TV	(S-101B)	PROPOSED PIPE UNDERDRAIN
— E —	EXISTING UNDERGROUND ELECTRIC	(P-101)	PROPOSED STORM SEWER STRUCTURE CALLOUTS
— FO —	EXISTING UNDERGROUND FIBER OPTIC	— SAG —	PROPOSED STORM SEWER PIPE CALLOUTS
— IG —	EXISTING UNDERGROUND GAS LINE	— SUMMIT —	SAG
— IS —	EXISTING UNDERGROUND SANITARY SEWER	— DITCH —	SUMMIT
— T —	EXISTING UNDERGROUND TELEPHONE	— SWALE —	DITCH
— W —	EXISTING UNDERGROUND WATER	— MANHOLE —	SWALE
		— MANHOLE —	MANHOLE

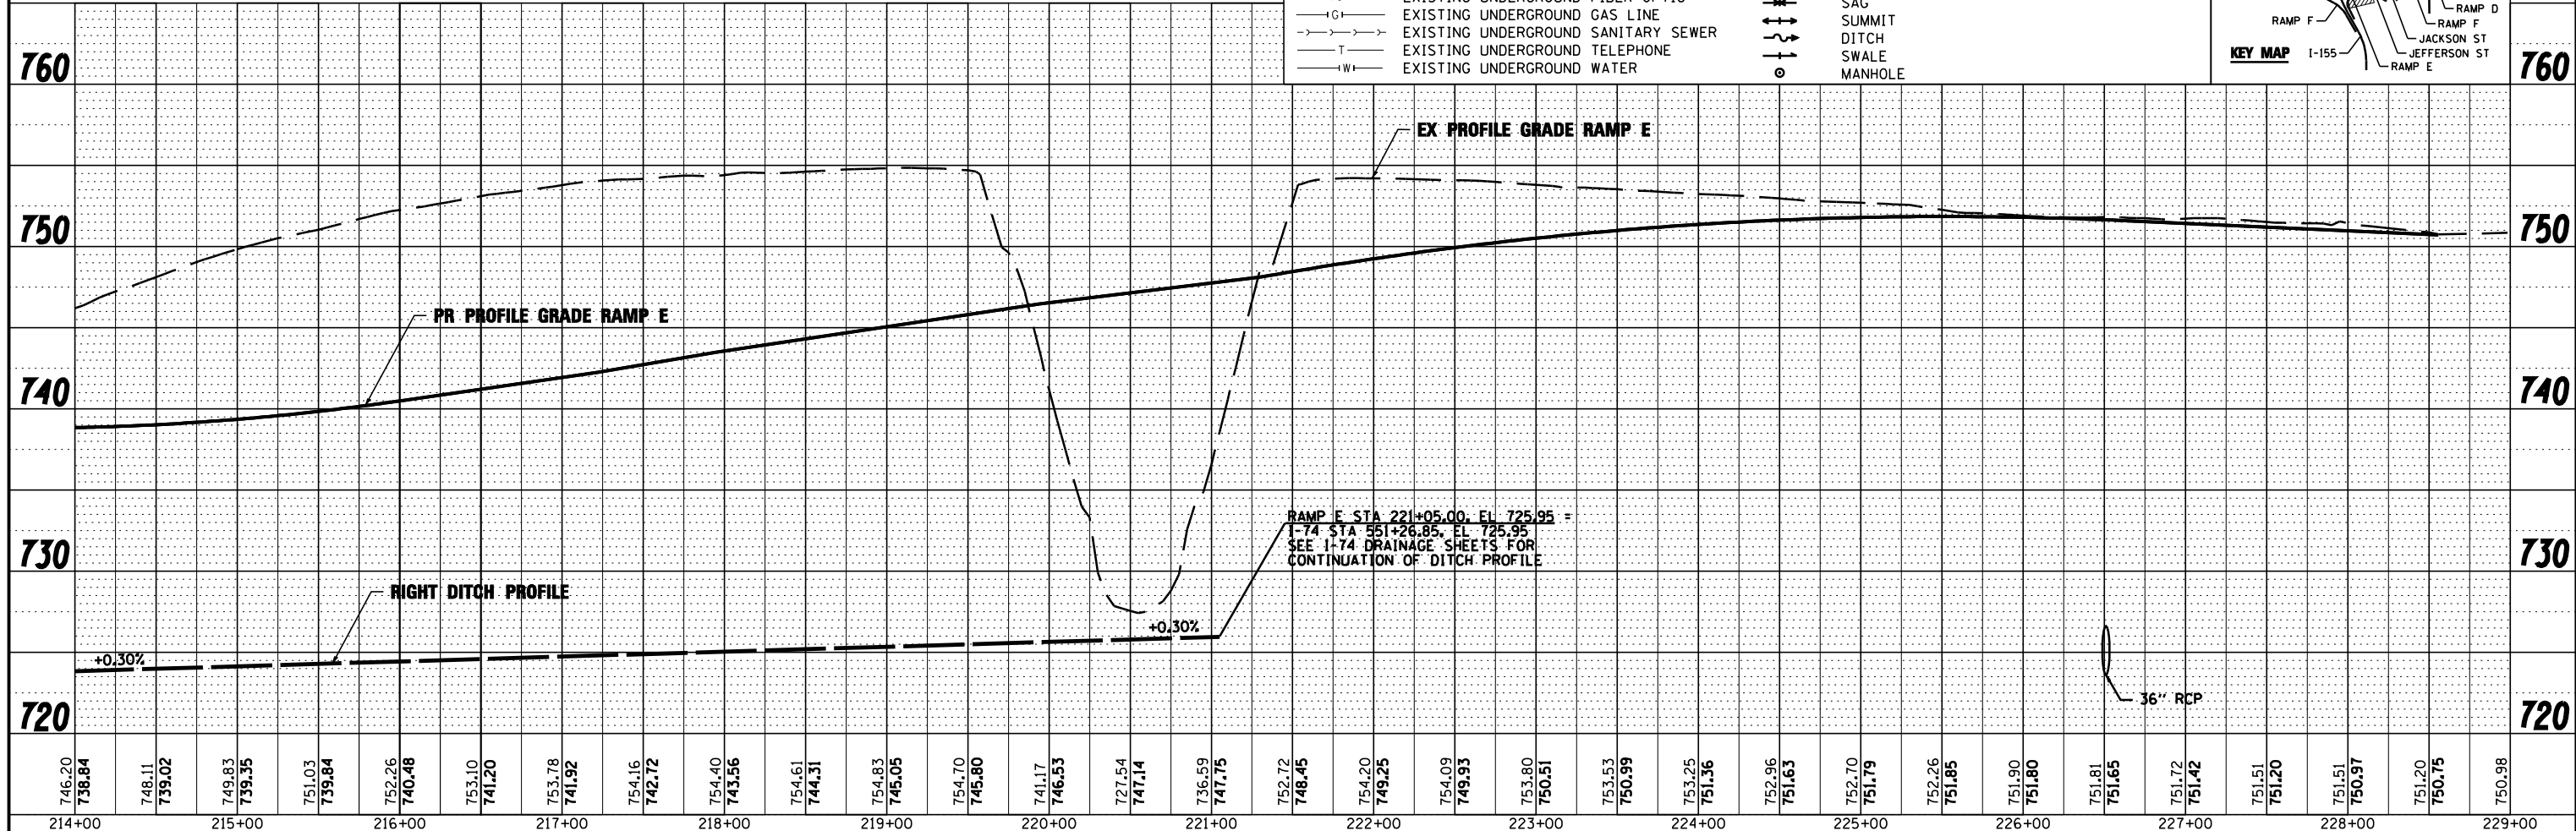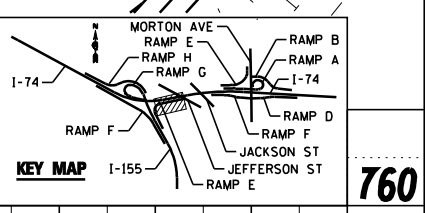

746.20	738.84	748.11	739.02	749.83	739.35	751.03	739.84	752.26	740.48	753.10	741.20	753.78	741.92	754.16	742.72	754.40	743.56	754.61	744.31	754.83	745.05	754.70	745.80	741.17	746.53	727.54	747.14	736.59	747.75	752.72	748.45	754.20	749.25	754.09	749.33	753.80	750.51	753.53	750.99	753.25	751.36	752.96	751.63	752.70	751.79	752.26	751.85	751.90	751.80	751.81	751.65	751.72	751.42	751.51	751.20	751.51	750.97	751.20	750.75	750.98
214+00	215+00	216+00	217+00	218+00	219+00	220+00	221+00	222+00	223+00	224+00	225+00	226+00	227+00	228+00	229+00																																													

FILE NAME =	DESIGNED -	REVISED -
...D468620-sht-1-155-RampE-drain18.dgn	AJP	
USER NAME = toddbenk	DRAWN -	REVISED -
	TMB	
PLOT DATE = 7/17/2012	CHECKED -	REVISED -
	JNR	
	DATE -	REVISED -
	JULY 20, 2012	



STATE OF ILLINOIS
DEPARTMENT OF TRANSPORTATION

DRAINAGE AND UTILITY PLAN AND PROFILE
I-155 RAMP E
SCALE: 1"=50' SHEET NO. 2 OF 8 SHEETS STA. 215+00.00 TO STA. 230+00.00

F.A.I. RTE.	SECTION	COUNTY	TOTAL SHEETS	SHEET NO.
90-114R(14HB-4,14,14HVB)BR	TAZEWELL	2433	1431	
CONTRACT NO. 68620				
ILLINOIS FED. AID PROJECT				