




PLAN	SURVEYED	BY	DATE
	PLOTTED		
	CHECKED		
	AT		
	NO. CAD FILE NAME		

PROFILE	SURVEYED	BY	DATE
	PLOTTED		
	CHECKED		
	AT		
	NO. NOT AT THIS OFFICE		

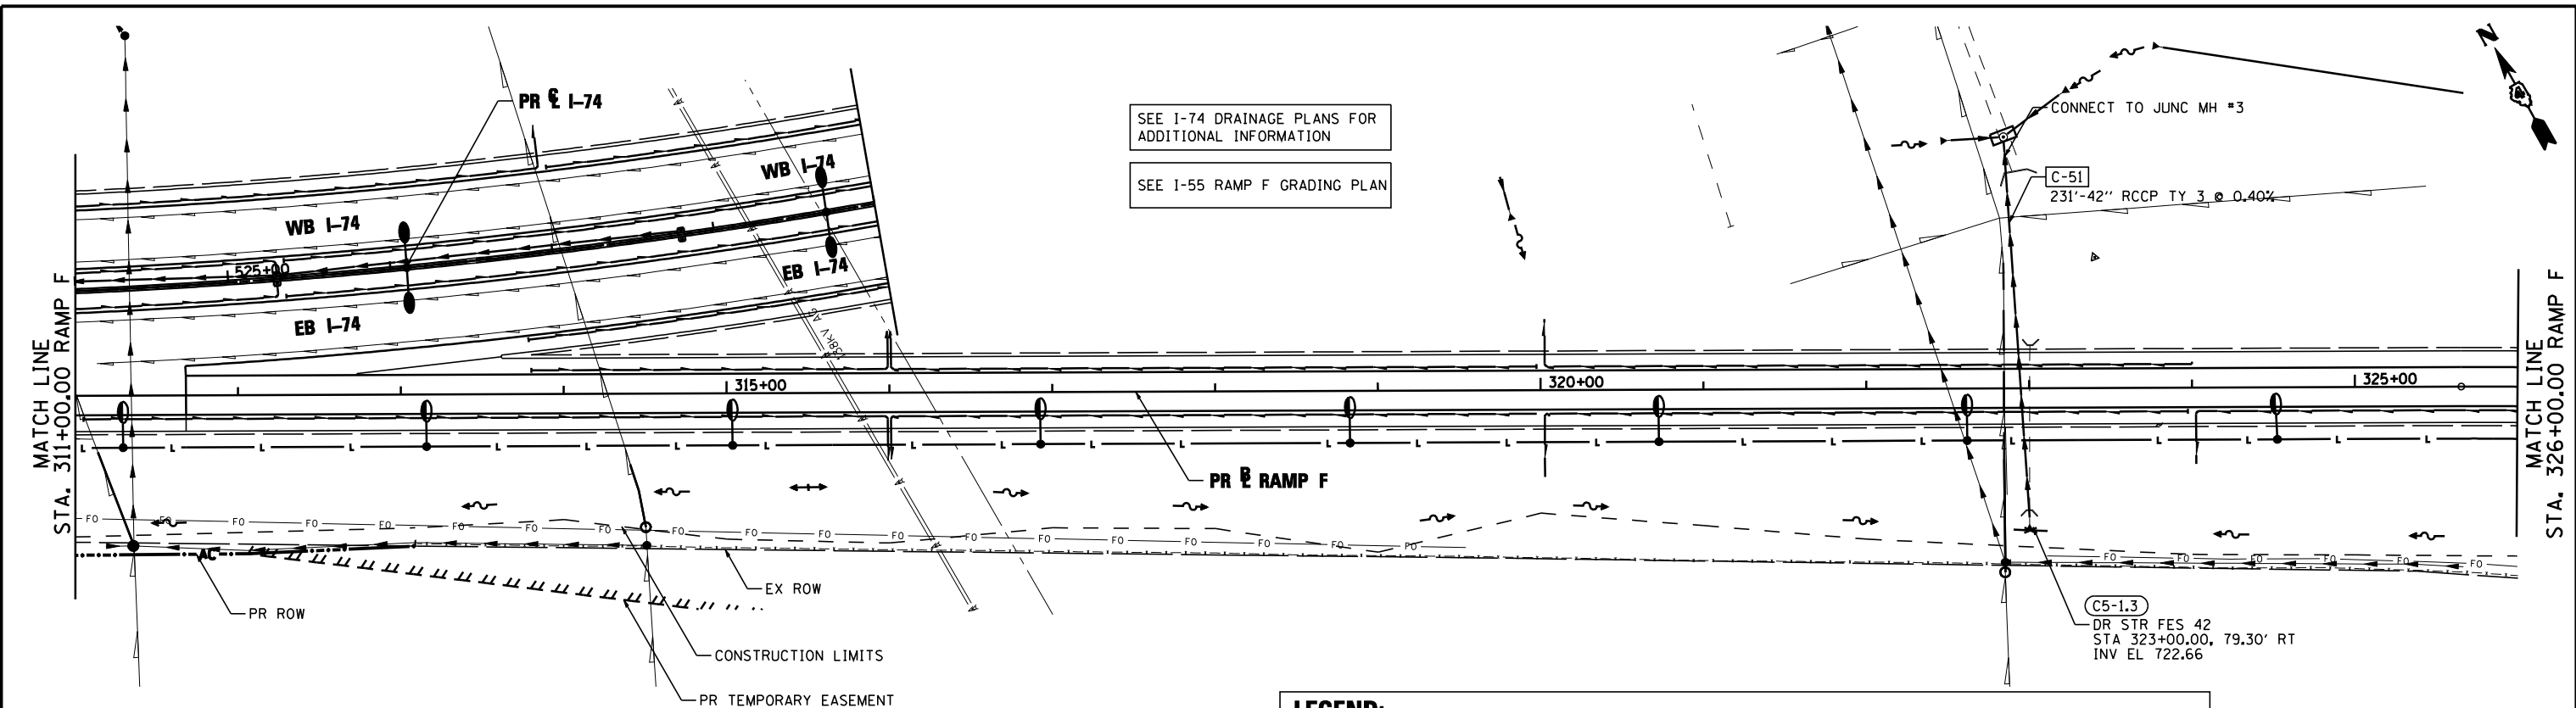

LEGEND:

— A —	EXISTING AERIAL LINE	—	PROPOSED STORM SEWER
— CTV —	EXISTING UNDERGROUND CABLE TV	—	PROPOSED PIPE UNDERDRAIN
— E —	EXISTING UNDERGROUND ELECTRIC	—	PROPOSED STORM SEWER STRUCTURE CALLOUTS
— FO —	EXISTING UNDERGROUND FIBER OPTIC	—	PROPOSED STORM SEWER PIPE CALLOUTS
— IG —	EXISTING UNDERGROUND GAS LINE	—	SAG
— S —	EXISTING UNDERGROUND SANITARY SEWER	—	SUMMIT
— T —	EXISTING UNDERGROUND TELEPHONE	—	DITCH
— W —	EXISTING UNDERGROUND WATER	—	SWALE
		—	MANHOLE

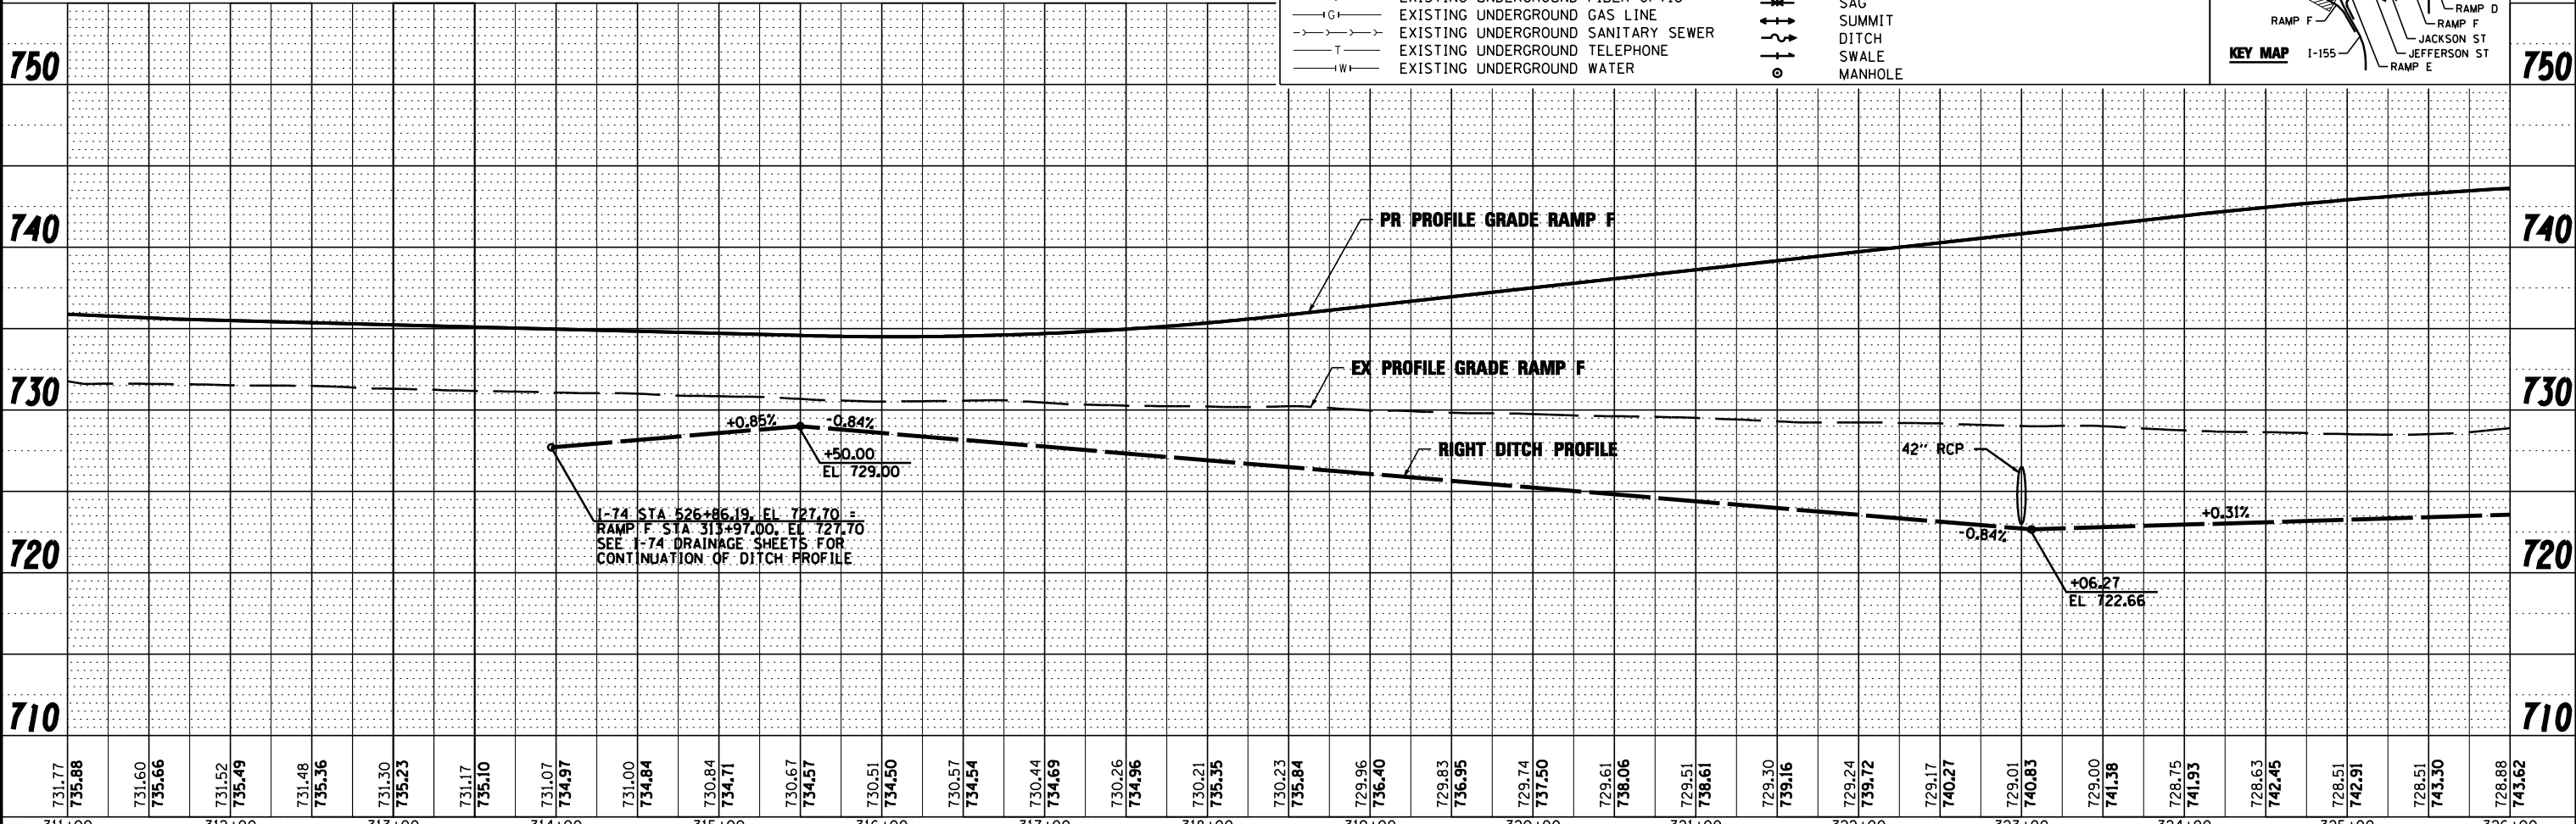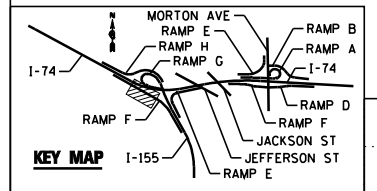

FILE NAME =	DESIGNED -	REVISED -		STATE OF ILLINOIS DEPARTMENT OF TRANSPORTATION		DRAINAGE AND UTILITY PLAN AND PROFILE I-155 RAMP F		F.A.I. SECTION	COUNTY	TOTAL SHEETS	SHEET NO.
...D468620-sht-1-155-RampF-drain21.dgn	DRAWN -	REVISED -						90-114R(14HB-4,14,14HVB)BR	TAZEWELL	2433	1432
USER NAME = toddbenk	CHECKED -	REVISED -						CONTRACT NO. 68620			
PLOT DATE = 7/17/2012	DATE -	REVISED -						ILLINOIS FED. AID PROJECT			