



SEE RAMP D MORTON AVE
FOR ADDITIONAL INFORMATION

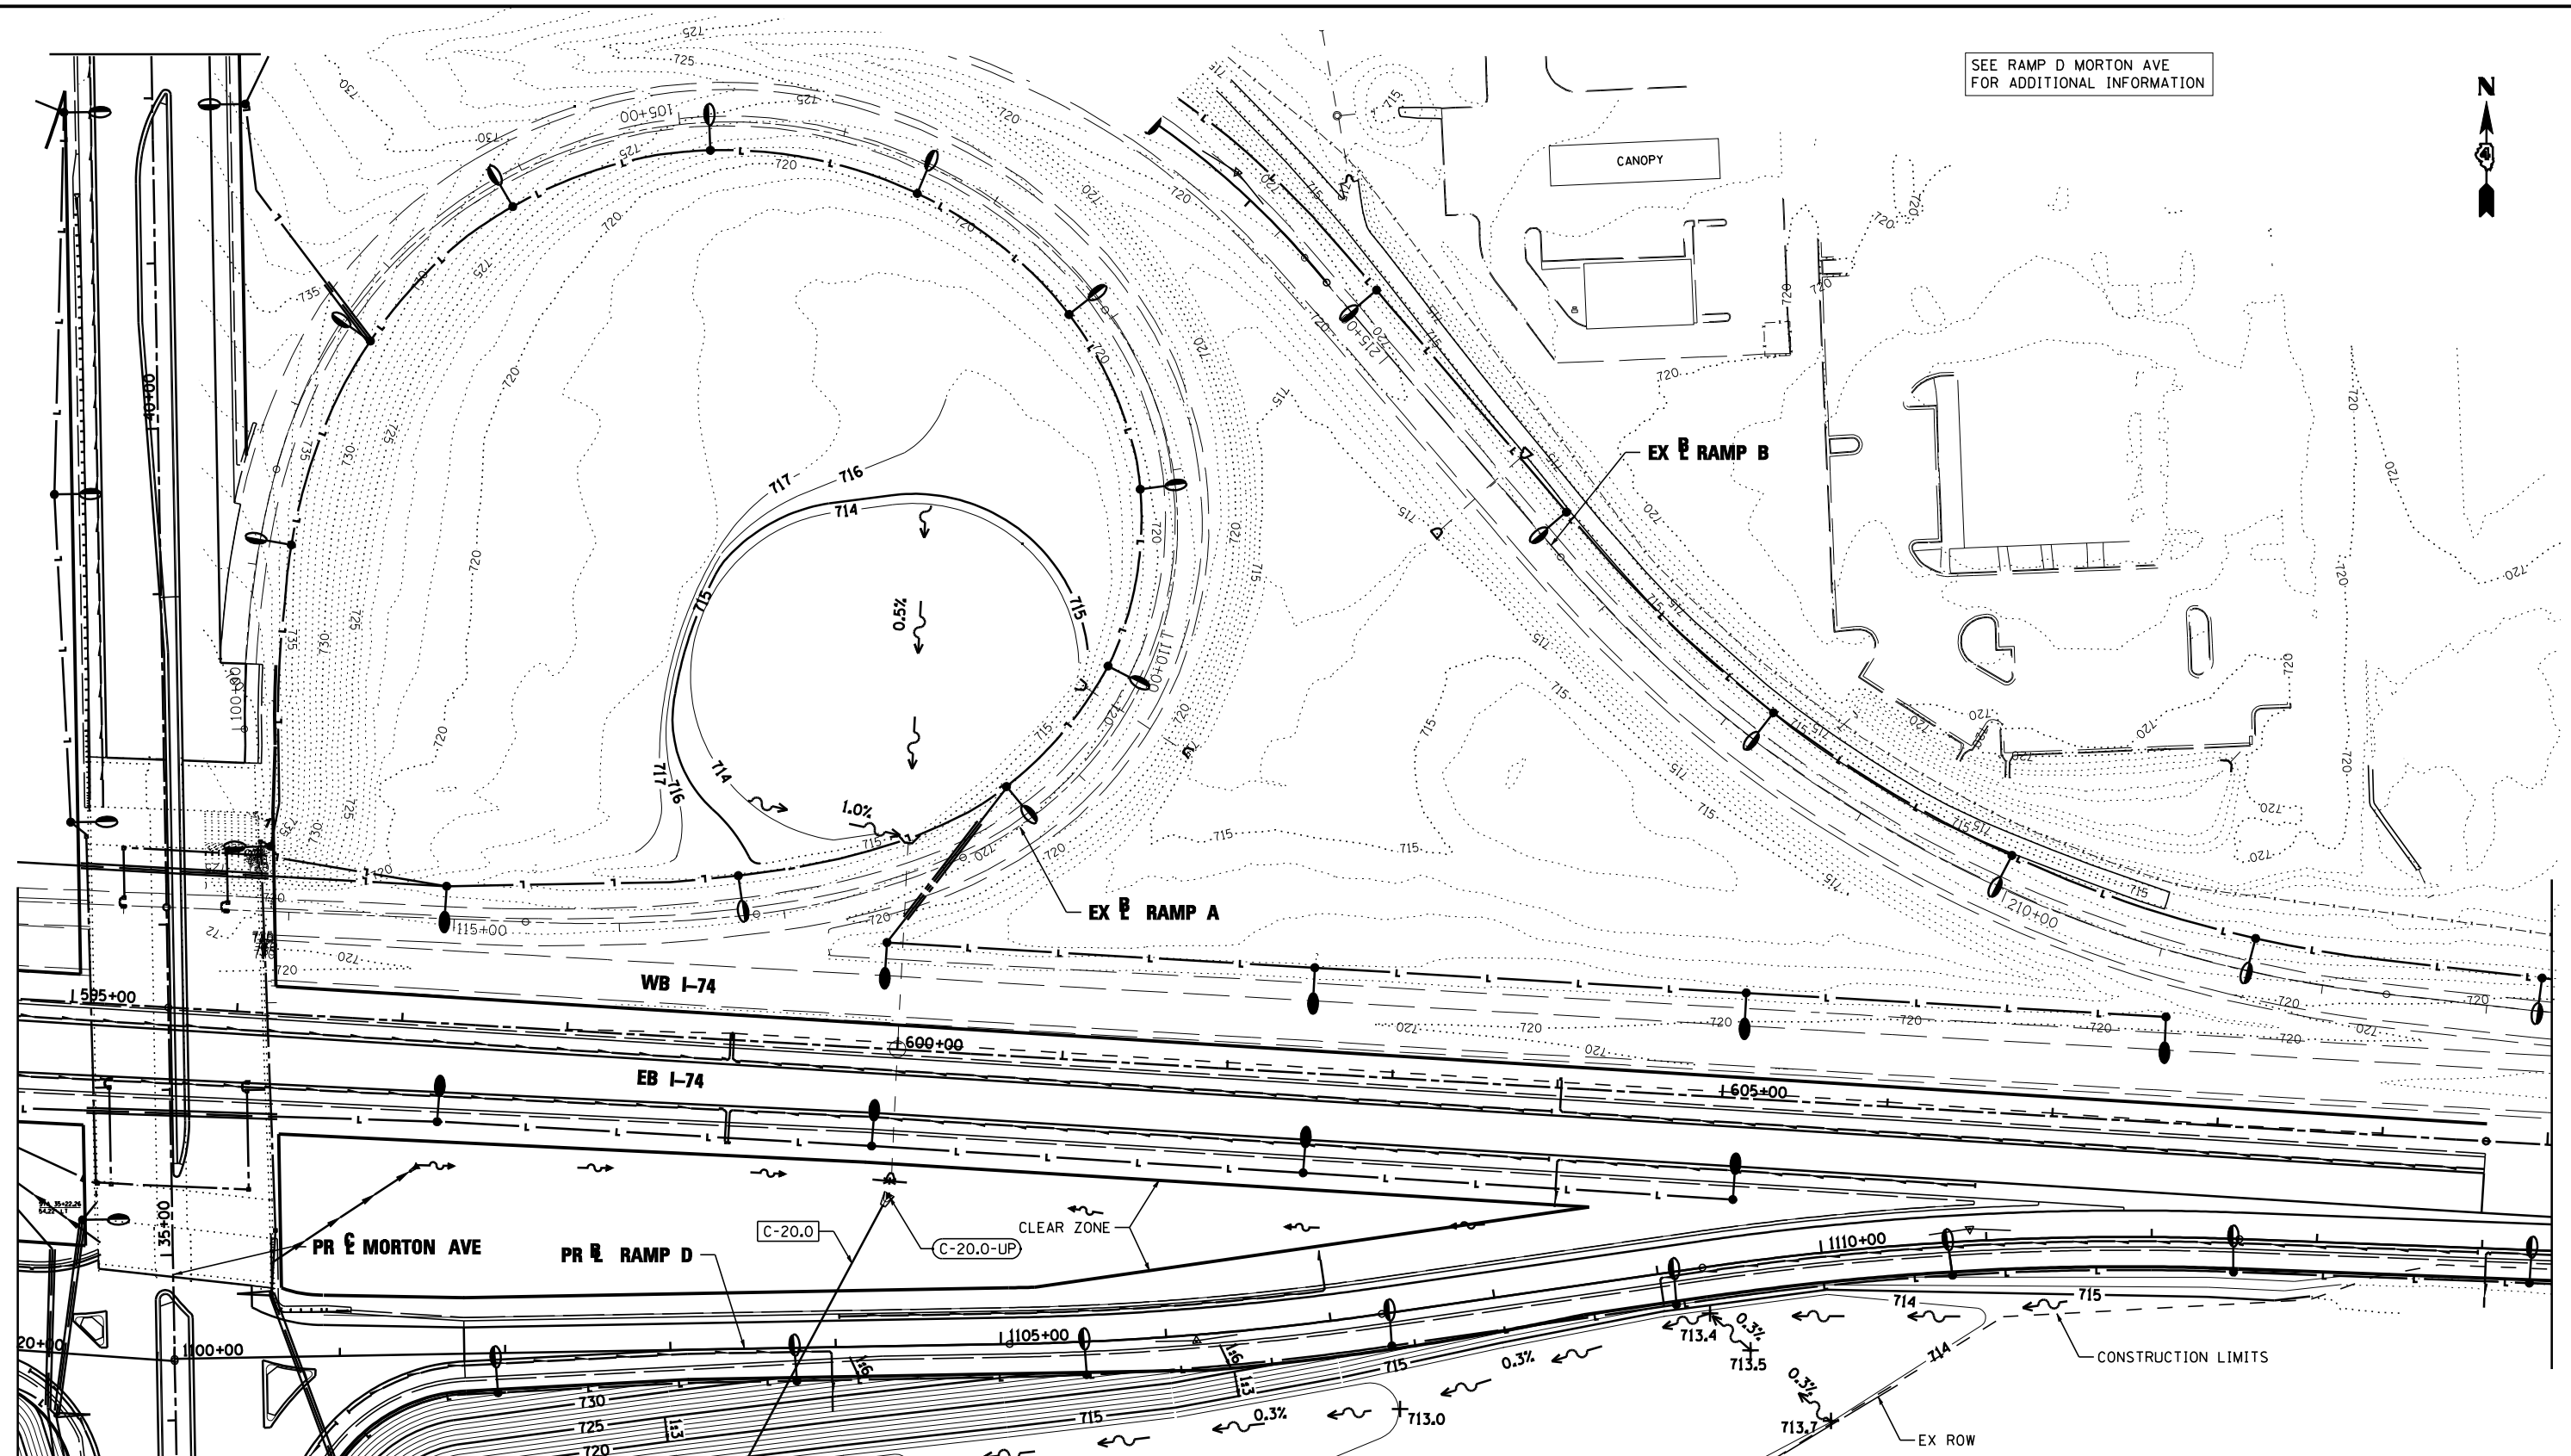

LEGEND:

- A — EXISTING AERIAL LINE
- CTV — EXISTING UNDERGROUND CABLE TV
- E — EXISTING UNDERGROUND ELECTRIC
- FO — EXISTING UNDERGROUND FIBER OPTIC
- IG — EXISTING UNDERGROUND GAS LINE
- S — EXISTING UNDERGROUND SANITARY SEWER
- T — EXISTING UNDERGROUND TELEPHONE
- W — EXISTING UNDERGROUND WATER
- S-101B — PROPOSED STORM SEWER
- P-101 — PROPOSED PIPE UNDERDRAIN
- S-101B — PROPOSED STORM SEWER STRUCTURE CALLOUTS
- P-101 — PROPOSED STORM SEWER PIPE CALLOUTS
- SAG — SAG
- SUMMIT — SUMMIT
- DITCH — DITCH
- SWALE — SWALE
- MANHOLE — MANHOLE

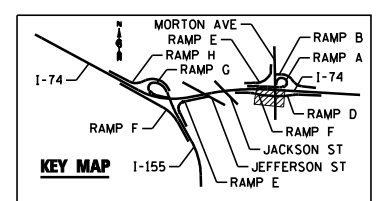

FILE NAME =	DESIGNED - I S	REVISED -
...D468620-sh1-rampA-Morton-Basing.dgn	DRAWN - I S	REVISED -
USER NAME = toddblank	CHECKED - JNR	REVISED -
PLOT DATE = 7/17/2012	DATE - JULY 20, 2012	REVISED -



**STATE OF ILLINOIS
DEPARTMENT OF TRANSPORTATION**

**GRADING PLANS
MORTON AVE RAMP A**

SCALE: 1"=50' SHEET NO. 5 OF 7 SHEETS STA. TO STA.

F.A.I. RTE.	SECTION	COUNTY	TOTAL SHEETS	SHEET NO.
90-114R(14HB-4,14,14HB)BR		TAZEWELL	2433	1454
CONTRACT NO. 68620				