


F.A.I. RTE.	SECTION	COUNTY	TOTAL SHEETS	SHEET NO.
90/94	*	COOK	312	4
STA.		TO STA.		
60A62		* (1919.15, 2021-922 PT1 & PT2) R-1		

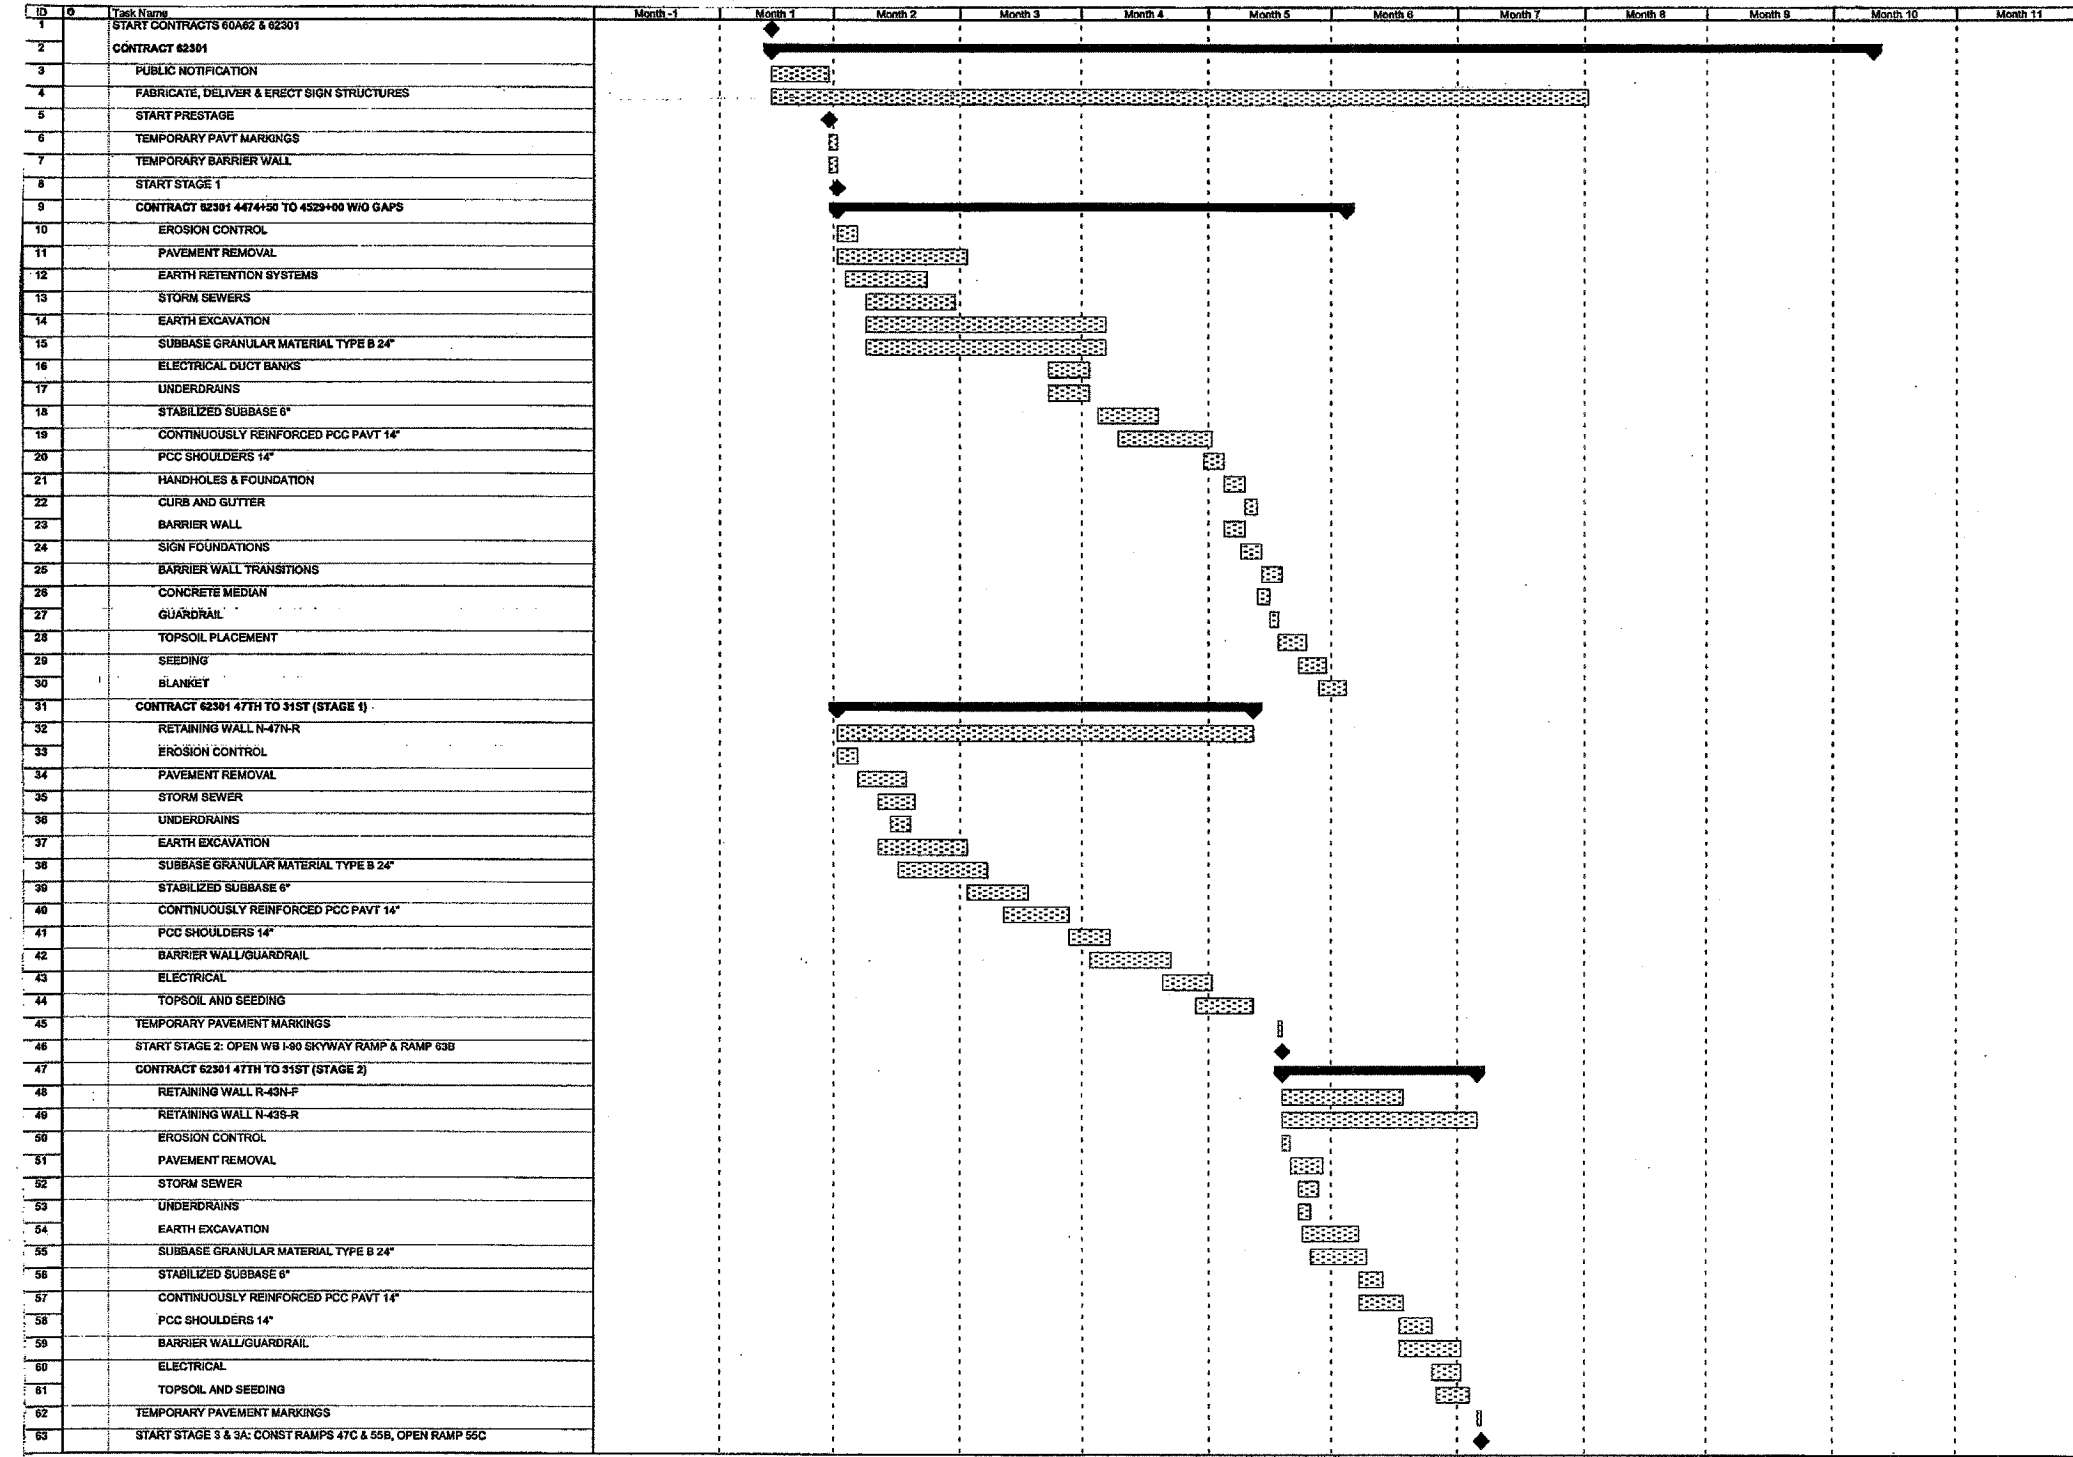

Project: DAN RYAN 18 & 18A Date: Fri 6/2/06

Task: [Pattern] Progress Summary [Pattern] Rolled Up Split [Pattern] Rolled Up Progress [Pattern] Project Summary [Pattern] Deadline [Symbol]

SpR: [Pattern] Milestone [Symbol] Rolled Up Task [Pattern] Rolled Up Milestone [Symbol] External Tasks [Pattern] External Milestone [Symbol]

Page 1



REVISIONS	
NAME	DATE

ILLINOIS DEPARTMENT OF TRANSPORTATION
 F.A.I. 90/94 (DAN RYAN EXPRESSWAY)
 63RD STREET TO GARFIELD BLVD (NB LOCAL LANES)

SUGGESTED SEQUENCE OF OPERATION

SCALE: NONE DRAWN BY: NJH
 DATE: June 9, 2006 CHECKED BY: RMG

P:\PROJECTS\90-94\CONTRACT\180\Scheduled\cs01022.s77
 9-40-06 AM
 6/5/2006