


F.A.I. RTE.	SECTION	COUNTY	TOTAL SHEETS	SHEET NO.
90/94	*	COOK	312	5
STA.		TO STA.		
60A62		ILLINOIS FED. AID PROJECT		
		* (1919.15, 2021-922 PT1 & PT2) R-1		

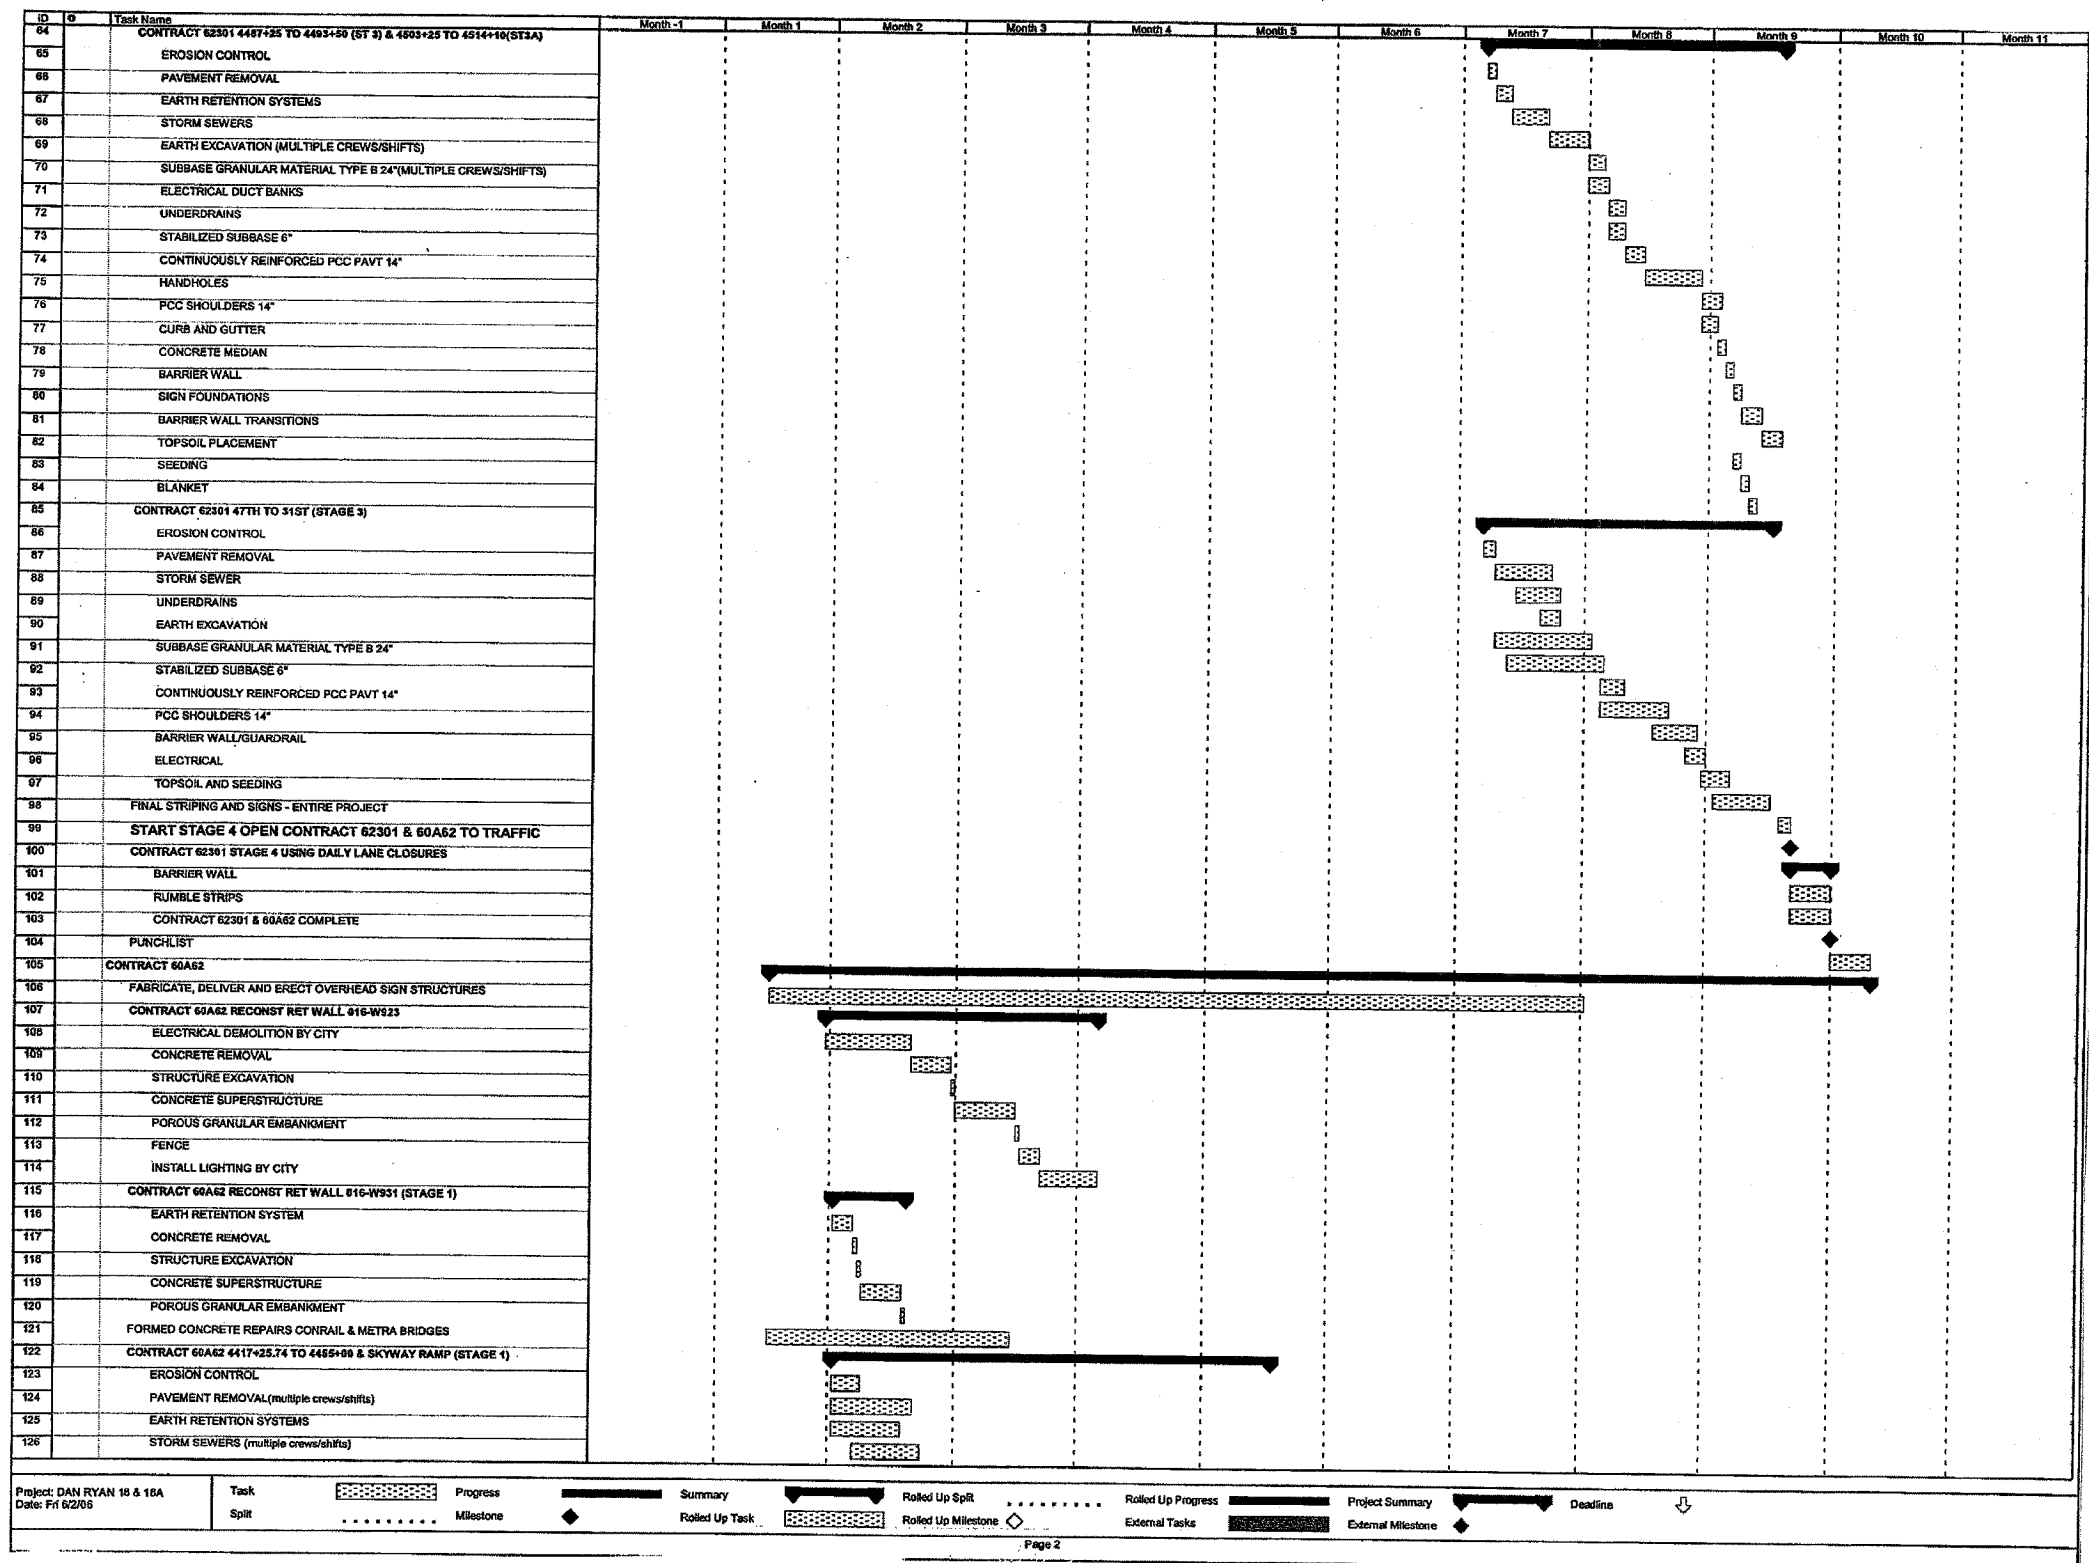

Project: DAN RYAN 18 & 16A Date: Fri 6/2/06

Task Split

Progress Milestone

Summary Rolled Up Task

Rolled Up SpR Milestone

Rolled Up Progress External Tasks

Project Summary External Milestone

Deadline



REVISIONS	
NAME	DATE

ILLINOIS DEPARTMENT OF TRANSPORTATION
 F.A.I. 90/94 (DAN RYAN EXPRESSWAY)
 63RD STREET TO GARFIELD BLVD (NB LOCAL LANES)

SUGGESTED SEQUENCE OF OPERATION

SCALE: NONE DRAWN BY: NJH
 DATE: June 9, 2006 CHECKED BY: RMG

P:\V\10468\01\NB\0115 15 & 16\SP\CONTR 180\schedule\05180022a.rvt
 9-4007 AM
 6/5/2006