


F.A.I. RT#	SECTION	COUNTY	TOTAL SHEETS	SHEET NO.
90/94	*	COOK	312	6
STA.		TO STA.		
60A62		* (1919.15, 2021-922 PT1 & PT2) R-1		

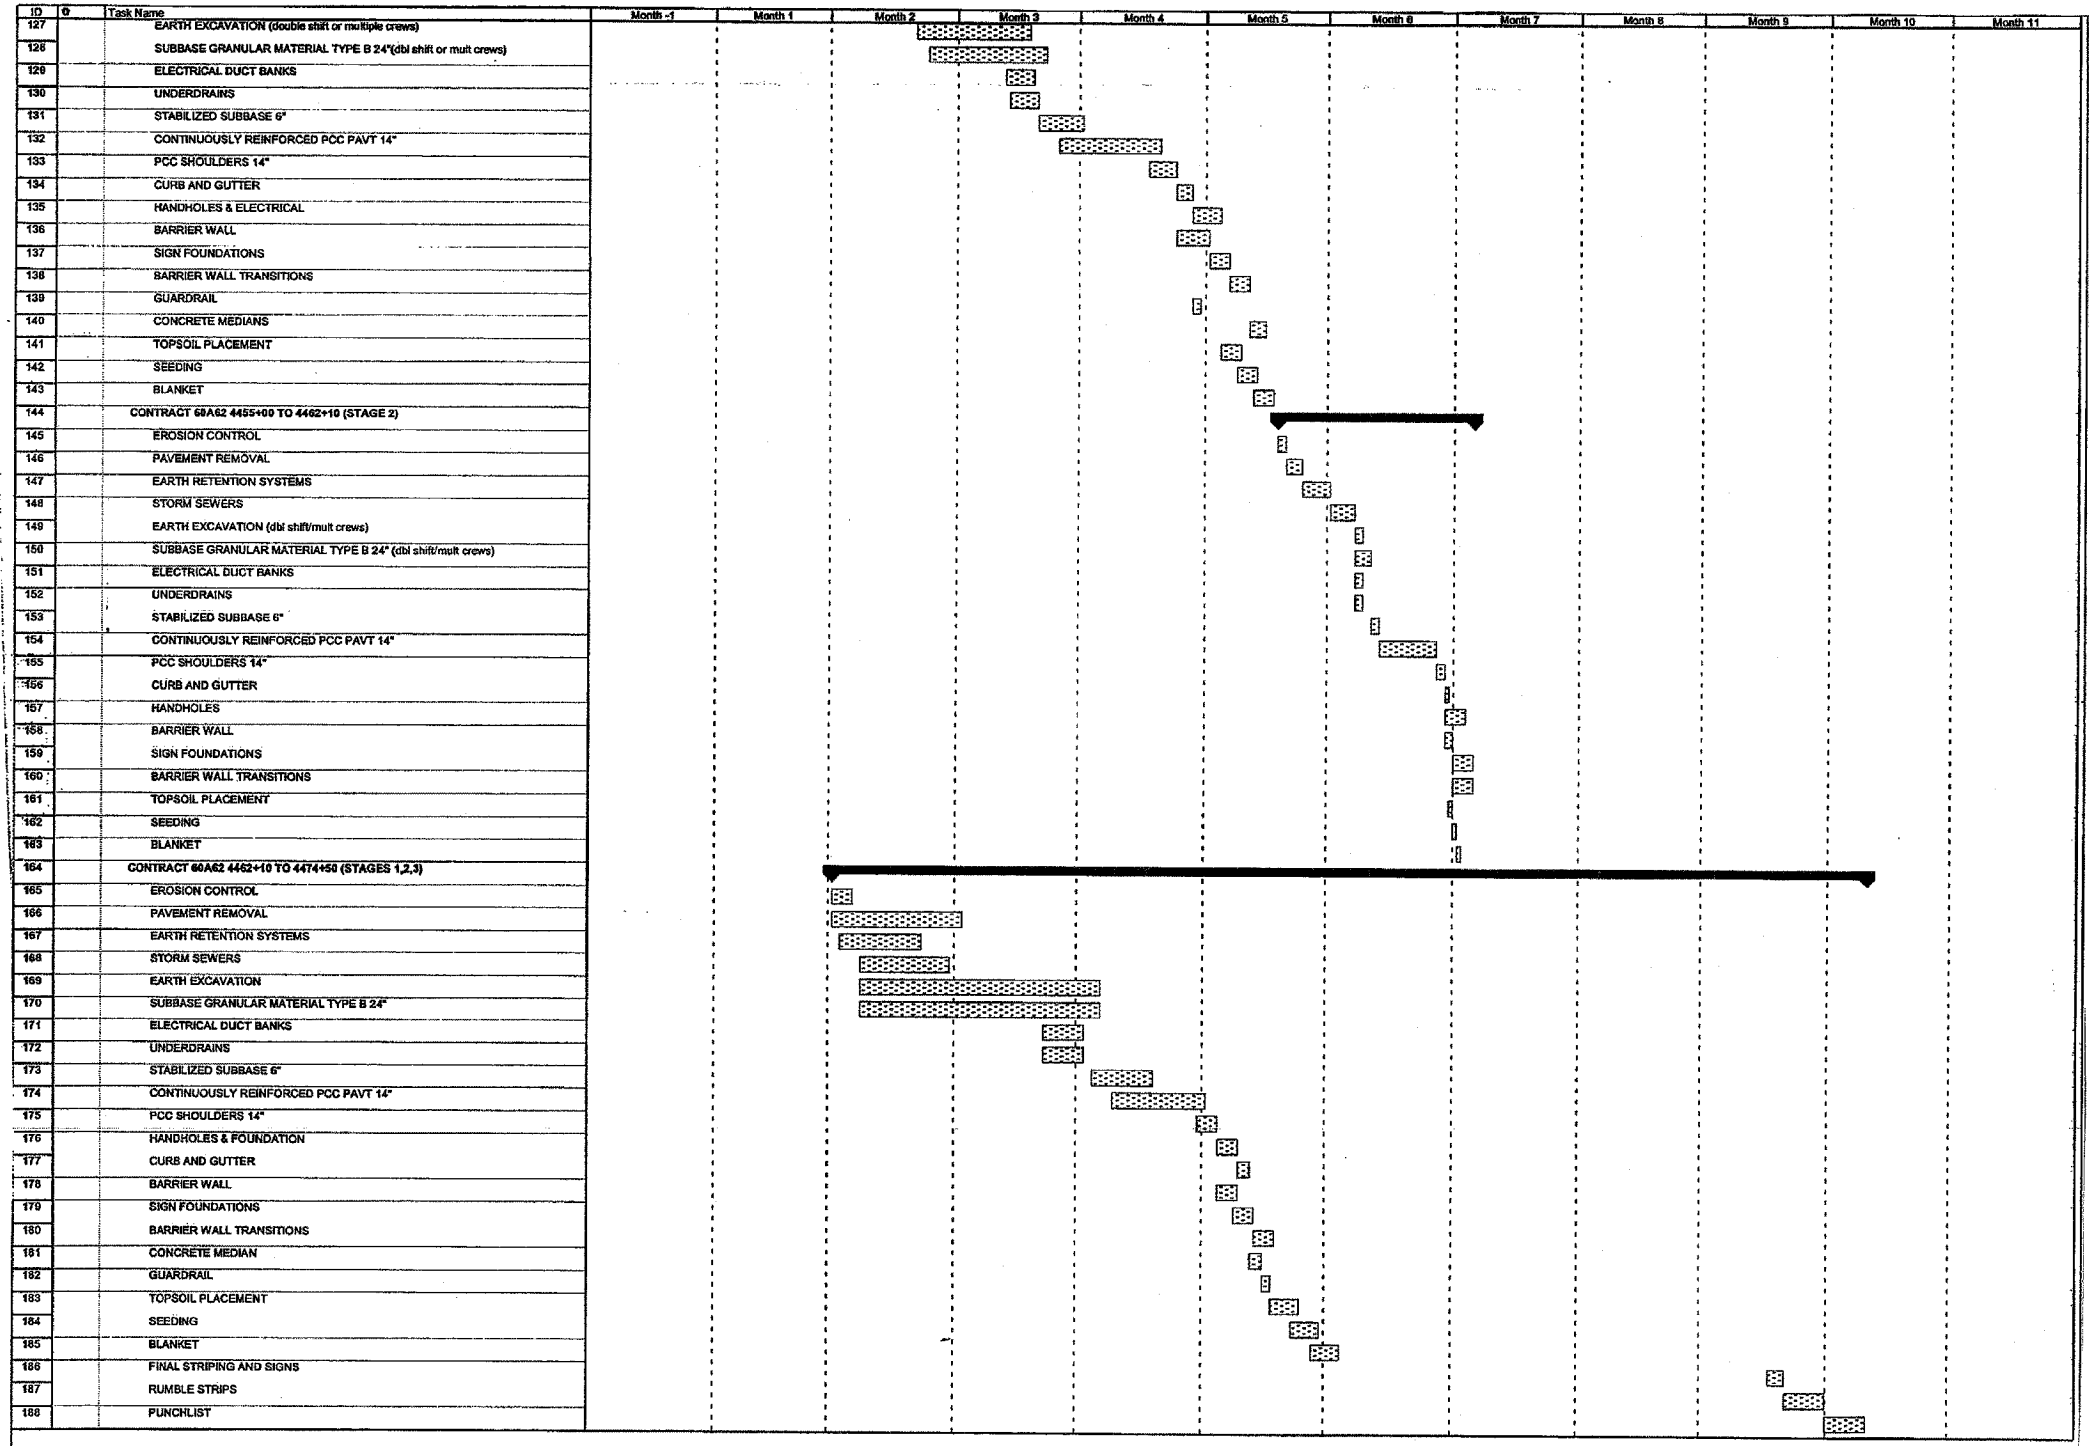

Project: DAN RYAN 18 & 18A Date: Fri 6/2/06

Task Split: [Pattern] Progress Milestone: [Diamond] Summary Rolled Up Task: [Pattern] Rolled Up Split: [Pattern] Rolled Up Milestone: [Diamond] Rolled Up Progress: [Pattern] External Tasks: [Pattern] External Milestone: [Diamond] Project Summary: [Pattern] Deadline: [Arrow]

Page 3



REVISIONS	
NAME	DATE

ILLINOIS DEPARTMENT OF TRANSPORTATION  
 F.A.I. 90/94 (DAN RYAN EXPRESSWAY)  
 63RD STREET TO GARFIELD BLVD (NB LOCAL LANES)

**SUGGESTED SEQUENCE OF OPERATION**

SCALE: NONE DRAWN BY: NJH  
 DATE: June 9, 2006 CHECKED BY: RMC

A:\p04668\c17118\0-anis JB & 15\skt\ntf 160\schedule\cs00032a.rvt CS-3 6/5/2006