


SIGN DETAIL

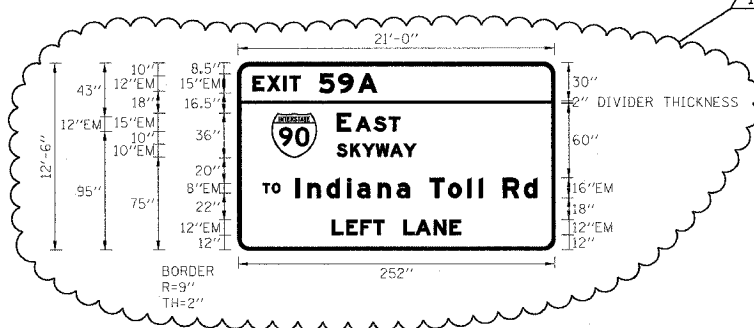


SIGN NUMBER	ISO161094R058.1 LT
WIDTH x HEIGHT	21'-0" x 12'-6"
BORDER WIDTH	2"
CORNER RADIUS	9"
MOUNTING	OVERHEAD
BACKGROUND	TYPE: REFLECTIVE COLOR: GREEN
LEGEND/BORDER	TYPE: REFLECTIVE COLOR: WHITE

SYMBOL	X	Y	WID	HT
ML1	26.7	74	36	36

DIMENSIONS ARE IN INCHES.TENTHS LETTER LOCATIONS ARE PANEL EDGE TO LOWER LEFT CORNER

LETTER POSITIONS (X)										LENGTH SERIES, SIZE						
E	X	I	T	S	9	A				98.7	EM12,EM15					
12	23.3	36.1	41	64.8	79.8	95.7										
E	A	S	T							50.3	EM15,EM12					
78.7	93.7	108.2	120.2													
S	K	Y	W	A	Y					63.2	EM10					
78.7	89.3	98.9	109.7	121	131.8											
T	O									14.2	EM8					
20.5	28															
I	n	d	I	a	n	a	T	o	I	I	R	d	192.2	EM16/12		
45.8	55.4	70.6	86.9	94.9	111.2	126.4	136.5	152.5	167.3	182.7	191.8	194.8	210.8	227.8		
L	E	F	T	L	A	N	E								102.4	EM12
74.8	86.1	97.4	107.8	131.6	141.3	155.8	168.4									

SIGN DETAIL

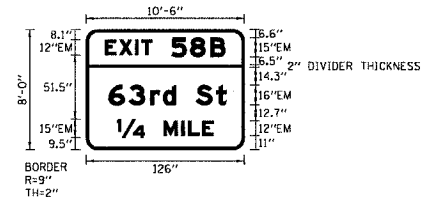


SIGN NUMBER	ISO161094R058.1 RT
WIDTH x HEIGHT	10'-6" x 8'-0"
BORDER WIDTH	2"
CORNER RADIUS	9"
MOUNTING	OVERHEAD
BACKGROUND	TYPE: REFLECTIVE COLOR: GREEN
LEGEND/BORDER	TYPE: REFLECTIVE COLOR: WHITE

SYMBOL	X	Y	WID	HT

DIMENSIONS ARE IN INCHES.TENTHS LETTER LOCATIONS ARE PANEL EDGE TO LOWER LEFT CORNER

LETTER POSITIONS (X)										LENGTH SERIES, SIZE	
E	X	I	T	S	8	B				95.7	EM12,EM15
15.2	26.4	39.3	44.1	67.9	83	98.9					
6	3	r	d	S	t					93.6	EM16/12
18	34.1	51	61.2	71.4	87.4	103.5					
1/4	M	I	L	E						76.6	EM15,EM12
24.7	61.7	75.8	81.2	92.5							

F.A.I. RTE.	SECTION	COUNTY	TOTAL SHEETS	SHEET NO.
90/94		COOK	247	100
STA.	TO STA.			
FED. ROAD DIST. NO. 1		ILLINOIS	FED. AID PROJECT	
60A63		(1919.15, 2021-922 PT1 & PT2) R-2		

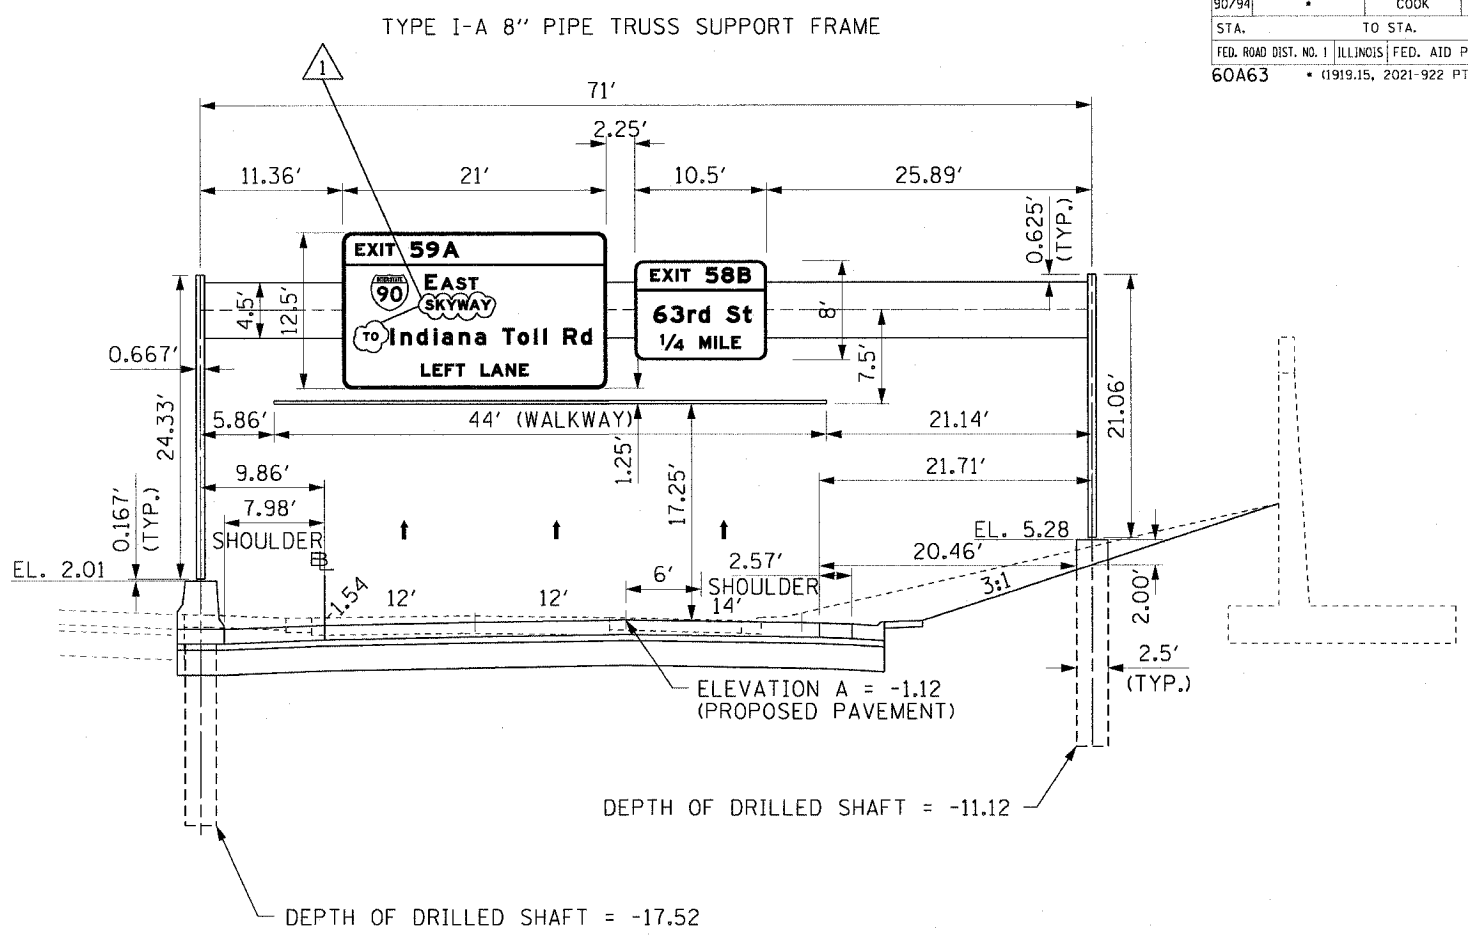

ISO161094R058.1
MOUNTING DETAIL
PROPOSED OVERHEAD SIGN STRUCTURE
STA 3453+00.00 S.B. I-90/94
LOOKING SOUTH

NOTES:

1. PROPOSED PAVEMENT FOR LOCAL LANES IS SHOWN FOR INFORMATION ONLY.
2. REFER TO LIGHTING PLANS FOR ORIENTATION AND LOCATION OF THE CONDUIT EMBEDDED IN THE OVERHEAD SIGN FOUNDATIONS.



REVISIONS	
NAME	DATE
Addendum 1	7/27/06

OSS-2
ILLINOIS DEPARTMENT OF TRANSPORTATION
F.A.I. 90/94 (DAN RYAN EXPRESSWAY)
63RD STREET TO GARFIELD BLVD (SB LOCAL LANES)
PERMANENT SIGN PANEL MOUNTING DETAILS
PROPOSED OVERHEAD SIGN STRUCTURES
STA. 3453+00.00
SCALE: NONE DRAWN BY: JSS
DATE: June 9, 2006 CHECKED BY: MJP

P:\P\060460\060460-01\B-CRFS 18 & 19\SIGN\MTR 19AS\Signing\SS19090022A.DWG 7/27/2006 10:07 PM