



PLAN VIEW
SCALE: 1"=20'

- LEGEND**
- UNDERPASS LUMINAIRE, 70W HPS, MOUNTED 2' FROM EOP
 - JUNCTION BOX ATTACHED TO STRUCTURE, SIZE AS SHOWN
 - RIGID GALVANIZED STEEL CONDUIT, ATTACHED TO STRUCTURE, SIZE AS NOTED


NOTE: ALL RIGID GALVANIZED STEEL CONDUIT ATTACHED TO STRUCTURE REFERENCED ON THIS SHEET SHALL BE PVC COATED.

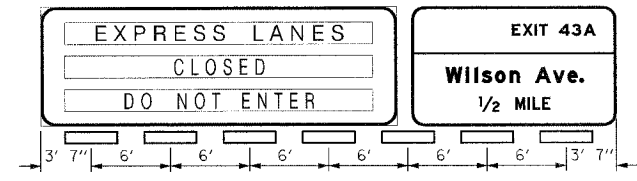

PROPOSED BRIDGE MOUNTED SIGN STRUCTURE LUMINAIRE SPACING ATTACHED TO NORTH FACE OF FOSTER AVE. BRIDGE ACROSS THE EDENS EXPRESSWAY (SEE IDOT STANDARD DETAIL ON SHEET E-15 FOR ELECTRICAL DETAILS)

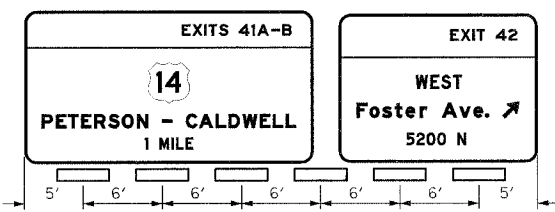

PROPOSED BRIDGE MOUNTED SIGN STRUCTURE LUMINAIRE SPACING ATTACHED TO SOUTH FACE OF FOSTER AVE. BRIDGE ACROSS THE EDENS EXPRESSWAY (SEE IDOT STANDARD DETAIL ON SHEET E-15 FOR ELECTRICAL DETAILS)

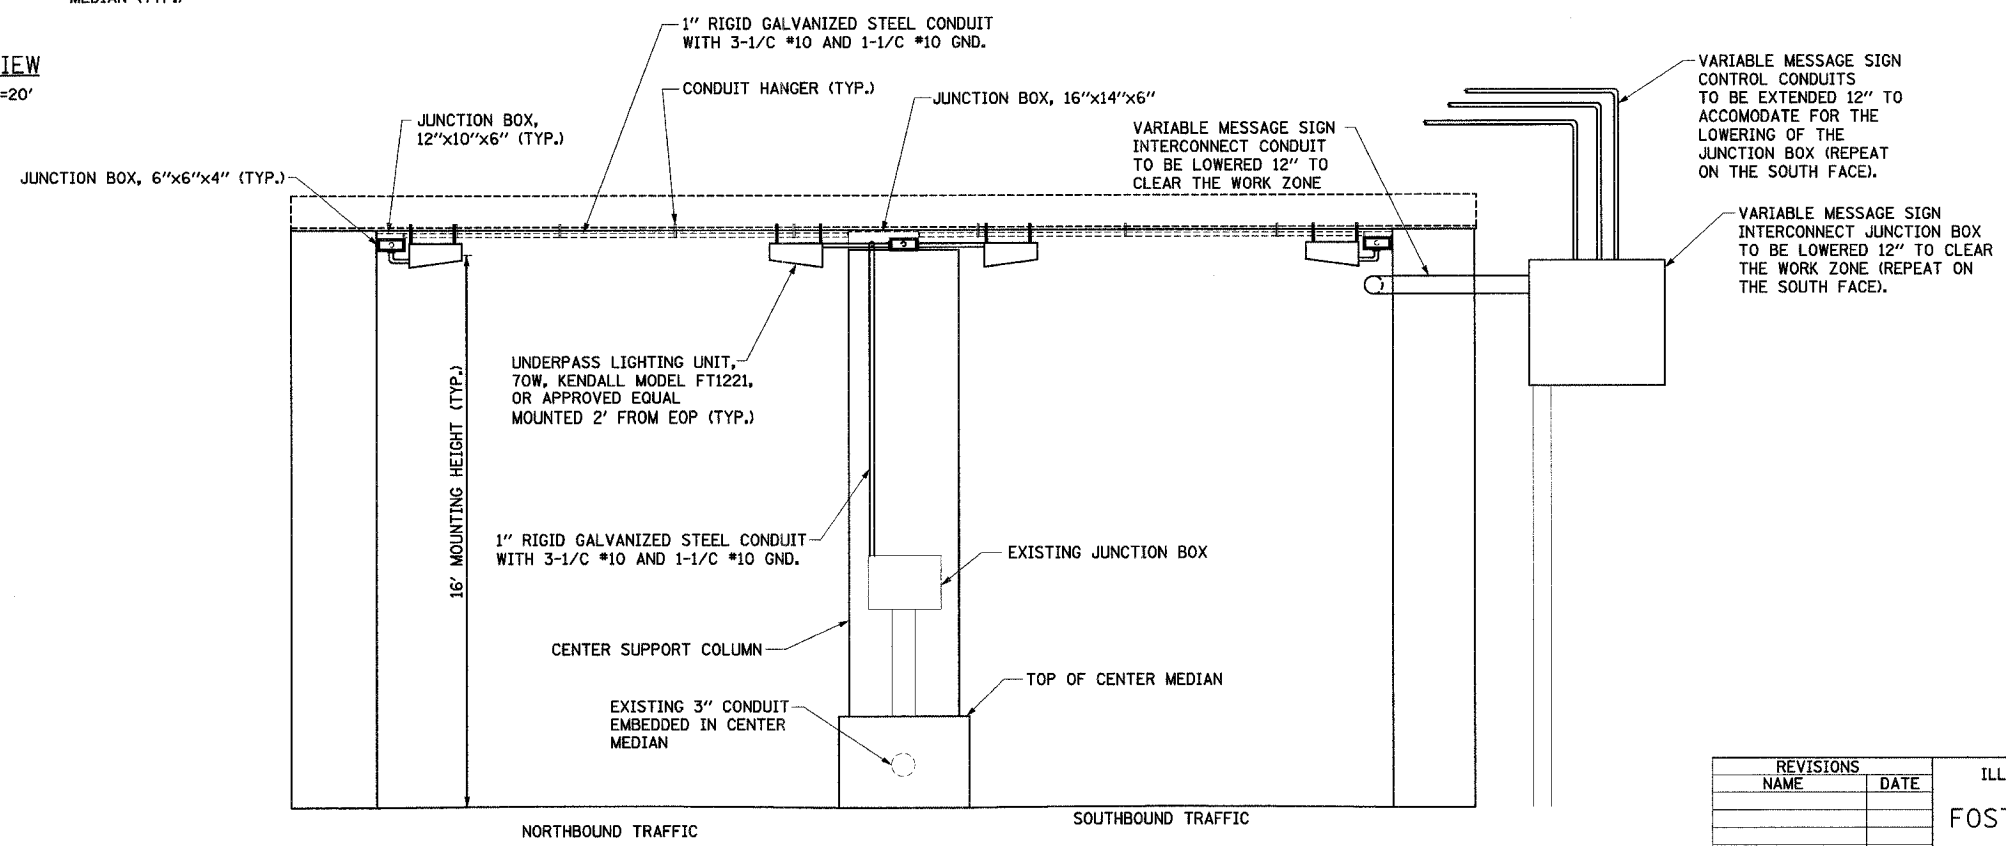

SECTION A-A
NTS

EJM EJM ENGINEERING, INC.
411 South Wells Street Suite 800
Chicago, Illinois 60607

ILLINOIS DEPARTMENT OF TRANSPORTATION
FOSTER AVE. BRIDGE OVER I-94
PROPOSED UNDERPASS AND
PROPOSED SIGN LIGHTING PLAN

REVISIONS	
NAME	DATE

SCALE: NONE
DATE: JUNE 30, 2006
DRAWN BY: JDM
CHECKED BY: RES

6/29/2006 5:54:55 PM I:\1182519\cadd\civil\1182519-05.dgn