


F.A.I. RTE.	SECTION	COUNTY	TOTAL SHEETS	SHEET NO.
90/94	*	COOK	588	4
STA.		TO STA.		
62303		* (2021-922 PT2 ETC 2324.6-1P) R-11		

 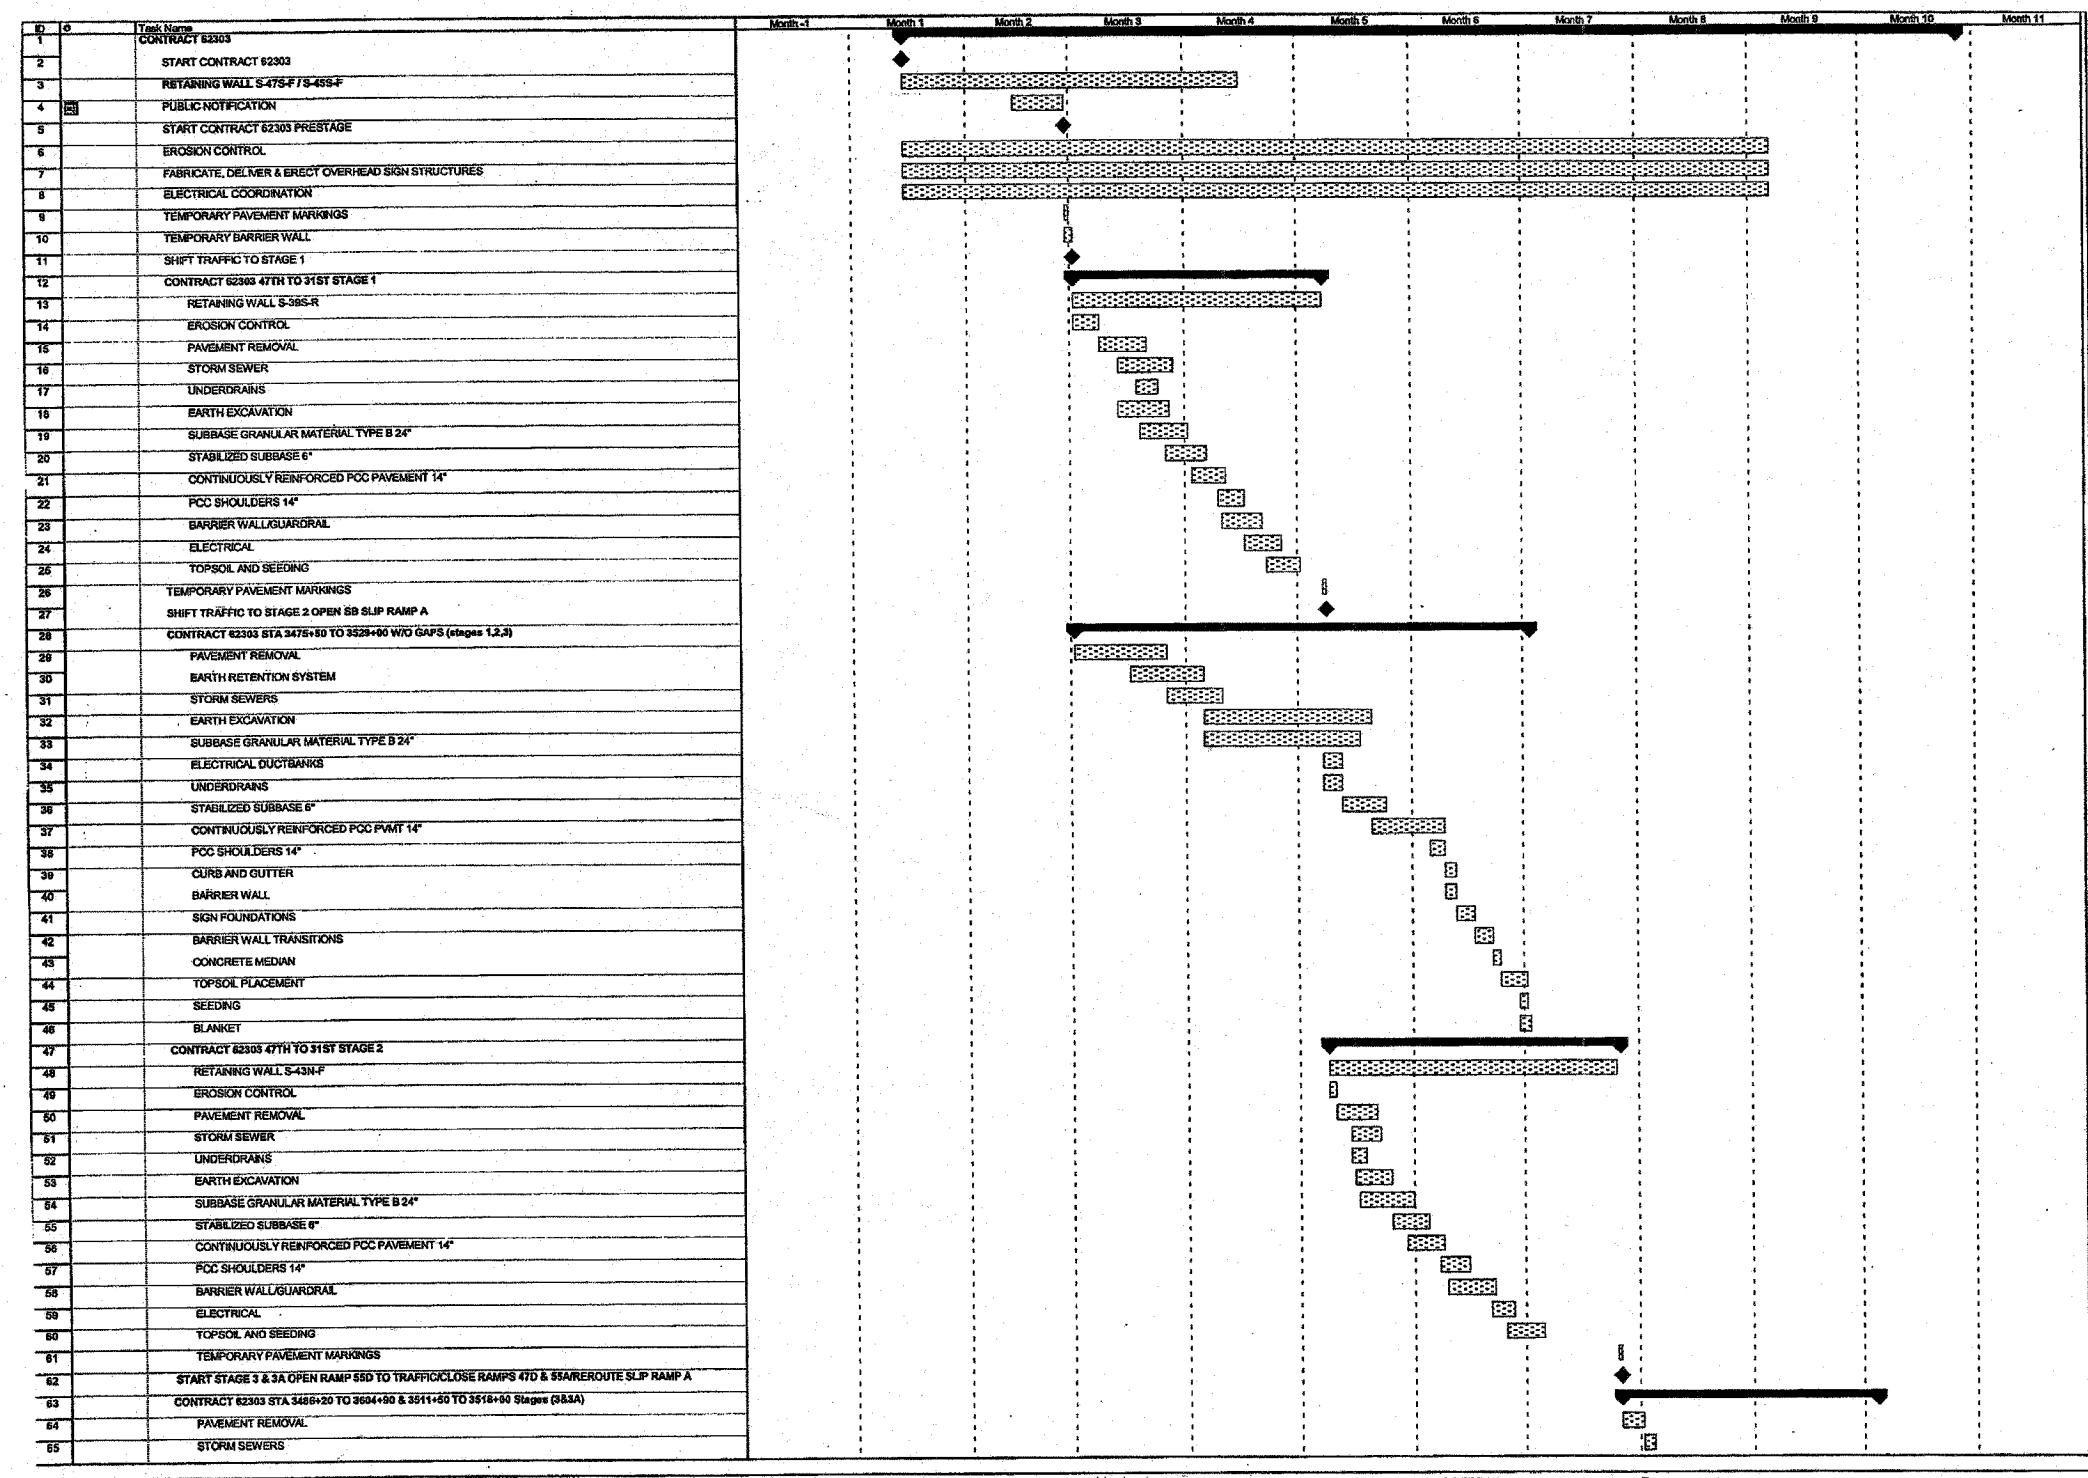


Project: DANRYAN10819A REV3 Date: Fri 6/2/06

Task: [Pattern] Progress: [Pattern] Summary: [Pattern] Rolled Up Split: [Pattern] Rolled Up Progress: [Pattern] Project Summary: [Pattern] Deadline: [Pattern]

Split: [Pattern] Milestone: [Pattern] Rolled Up Task: [Pattern] Rolled Up Milestone: [Pattern] External Tasks: [Pattern] External Milestone: [Pattern]

Page 1



REVISIONS	
NAME	DATE

CS-1

ILLINOIS DEPARTMENT OF TRANSPORTATION
F.A.I. 90/94 (DAN RYAN EXPRESSWAY)
GARFIELD BLVD TO 31ST STREET (SB LOCAL LANES)

SUGGESTED SEQUENCE OF OPERATION

SCALE: NONE DRAWN BY: NJH
DATE: June 9, 2006 CHECKED BY: RMC

6/6/2006 7:31:05 PM