


EXISTING

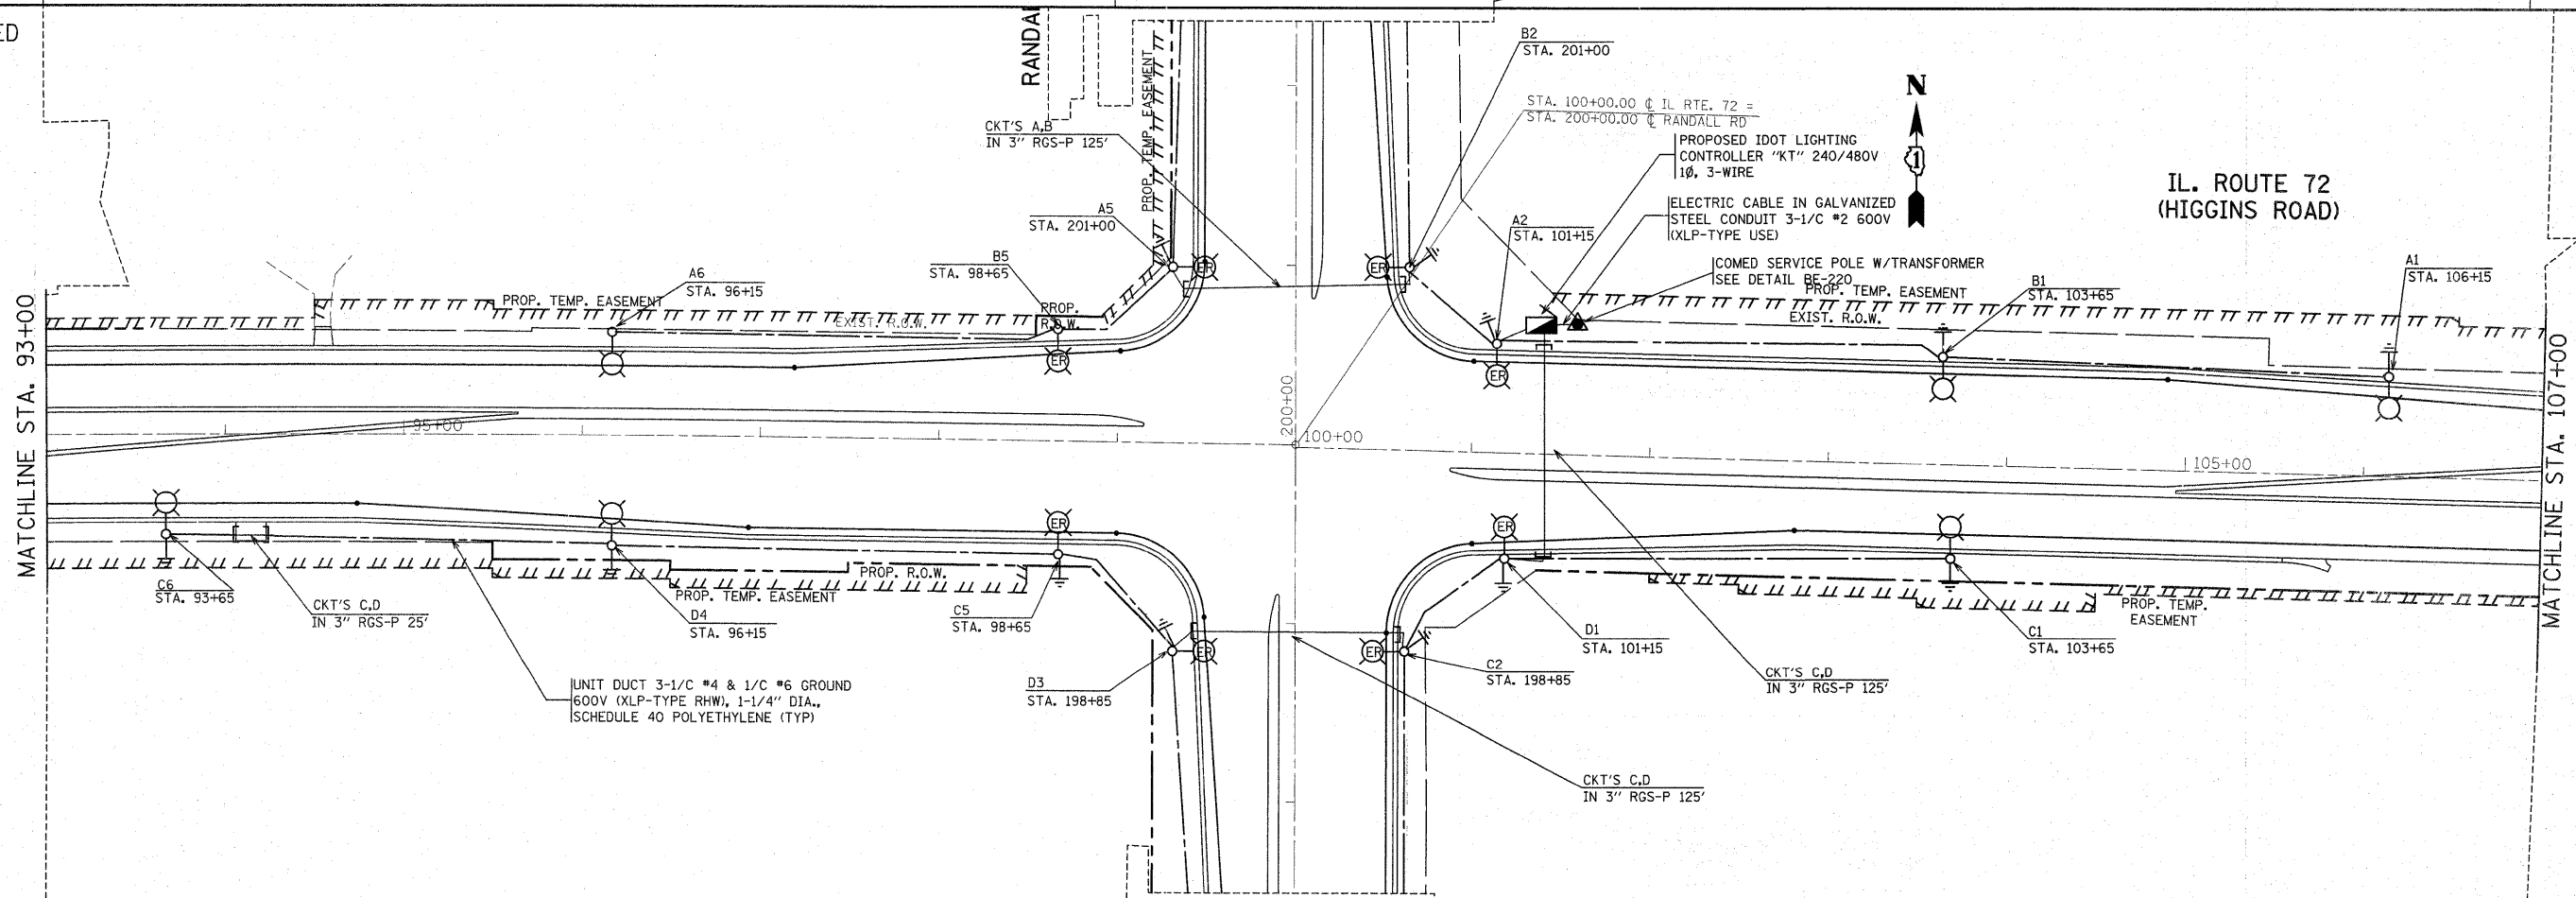

PROPOSED

FILE NAME = P110008-light.dgn

USER NAME = cubica
 PLOT SCALE = 50.0000' / IN.
 PLOT DATE = 3/22/2011

DESIGNED - AC
 DRAWN -
 CHECKED -
 DATE - 3/2011

REVISED -
 REVISED -
 REVISED -
 REVISED -

STATE OF ILLINOIS
 DEPARTMENT OF TRANSPORTATION

IL. ROUTE 72 (HIGGINS ROAD) @ RANDALL ROAD
 EXISTING & PROPOSED LIGHTING PLAN
 SCALE: 1" = 50'
 SHEET NO. OF SHEETS STA. 93+00.00 TO STA. 107+00.00

F.A.P. RTE.	SECTION	COUNTY	TOTAL SHEETS	SHEET NO.
341	62-N-1	KANE	143	83
CONTRACT NO. 60K09				
ILLINOIS FED. AID PROJECT				

E2