



**TYPICAL SPLICE DETAIL**  
N.T.S.

NOTE THAT NUMBER OF CABLES IN SPLICE MAY VARY

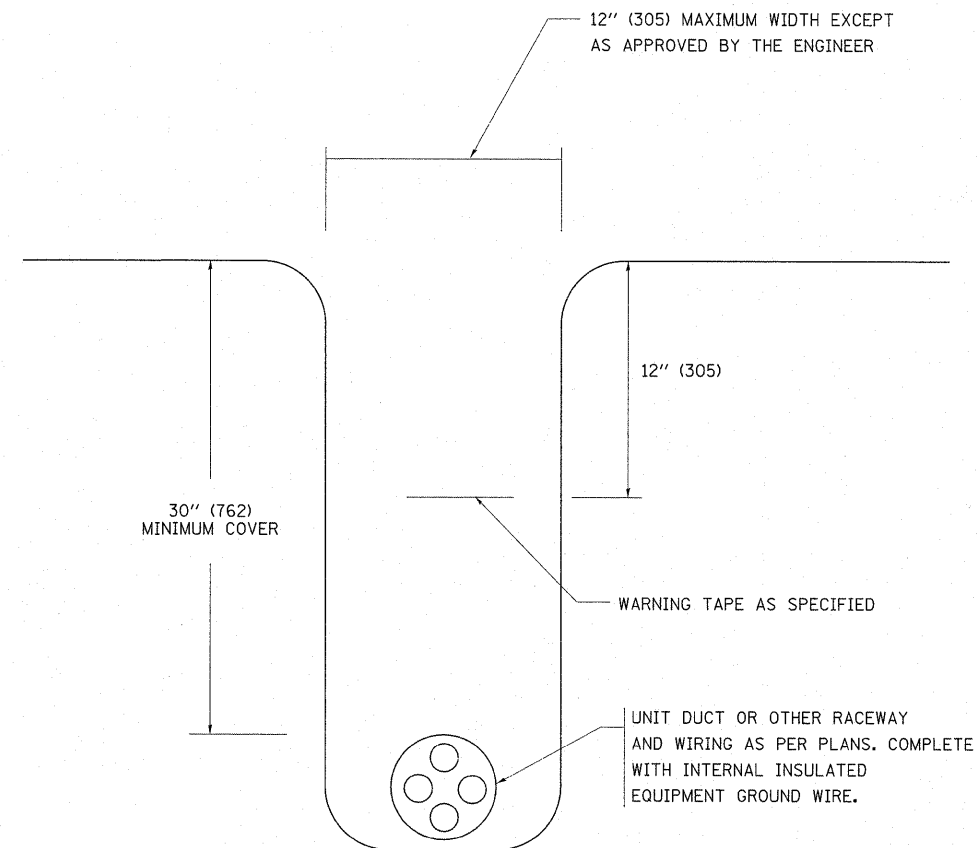

**TYPICAL WIRING IN TRENCH DETAIL**  
N.T.S.

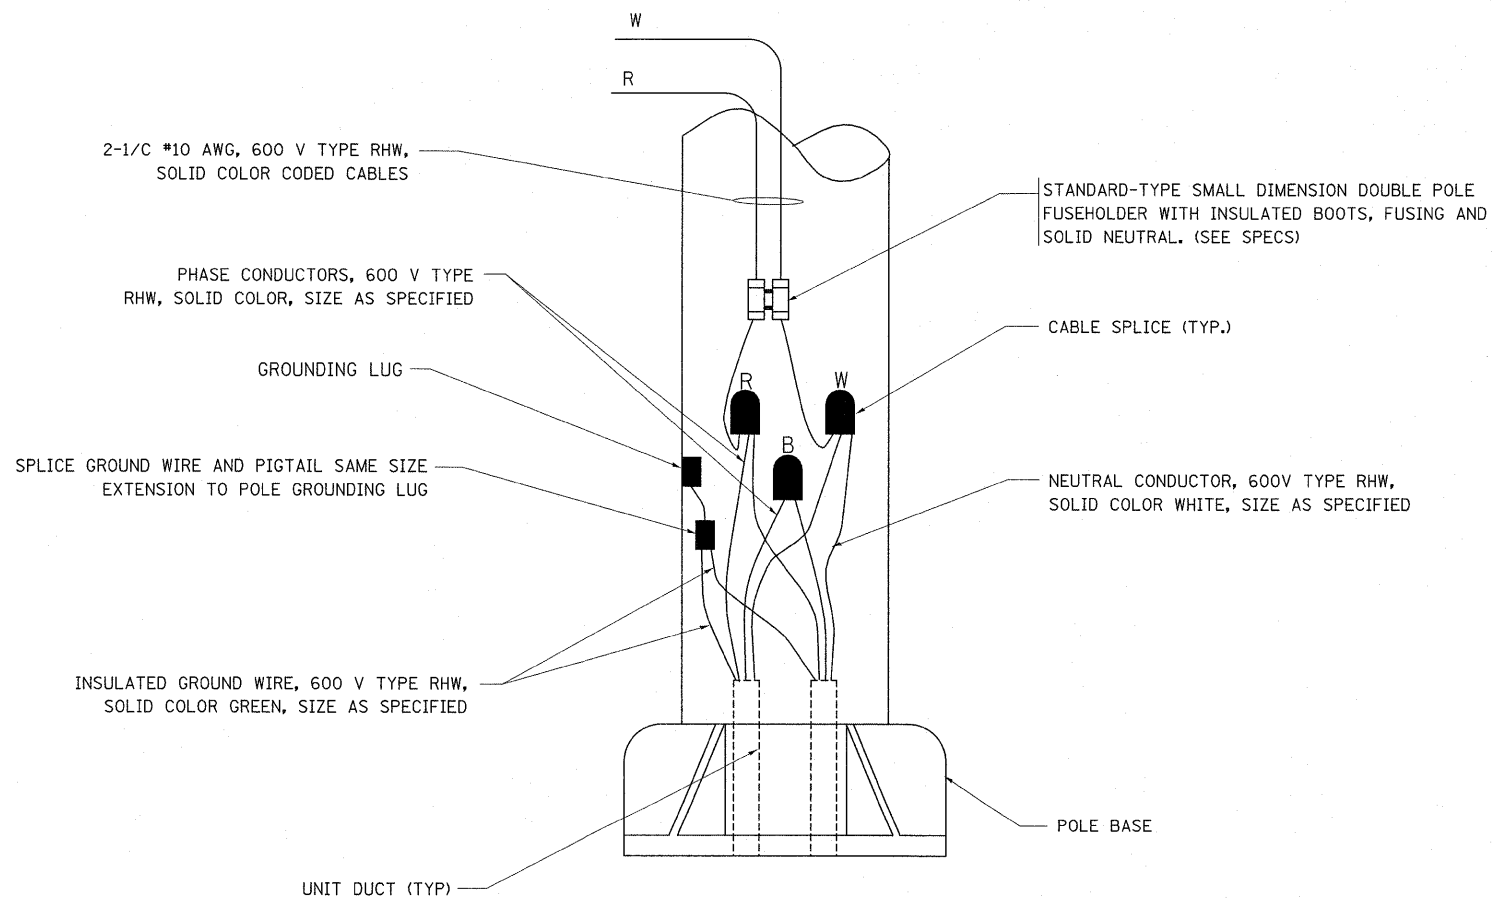

**POLE WIRING DETAIL**  
N.T.S.

FILE NAME =	USER NAME = shiransab	DESIGNED -	REVISED - 08-08-03	<b>STATE OF ILLINOIS DEPARTMENT OF TRANSPORTATION</b>	<b>MISC. ELECTRICAL DETAILS SHEET A</b>			F.A.P. RTE.	SECTION	COUNTY	TOTAL SHEETS	SHEET NO.
ca:\pwork\pwork\shiransab\0126931\DistStd.dgn		DRAWN -	REVISED -		341	62-N-1	KANE	148	117			
PLOT SCALE = 50.0000 / IN.		CHECKED -	REVISED -		<b>BE-702</b>			CONTRACT NO. 60K09				
PLOT DATE = 5/27/2011		DATE -	REVISED -		FED. ROAD DIST. NO. 1 ILLINOIS FED. AID PROJECT							
				SCALE: NONE	SHEET NO. 1 OF 1 SHEETS	STA.	TO STA.					