



F.A.I. RTE.	SECTION	COUNTY	TOTAL SHEETS	SHEET NO.
94/90	*	COOK	598	384
STA.		TO STA.		
FED. ROAD DIST. NO. 1		ILLINOIS FED. AID PROJECT		

62302 *1818, ETC, 2324.6-1PR-9

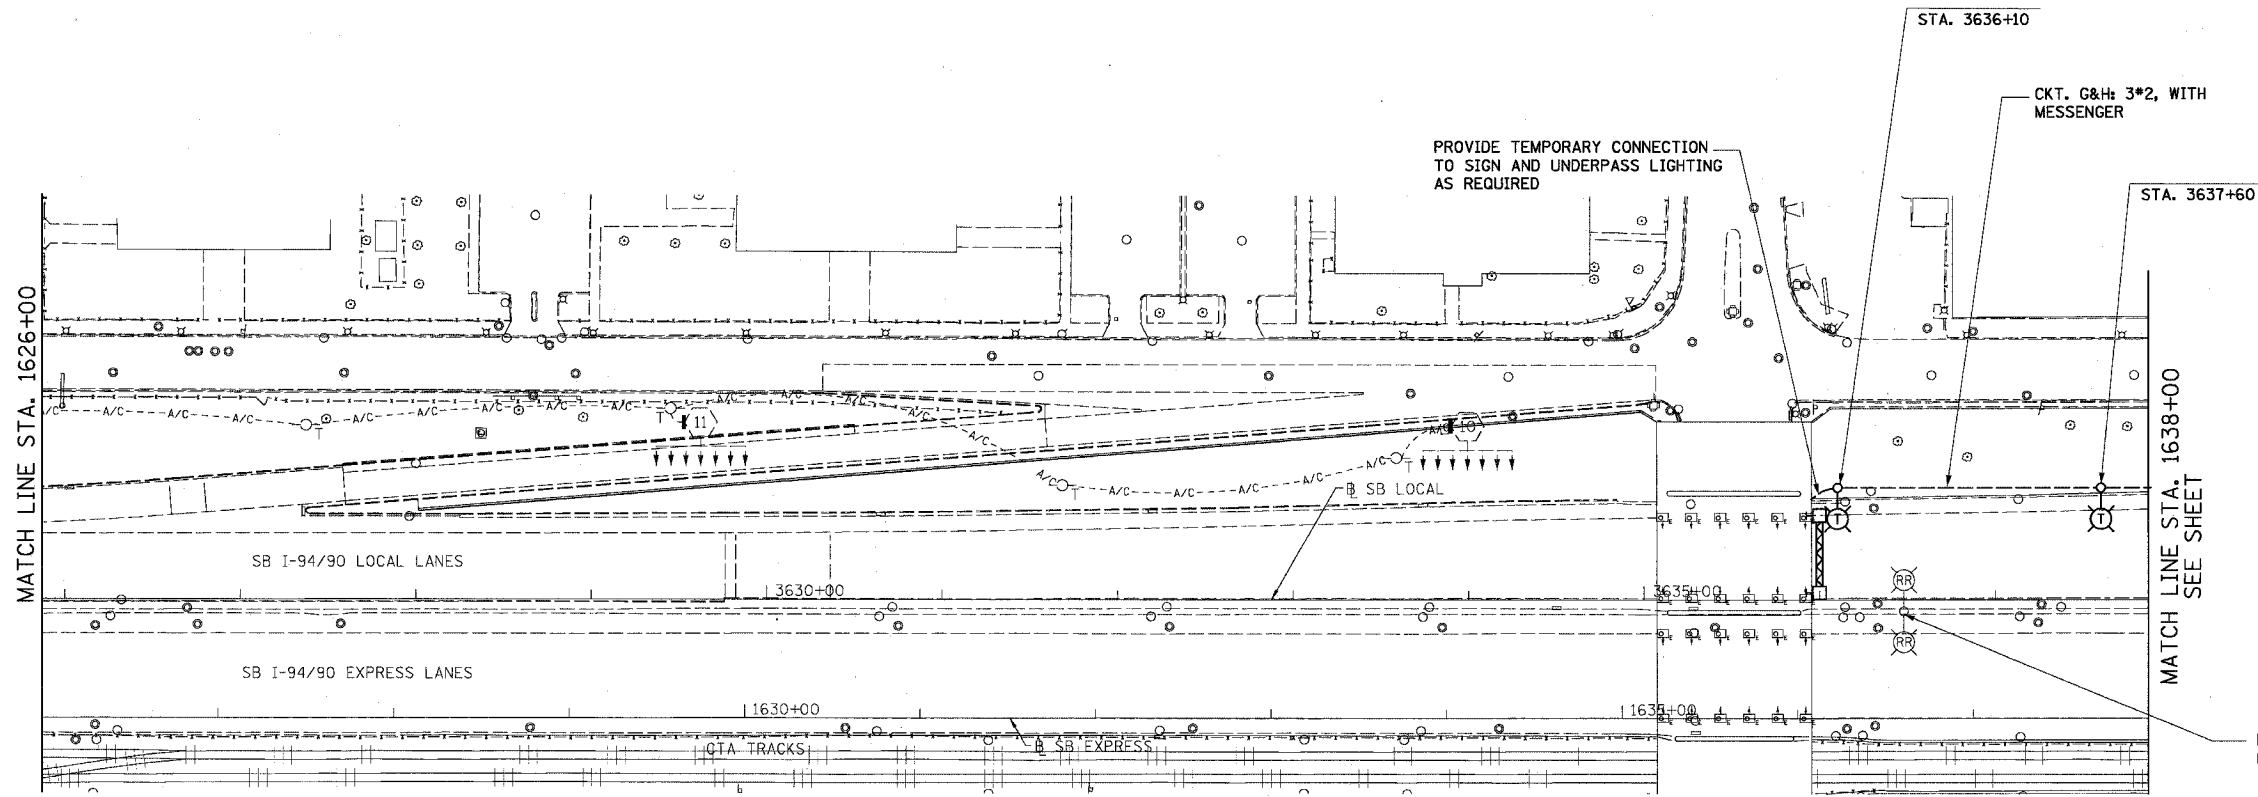

- NOTES:**
- TEMPORARY LIGHTING UNITS SHALL BE SET BACK 20 FT FROM EDGE OF PAVEMENT.
 - EXISTING LIGHTING UNITS SHALL BE REMOVED AND STORED.
 - SEE DRAWINGS EI-100 AND EI-101 FOR ELECTRICAL SYMBOLS AND ABBREVIATIONS.

EXISTING CONDITIONS AND REMOVAL

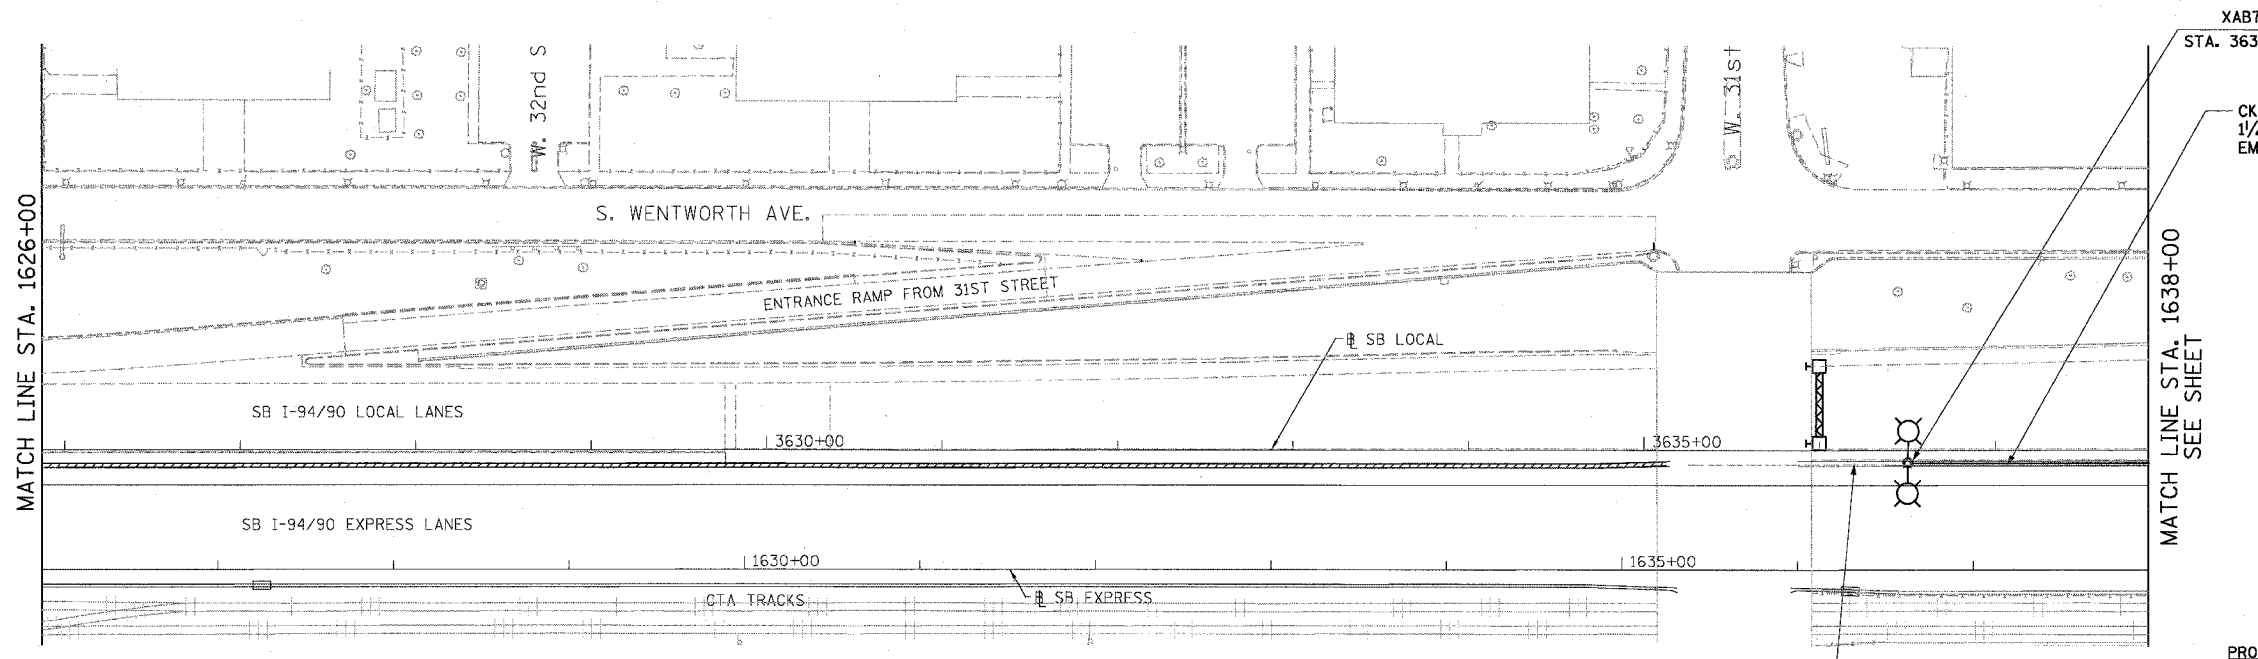


- NOTES:**
- EXISTING LIGHTING UNITS SHALL BE RE-INSTALLED ON THE PROPOSED MEDIAN WALL.

PROPOSED CONDITIONS

EL-1

 K&E KAM ENGINEERING, INC.
CONSULTING ENGINEERS
707A Davis Road, Suite 205
Elgin, Illinois 60123-1369



REVISIONS	NAME	DATE

ILLINOIS DEPARTMENT OF TRANSPORTATION
F.A.I. 94/90 (DAN RYAN EXPRESSWAY)
31ST STREET TO 71ST STREET
SB EXPRESS LANE RECONSTRUCTION
EXISTING AND PROPOSED LIGHTING PLAN

SCALE: DATE: 06-03-05

DRAWN BY: BL
CHECKED BY: RC

7-2-1006 PM 6/27/2005