


STATION 711+00
MATCH LINE

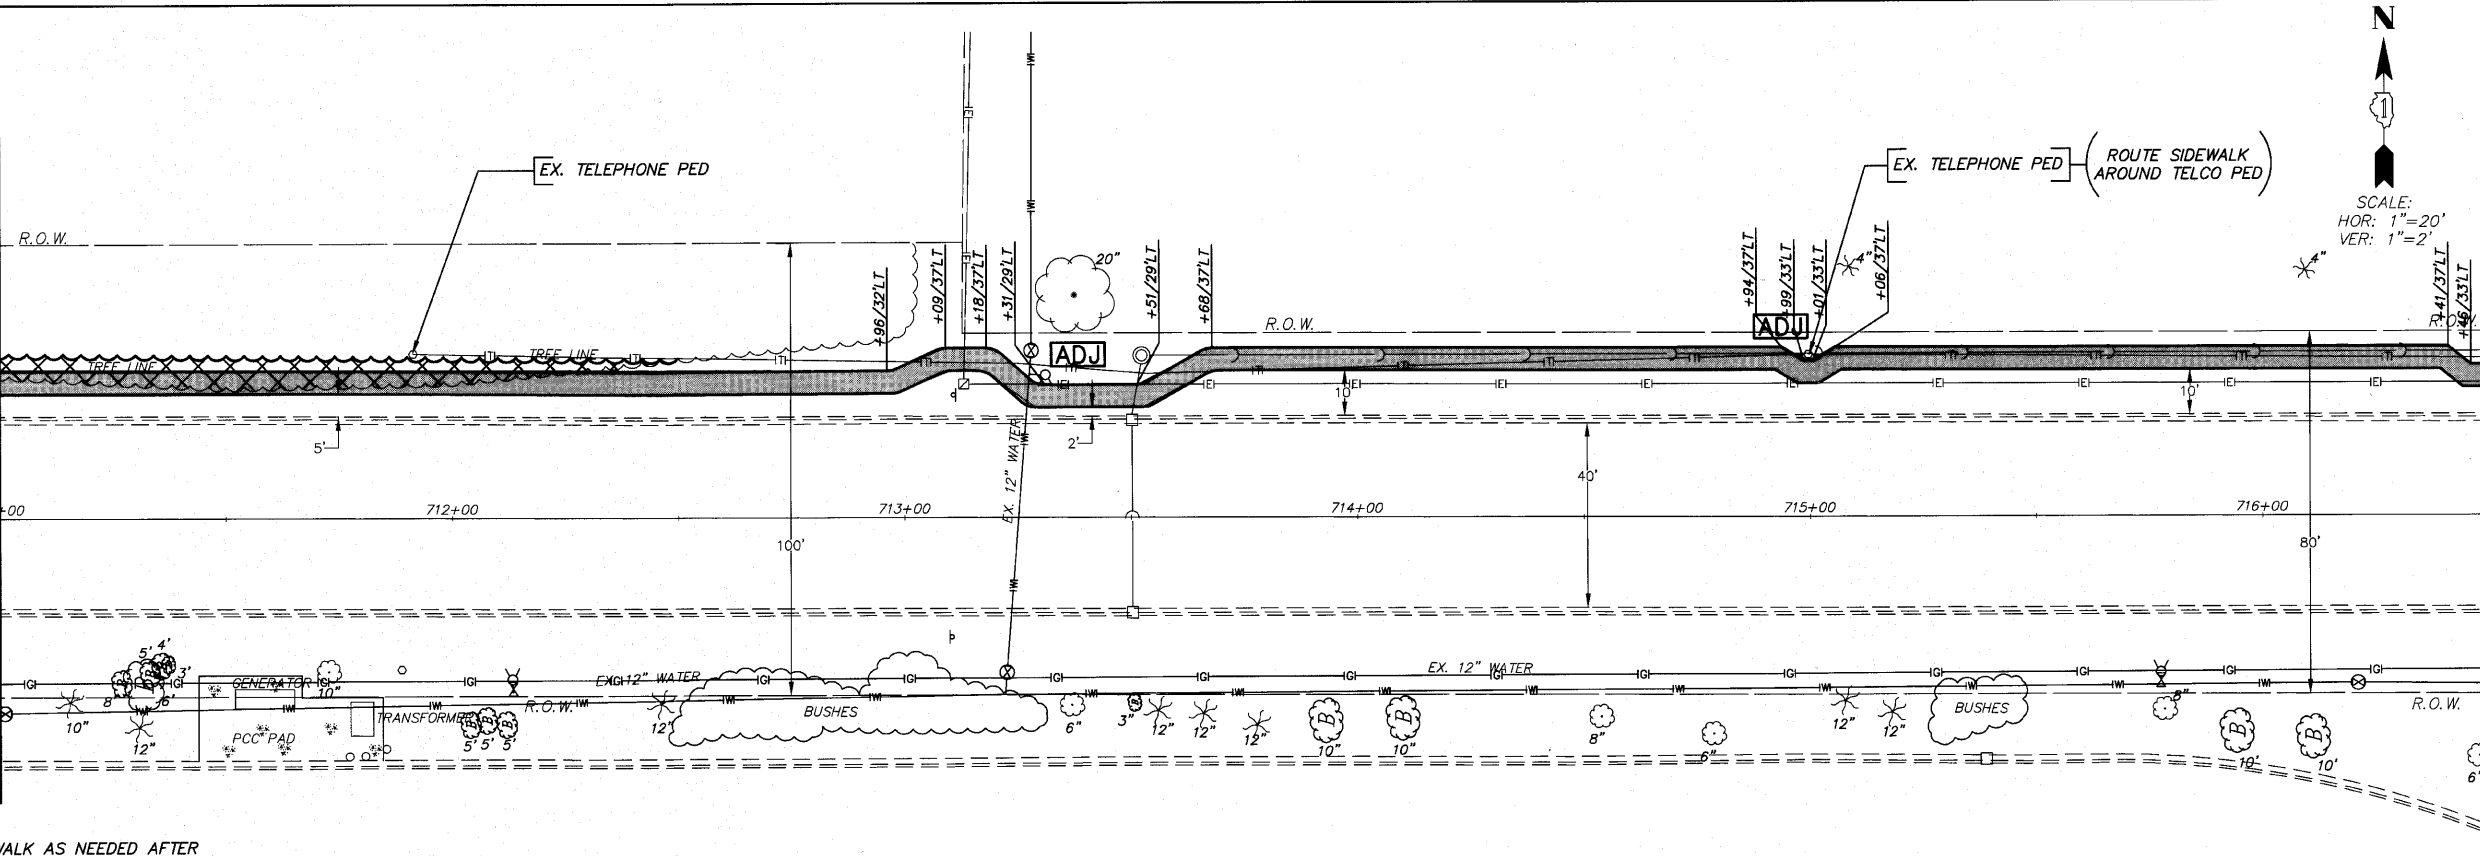


STATION 716+50
MATCH LINE

SCALE:
HOR: 1"=20'
VER: 1"=2'

- NOTE:
1. ADJUST SIDEWALK AS NEEDED AFTER UNDERGROUND UTILITIES HAVE BEEN LOCATED IN FIELD.
 2. ELECTRIC CONDUIT SHOWN IS BELIEVED TO BE 3" W/ 37 CONDUCTORS
 3. SEE SHEET 2, NOTE 28 FOR SIDEWALK ALIGNMENT REQUIREMENTS

HOOK DRIVE

SUPPLEMENTAL LEGEND

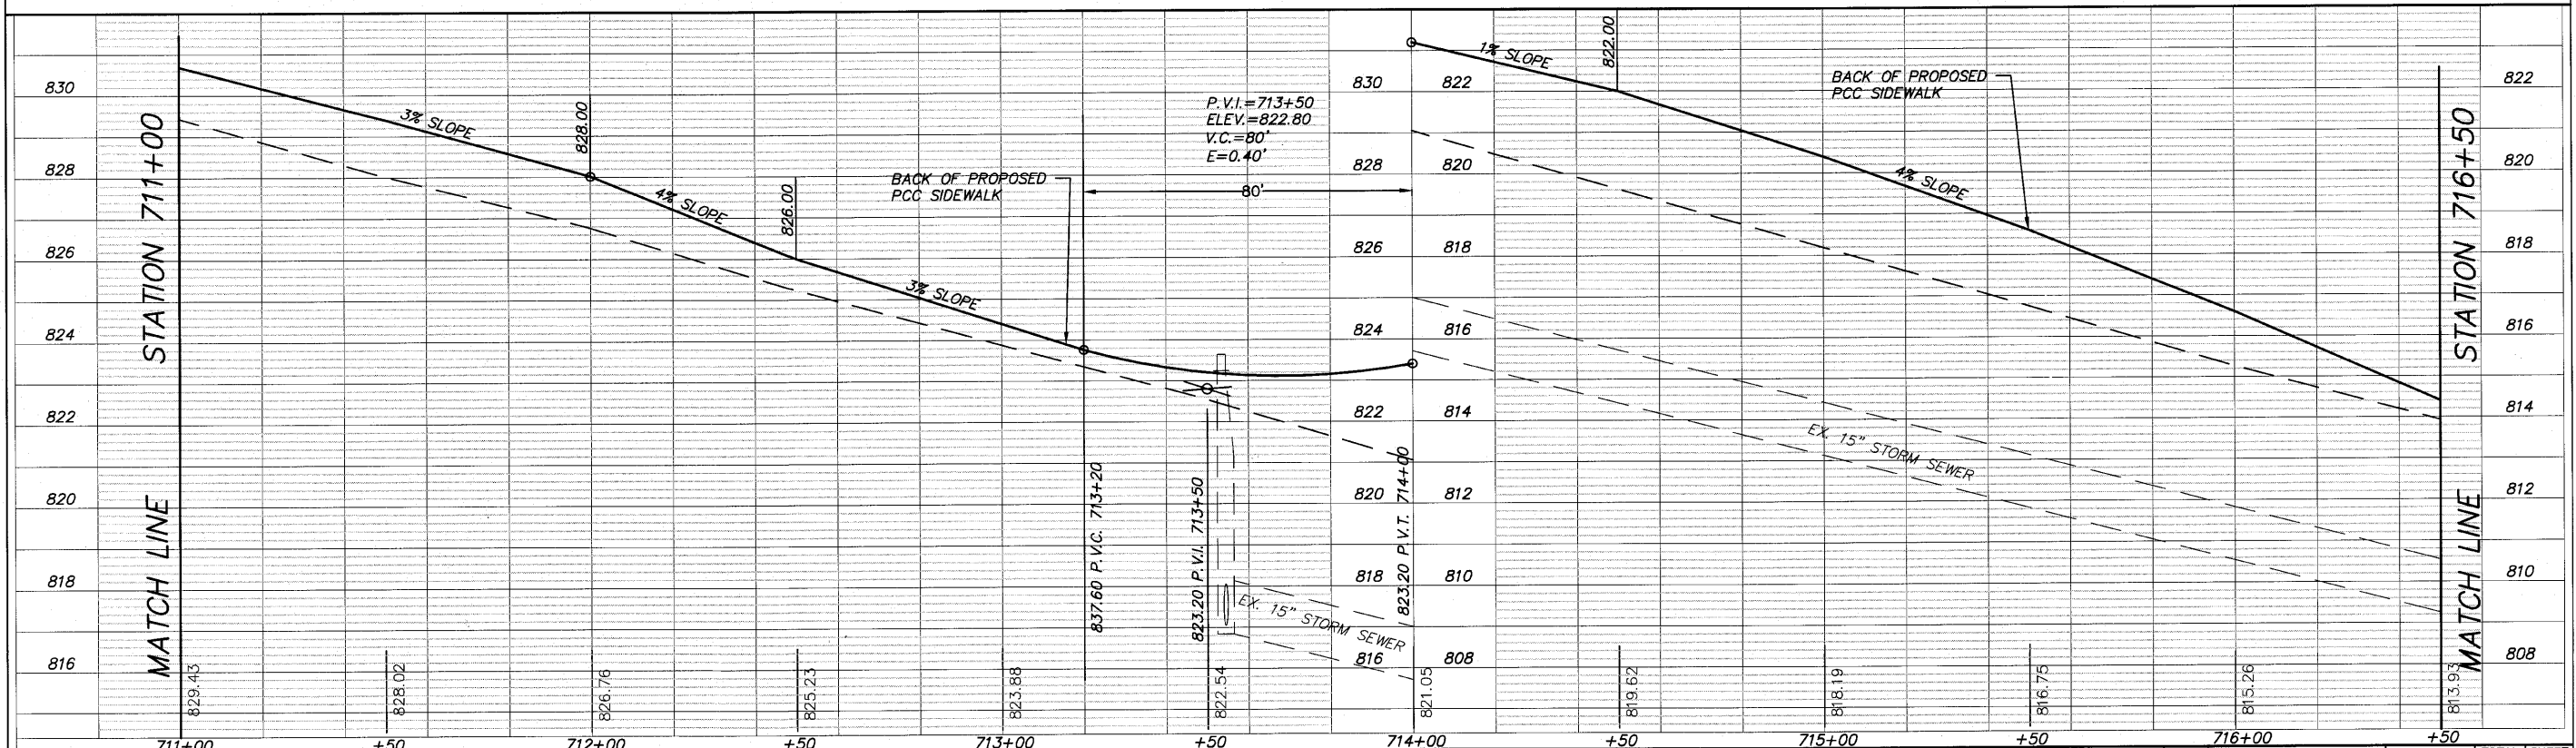

FILE NAME = 102589HOOK04.DWG	USER NAME =	DESIGNED = RJD	REVISED =	STATE OF ILLINOIS DEPARTMENT OF TRANSPORTATION	PLAN AND PROFILE			F.A. RTE.	SECTION	COUNTY	TOTAL SHEETS	SHEET NO.
	FILE NAME =	DRAWN = EC	REVISED =		SCALE: 1"=20'	SHEET NO. 19 OF 75 SHEETS	STA. 711+00 TO STA. 716+50	10-00073-00-SW	LAKE	75	19	
	PLOT SCALE =	CHECKED = RJD	REVISED =					CONTRACT NO. 63467				
	PLOT DATE =	DATE = 01/19/10	REVISED =					ILLINOIS FED. AID PROJECT				