 



 
NEW LIGHTING CONTROLLER CIRCUIT SCHEDULE						
	CIRCUIT	BREAKER	TOTAL LOAD	TOTAL LOAD(AMPS)	C/B SIZE	VOLTS
1	NORTHWEST	A, B	1,107W	4.6	30A/2P	240
2	NORTHEAST	C, D	1,080W	4.5	30A/2P	240
3	SOUTHEAST	E, F	2,031W	8.5	30A/2P	240
4	SOUTHWEST	G, H	2,226W	9.3	30A/2P	240
5	NORTHWEST	I, J	1,440W	12.0	(2) 20A/1P	120 / 240
6	NORTHEAST	K, L	900W	7.5	(2) 20A/1P	120 / 240
7	SOUTHEAST	M, N	180W	1.5	(2) 20A/1P	120 / 240
8	SOUTHWEST	O, P	360W	3.0	(2) 20A/1P	120 / 240


LUMINAIRE SCHEDULE		
LIGHTING FIXTURE	WATTAGE	DESCRIPTION
P1	90W	240V, 75W, PEDESTRIAN LUMINAIRE, TYPE III CUTOFF
M1	39W	240V, 35W, HID UPLIGHT

**LEGEND**

P1  ORNAMENTAL LIGHT UNIT, COMPLETE

M1  IN GRADE FIXTURE FOR UPLIGHTING

WP GFI  GFCI 20 AMP DUPLEX RECEPTACLE

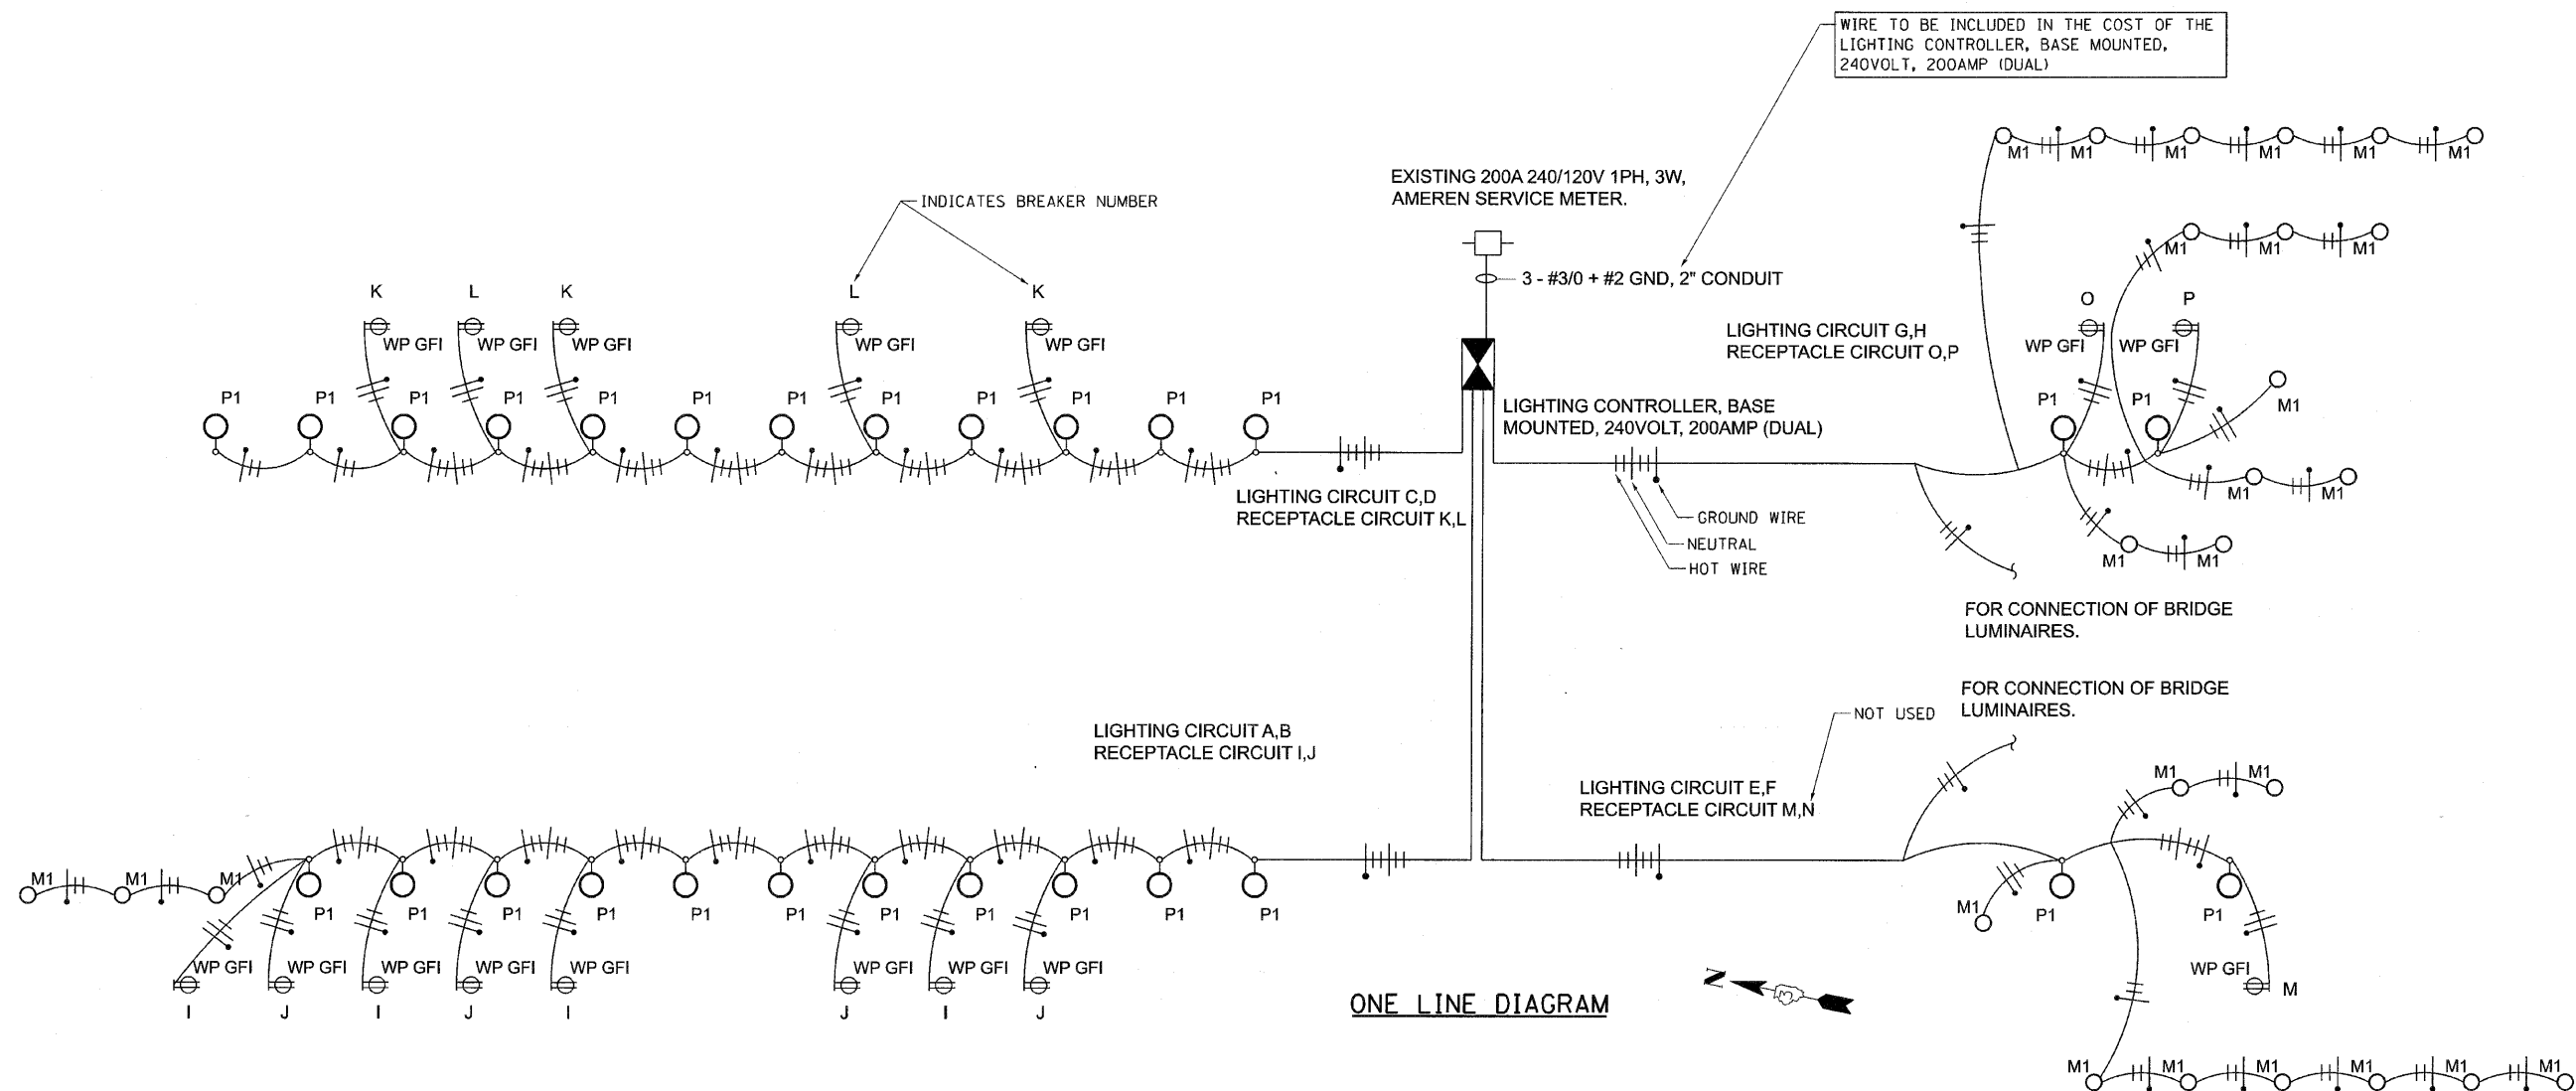

**ONE LINE DIAGRAM**

.\0366547-MOTIF\01.DGN .\0366547-BORDER\01.DGN .\0366547-LIGHT\01.DGN .\0366547-SHEET\01.DGN .\0366547-SHEET\02.DGN .\0366547-SHEET\03.DGN .\0366547-SHEET\100.DGN

FILE NAME = #FILEL#	USER NAME = #USER#	DESIGNED - JM	REVISED -	<b>STATE OF ILLINOIS</b> <b>DEPARTMENT OF TRANSPORTATION</b>	<b>SIDEWALK AND LANDSCAPE LIGHTING PLANS</b>		F.A.S. RTE. 1279	SECTION 6R,B	COUNTY LA SALLE	TOTAL SHEETS 190	SHEET NO. 100	
PLOT SCALE = #SCALE#		DRAWN - JB	REVISED -		SCALE: N/A	SHEET NO. OF SHEETS STA. TO STA.	FED. ROAD DIST. NO.	ILLINOIS FED. AID PROJECT	CONTRACT NO. 66547			
PLOT DATE = 9-13-2010		CHECKED - RS	REVISED -									
		DATE - 08/10	REVISED -									