



STATE OF ILLINOIS
DEPARTMENT OF TRANSPORTATION

* Order $d(E)$, $a_1(E)$, $c_1(E)$, & $c_2(E)$ bars full length. Cut to fit skew and use remainder of bars in opposite end.

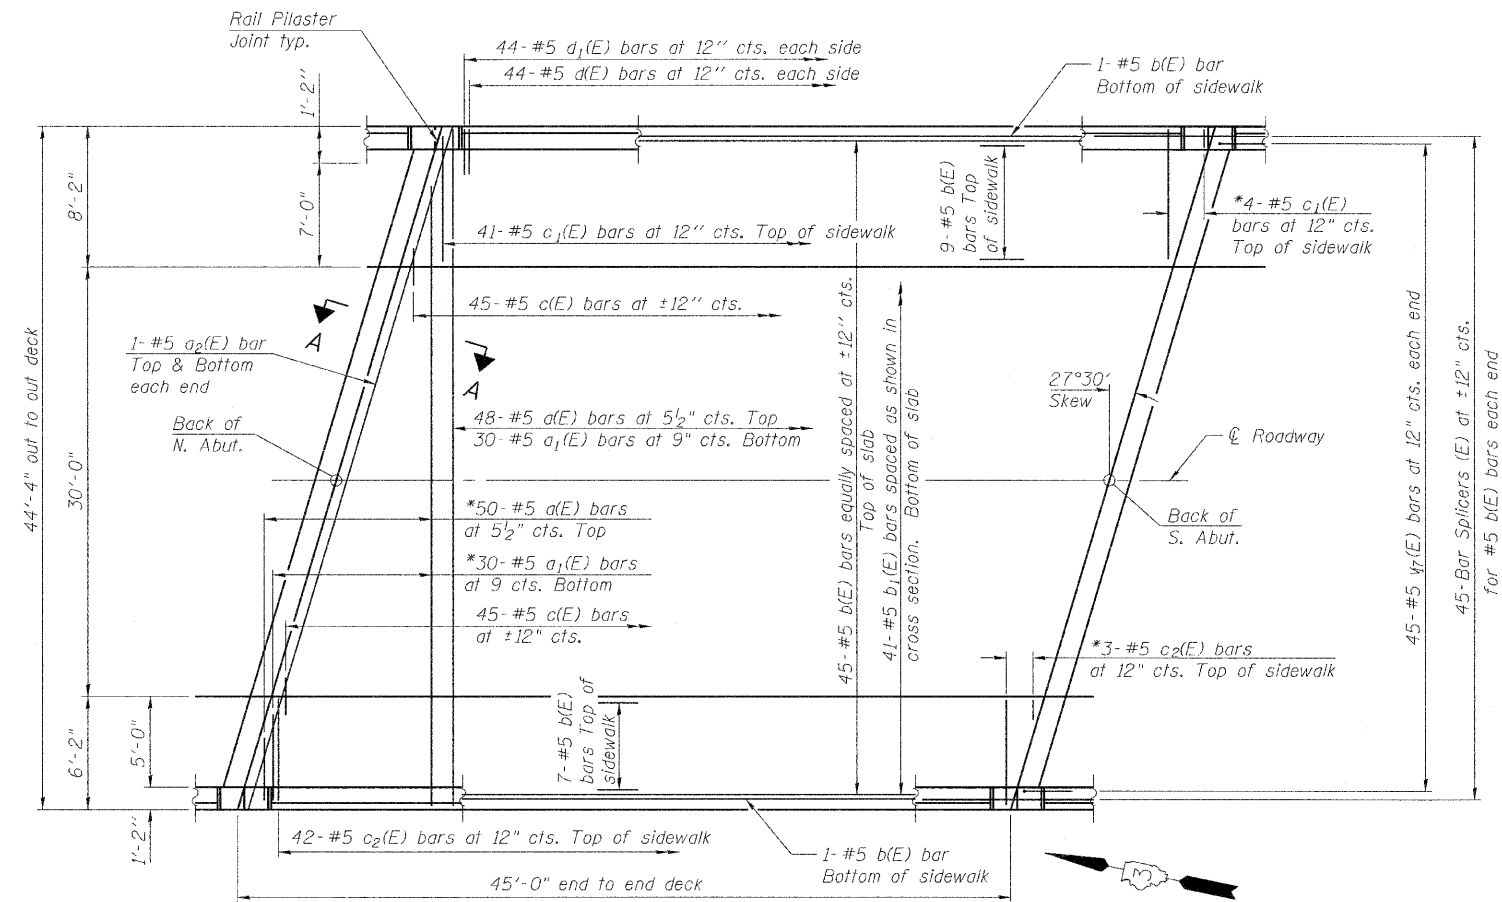

Notes:
See sheets 8 and 9 of 20 for superstructure details and Bill of Material.
See sheets 8 and 9 of 20 for rail reinforcement.
See sheet 18 of 20 for Bar Splicer Details.
See sheet 9 of 20 for Section A-A.
Conduit shown is provided and installed by the Contractor. Coordinate location and termini with the installer of the lighting. See lighting plans for additional details.

PLAN

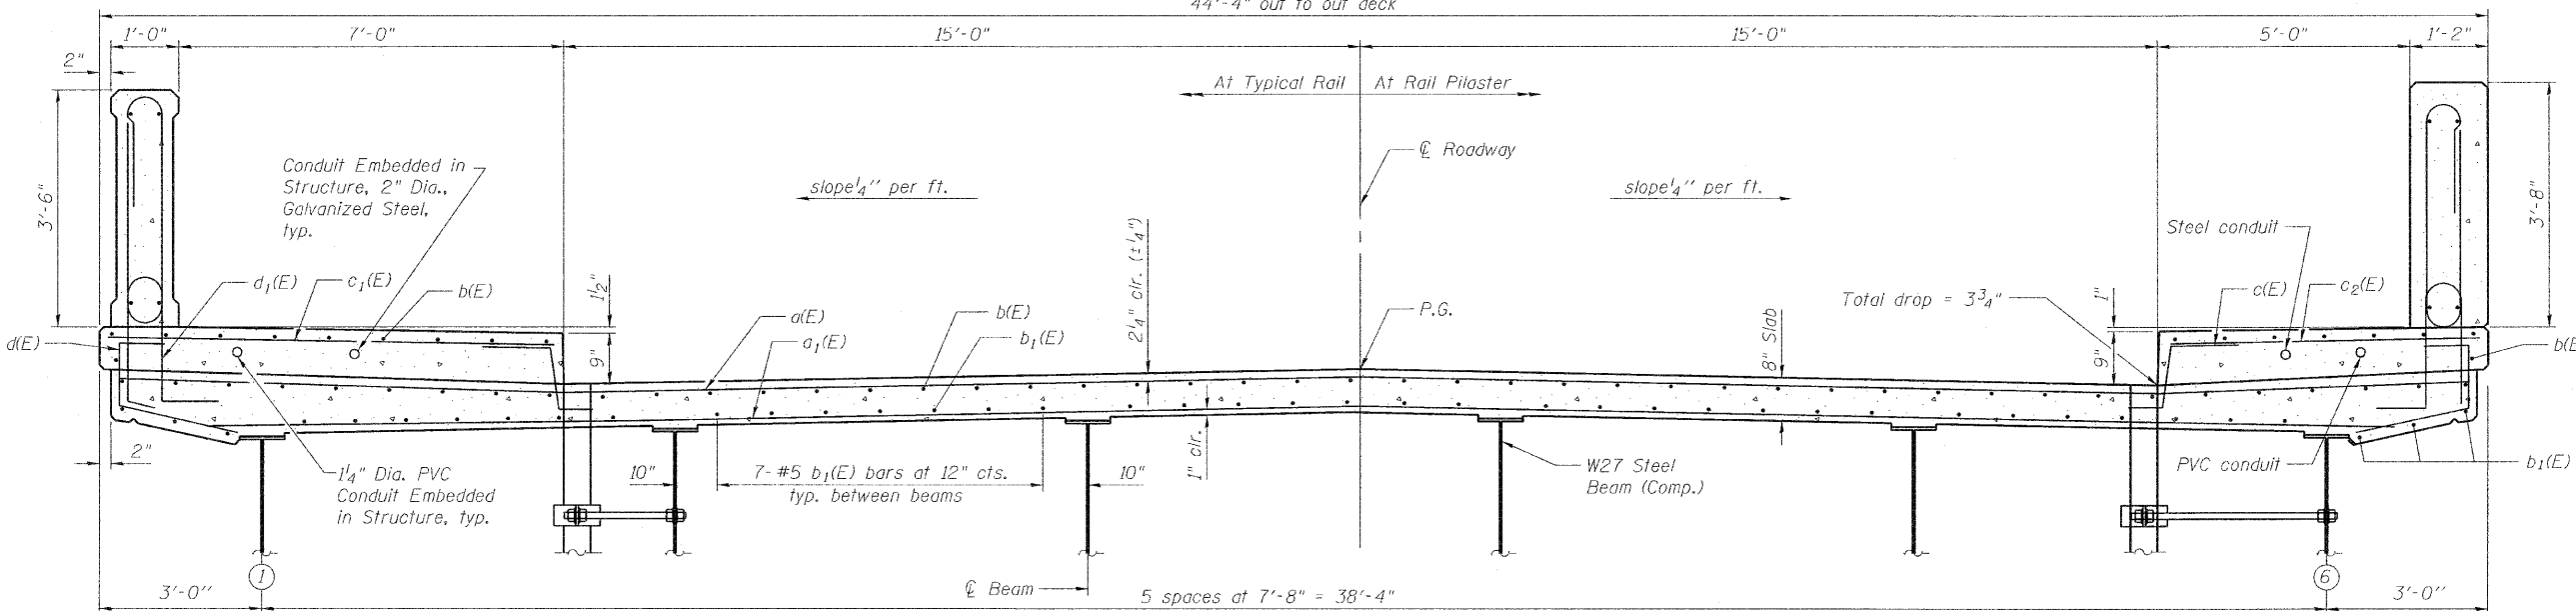

CROSS SECTION
(Looking South)

SUPERSTRUCTURE
STRUCTURE NO. 050-0250

DESIGNED	CMF
CHECKED	TMM
DRAWN	RNH
CHECKED	TMM

McDonough-Whitlow, P.C.
Consulting Engineers & Land Surveyors
138 East Wood Street
Hillsboro, IL 62049
Phone: 217.532.9233
Fax: 217.532.6300
PROFESSIONAL DESIGN No. 184-002754

SHEET NO. 7 20 SHEETS	F.A.S. RTE.	SECTION	COUNTY	TOTAL SHEETS	SHEET NO.
	1279	6R, B	LASALLE	190	109
FED. ROAD DIST. NO. ILLINOIS			CONTRACT NO. 66547		
FED. AID PROJECT					