
 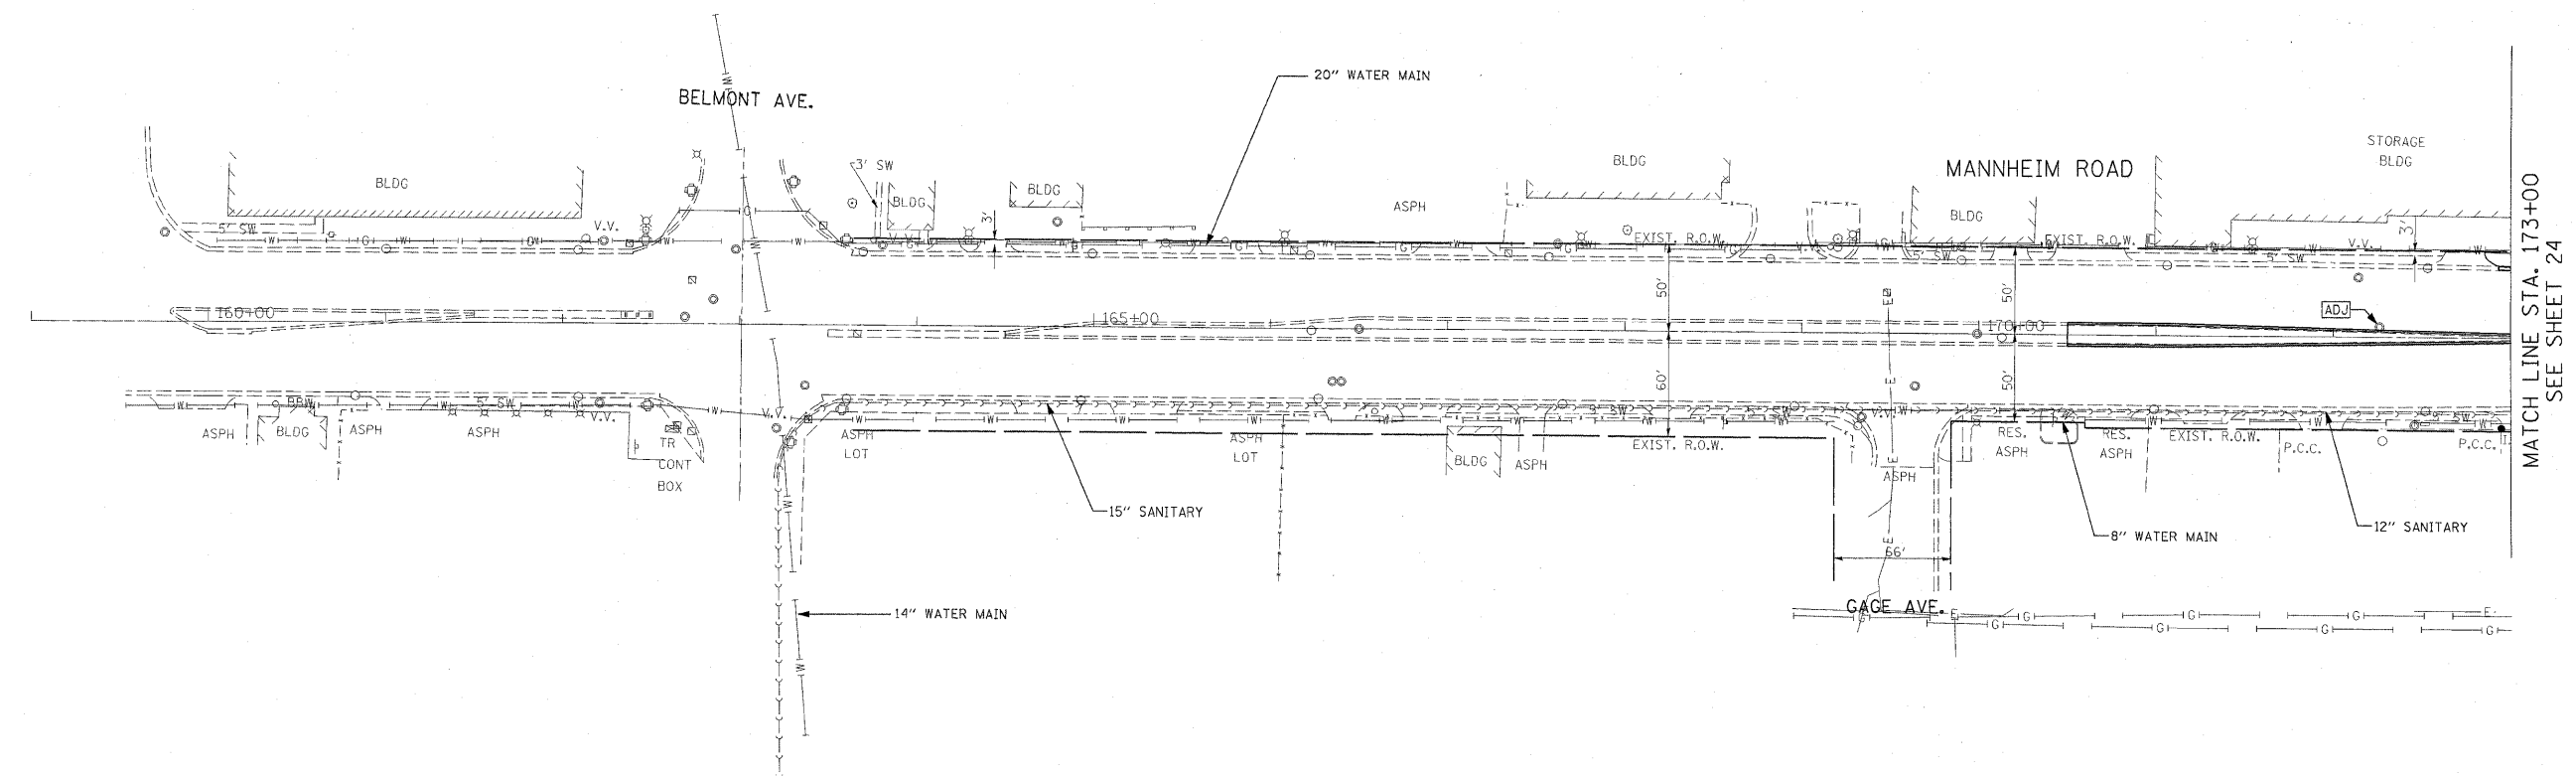



F.A.P. RTE.	SECTION	COUNTY	TOTAL SHEETS	SHEET NO.
330	465 VB-R-1	COOK	103	23
STA.		TO STA.		
FED. ROAD DIST. NO. 1		ILLINOIS	FED. AID PROJECT	
CONTRACT NO. 60407				



MATCH LINE STA. 173+00
SEE SHEET 24

L:\WORK\53346\cadd\drawings\Roadway\23d-ut.mxd
10/6/2009

 UT-01



EARTHTECH | AECOM

REVISIONS	
NAME	DATE
SUE INFORMATION	10/6/09

ILLINOIS DEPARTMENT OF TRANSPORTATION
 FAP 330 US 12/45 (MANNHEIM RD.) OVER
 500 LINE RR & FRANKLIN AVE.
DRAINAGE AND UTILITY PLAN
 STA. 159+00 TO STA. 173+00
 SCALE: 1"=50'
 DATE: JULY 8, 2009
 DRAWN BY: CJO
 CHECKED BY: PWK