
 


F.A.P. RTE.	SECTION	COUNTY	TOTAL SHEETS	SHEET NO.
330	465 VB-R-1	COOK	103	25
STA.		TO STA.		
FED. ROAD DIST. NO. 1		ILLINOIS	FED. AID PROJECT	
CONTRACT NO. 60407				

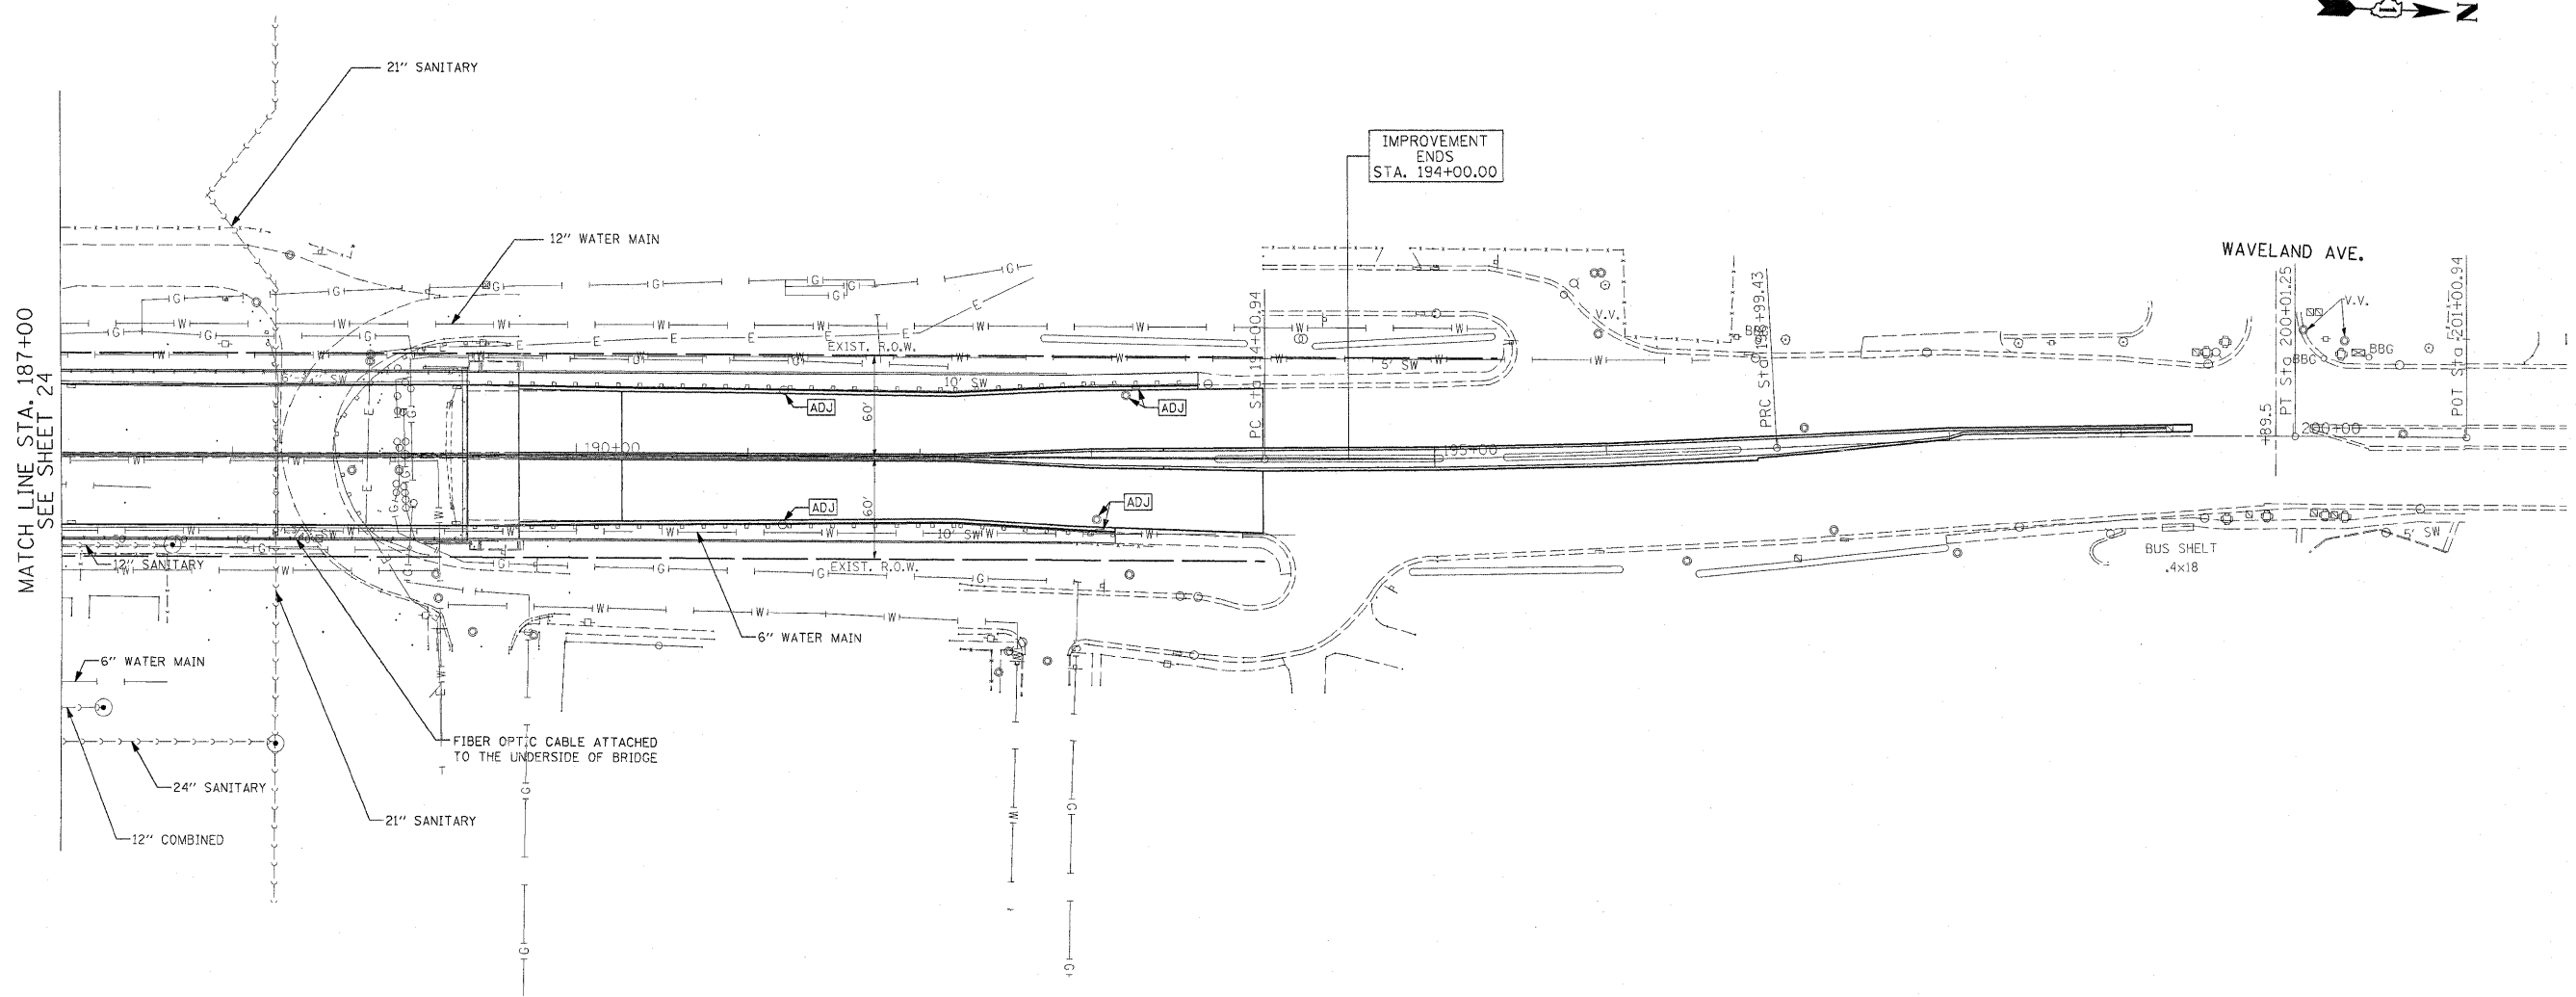

MATCH LINE STA. 187+00
SEE SHEET 24



Rev. Sheet 10-13-09 SCALE: 1"=50'



REVISIONS	
NAME	DATE
SUE INFORMATION	10/6/09

ILLINOIS DEPARTMENT OF TRANSPORTATION
FAP 330 US 12/45 (MANNHEIM RD.) OVER
S00 LINE RR & FRANKLIN AVE.
DRAINAGE AND UTILITY PLAN
STA. 187+00 TO STA. 201+00.94
SCALE: 1"=50'
DATE: JULY 8, 2009
DRAWN BY: CJO
CHECKED BY: PWK

UT-03

L:\WORK\53346\cadd\drawings\Roadway\25drain.dgn
10/6/2009