



F.A.P. RTE.	SECTION	COUNTY	TOTAL SHEETS	SHEET NO.
332/876	2002-113R	WILL	242	114
STA. 60+975		TO STA. 61+325		
FED. ROAD DIST. NO. 1		ILLINOIS FED. AID PROJECT		

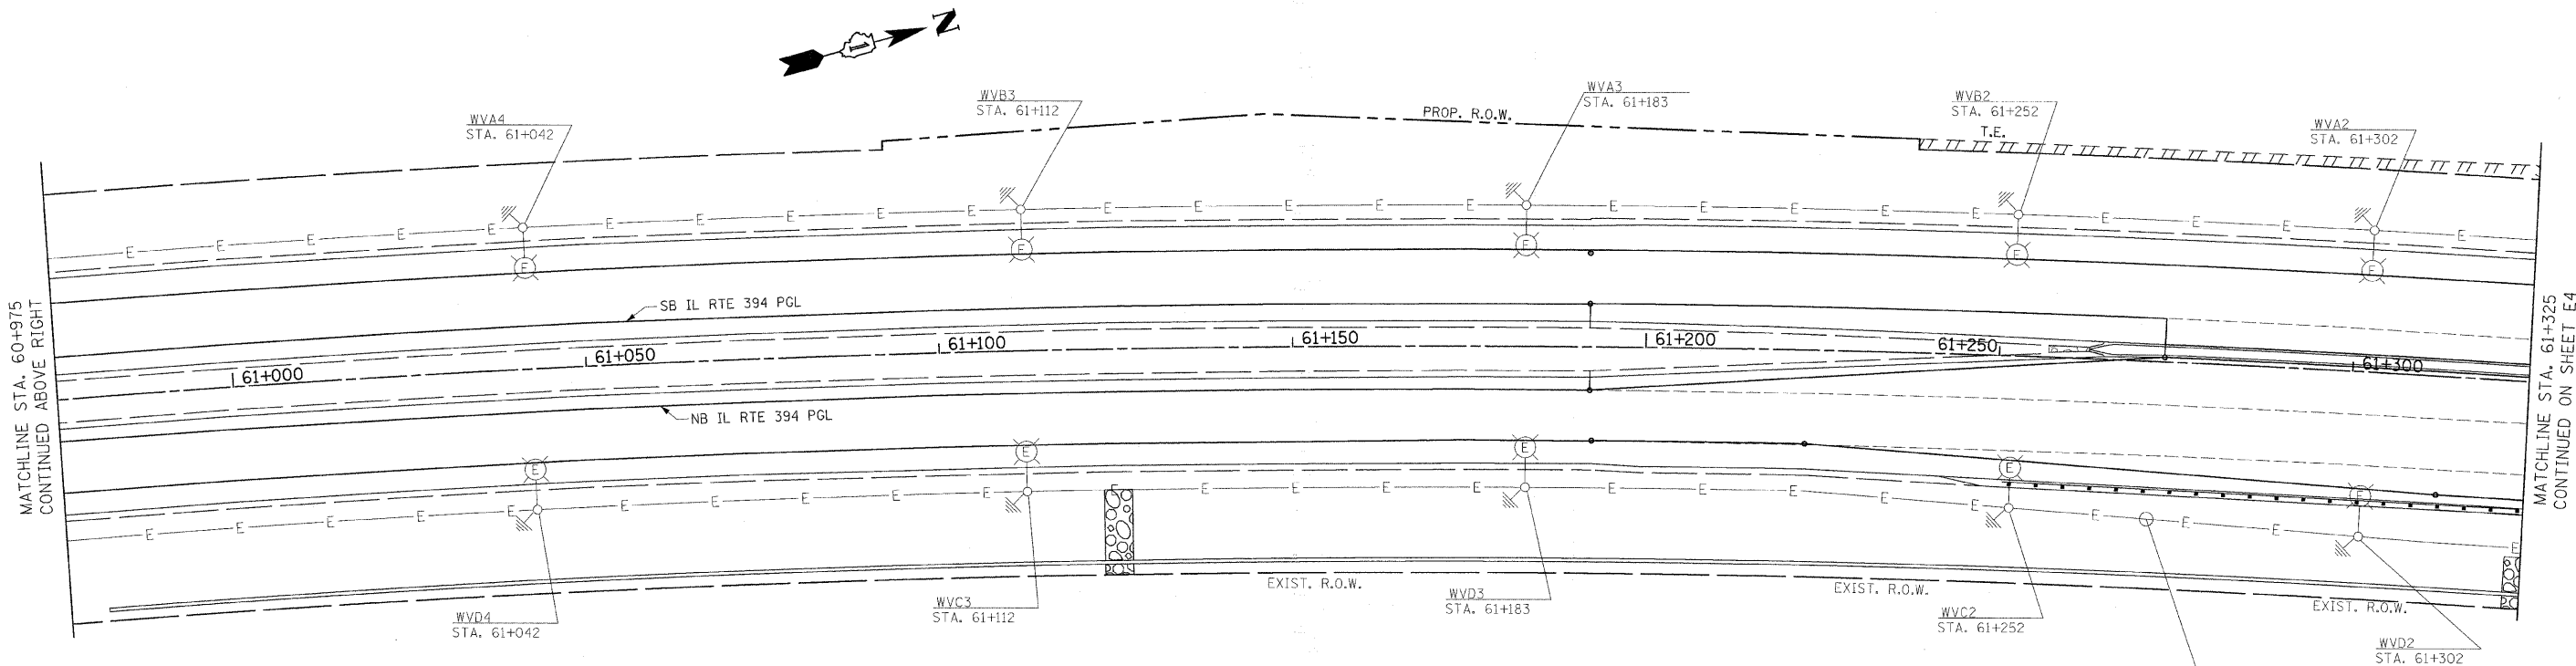

UNIT DUCT (EXISTING), 3-1/2 No. 2, 1-1/2 No. 4 GROUND 600V (EPR-TYPE RHW), 1-1/2" DIA. SCHEDULE 40 POLYETHYLENE (TYPICAL).

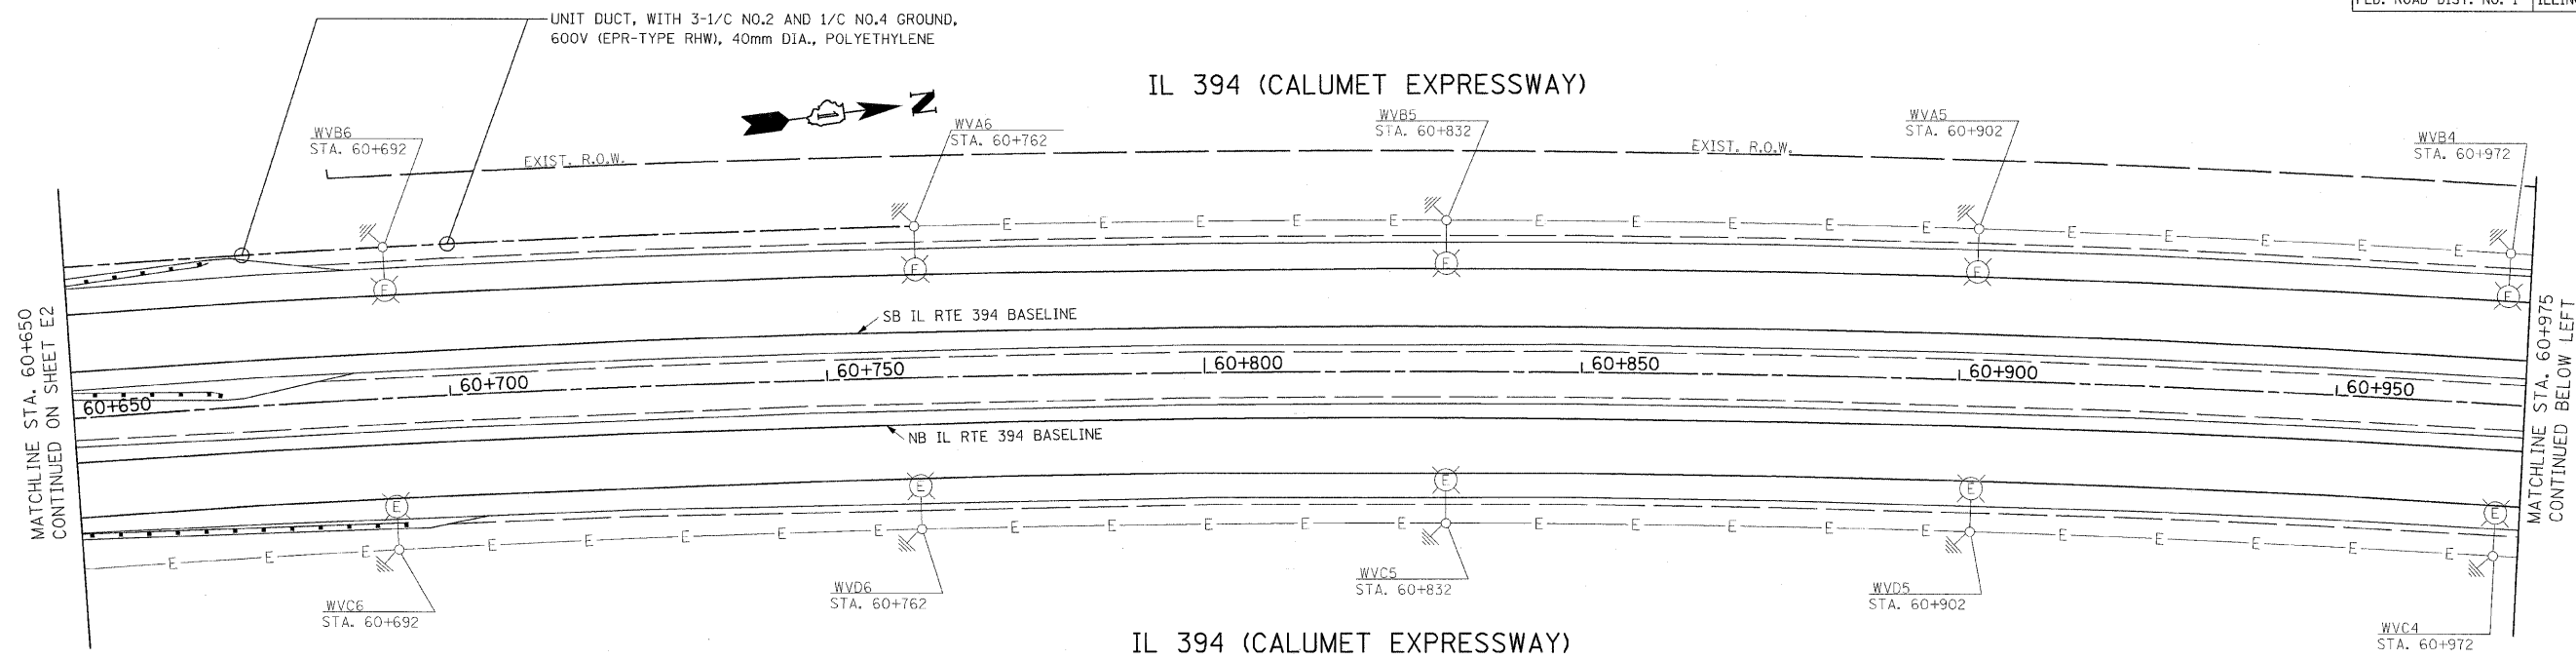

Peter B. Leonard 7/1/09
Exp. 11/30/09

HOH ASSOCIATES, INC.
55 West Jackson Blvd.
Chicago, Illinois 60604
312/348-8131

PROJECT NUMBER: 2660.05
HOH CAD FILE No. E3.DGN
PLOT SCALE 1 = 1

REVISIONS	
NAME	DATE

ILLINOIS DEPARTMENT OF TRANSPORTATION
IL. RTE. 394 AT IL. 1
PROPOSED
LIGHTING PLAN

SCALE 1:500
DATE 11-18-2005

DRAWN BY MEK
CHECKED BY RER

E3