



F.A.P. RTE.	SECTION	COUNTY	TOTAL SHEETS	SHEET NO.
332/876	2002-113R	WILL	242	121
STA. 60+295		TO STA. 60+675		
FED. ROAD DIST. NO. 1		ILLINOIS FED. AID PROJECT		

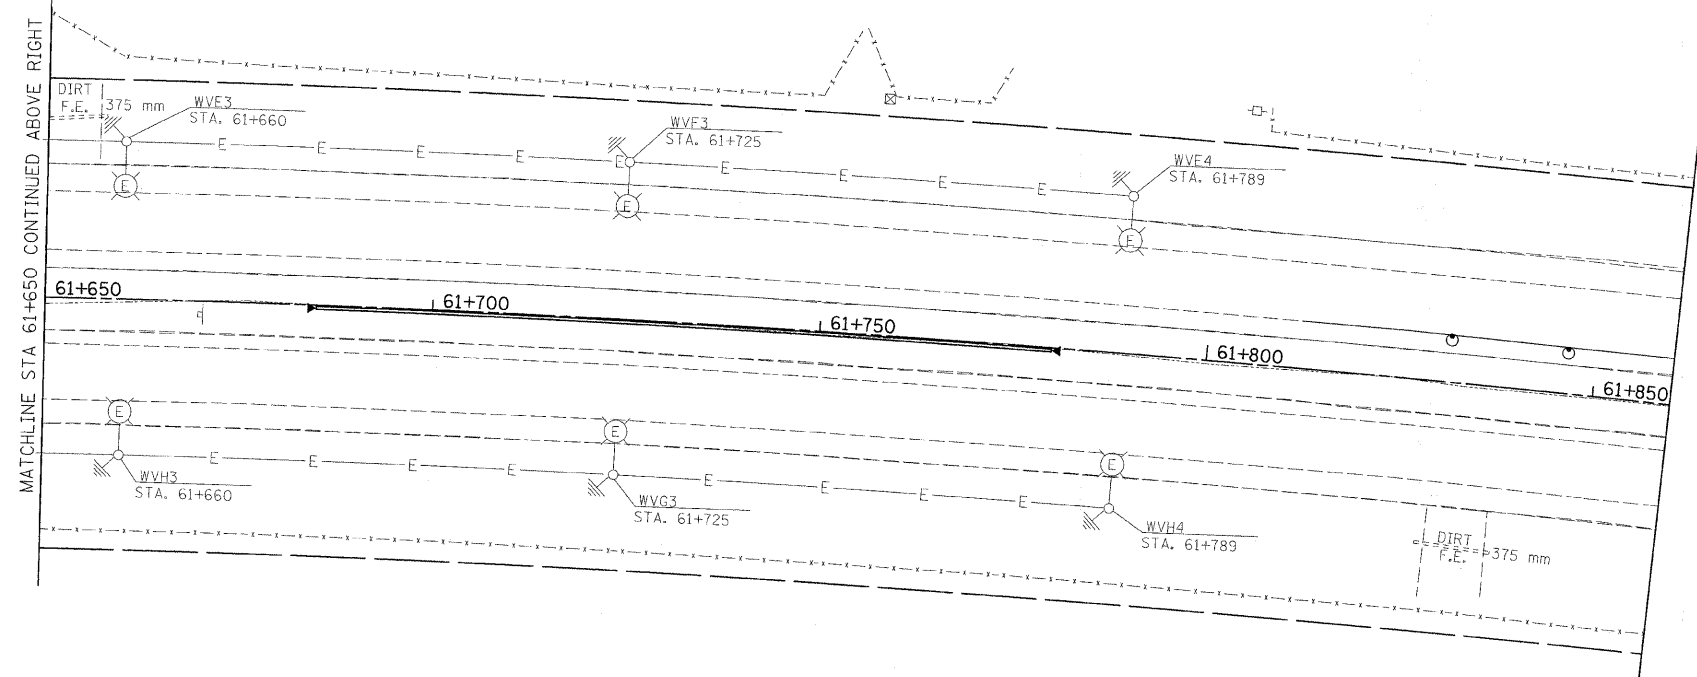

- NOTES:**
1. REFERENCE DRAWINGS E3 AND E4 FOR PROPOSED LIGHTING PLAN.
 2. FOUR (4) EXISTING INTERSECTION POLES AND FOUR (4) EXISTING HELIX LIGHTING FOUNDATIONS SHALL BE REMOVED AND SALVAGED, THE COST OF WHICH SHALL BE INCLUDED UNDER THE PAY ITEM, "REMOVAL OF EXISTING LIGHTING UNIT, SALVAGE."

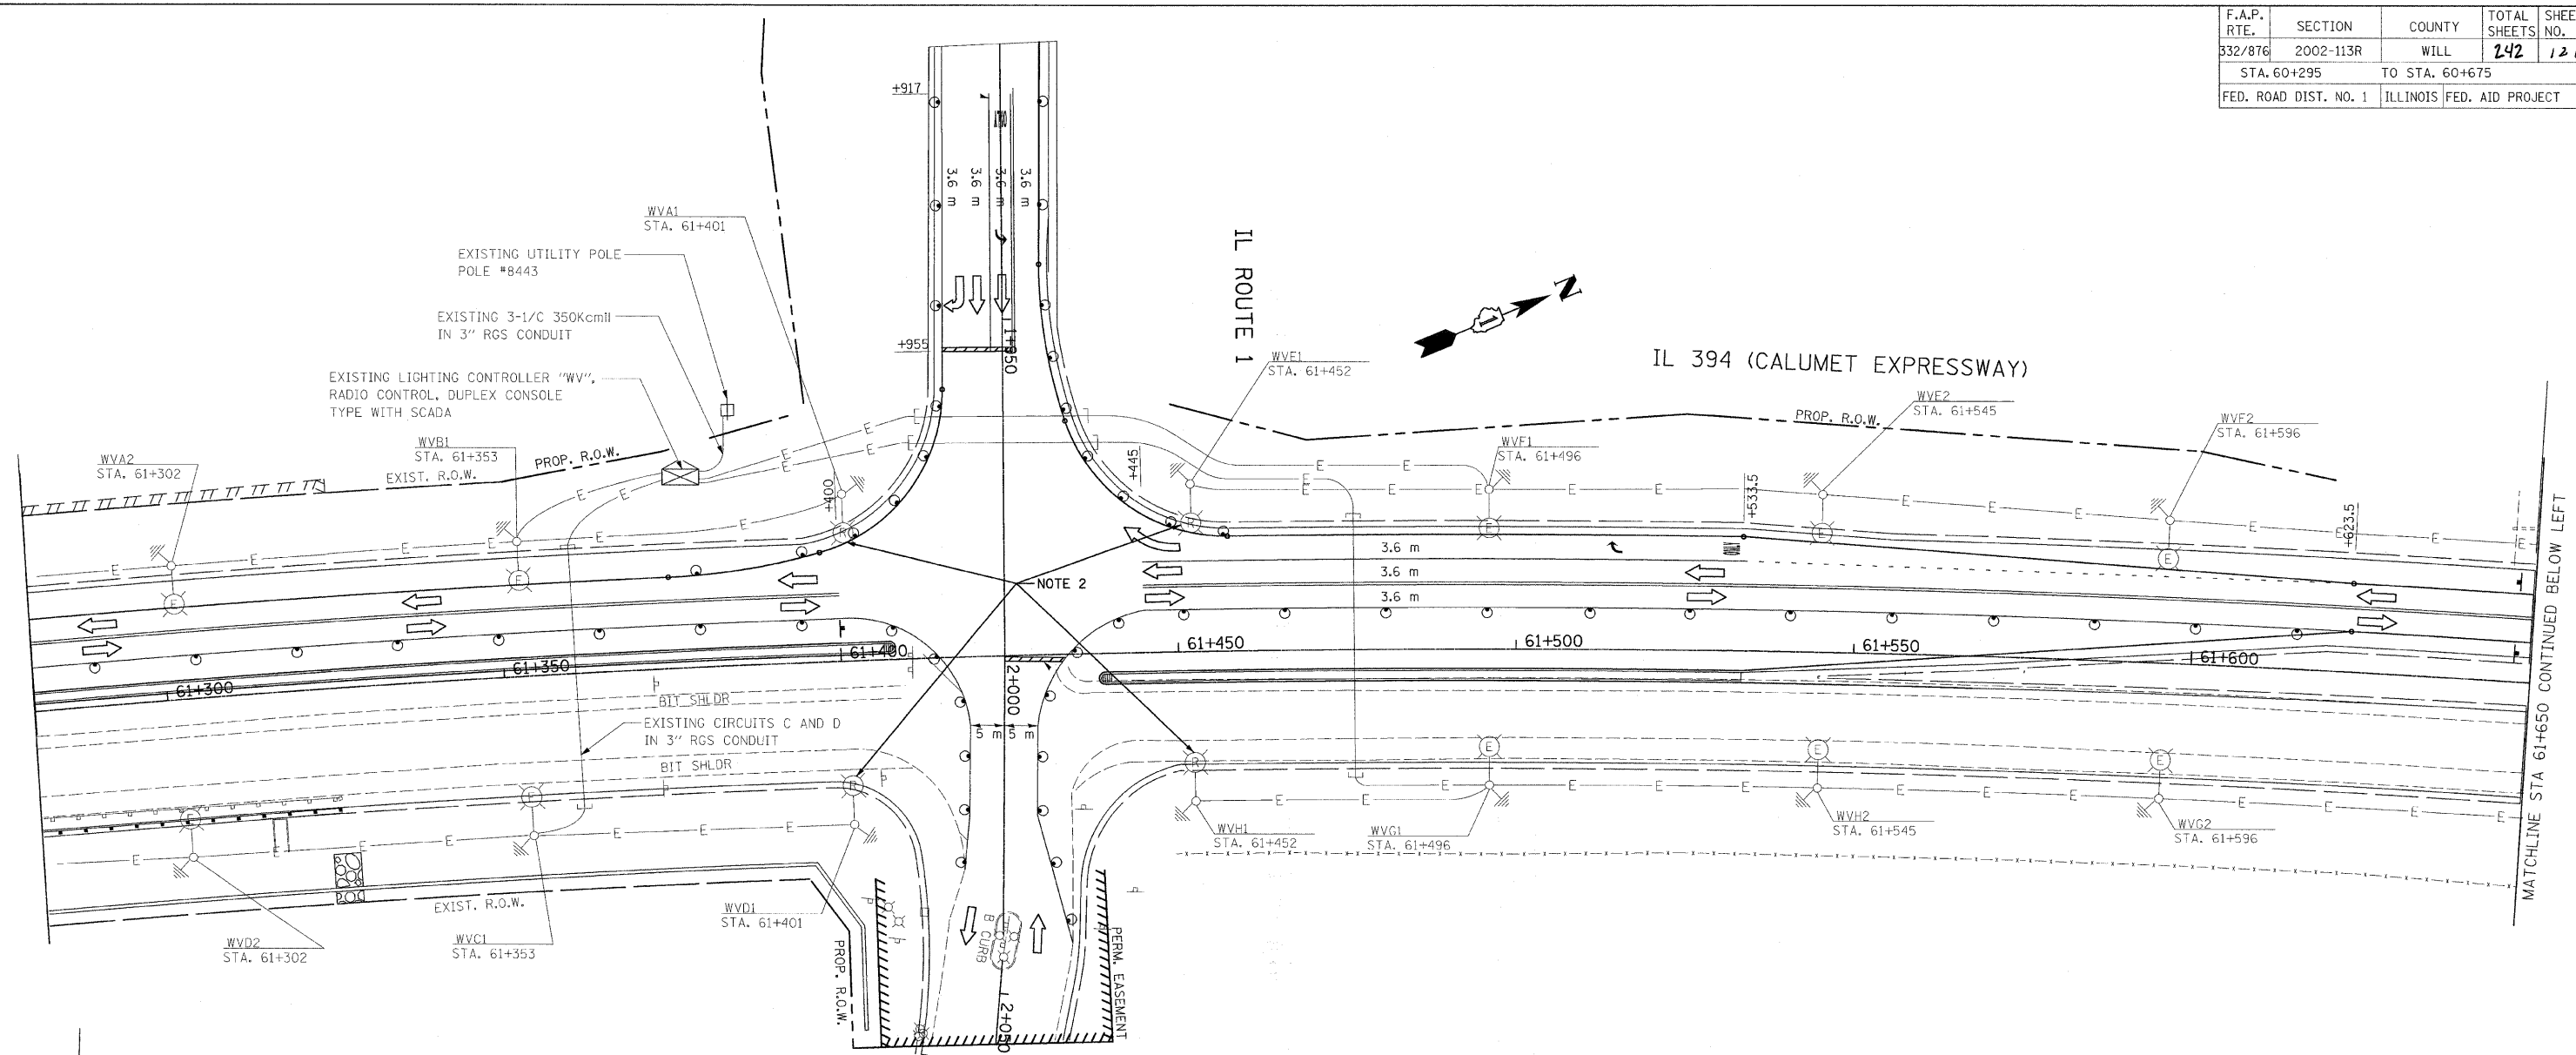

Peter B. Leonard 7/9/09
Exp. 11/30/109

HOH ASSOCIATES, INC.
 55 West Jackson Blvd.
 Chicago, Illinois 60604
 312/546-8131
 PROJECT NUMBER: 2660.05
 HOH CAD FILE No.: E10.DGN
 PLOT SCALE: 1 = 1

REVISIONS	
NAME	DATE

ILLINOIS DEPARTMENT OF TRANSPORTATION
 IL. RTE. 394 AT IL. 1
 STAGE 3
 LIGHTING PLAN
 SCALE 1:500
 DATE 12-6-2005
 DRAWN BY MEK
 CHECKED BY RER

E10