



F.A. RTE.	SECTION	COUNTY	TOTAL SHEETS	SHEET NO.
392/076	1002-113R	WILL	242	133
STA.		TO STA.		
FED. ROAD DIST. NO.		ILLINOIS FED. AID PROJECT		

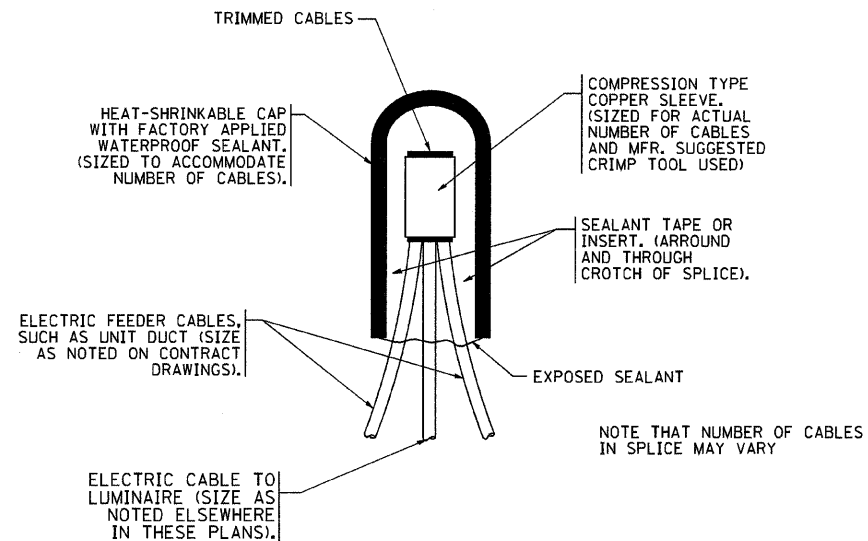


TYPICAL SPLICE DETAIL

N.T.S.

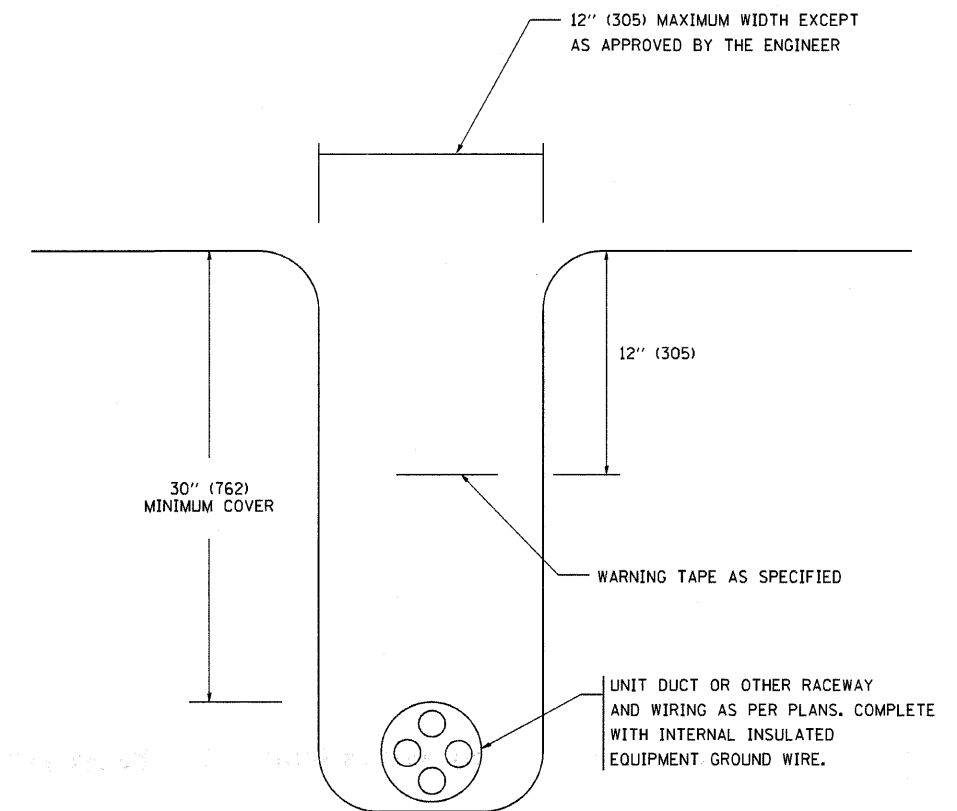

TYPICAL WIRING IN TRENCH DETAIL

N.T.S.

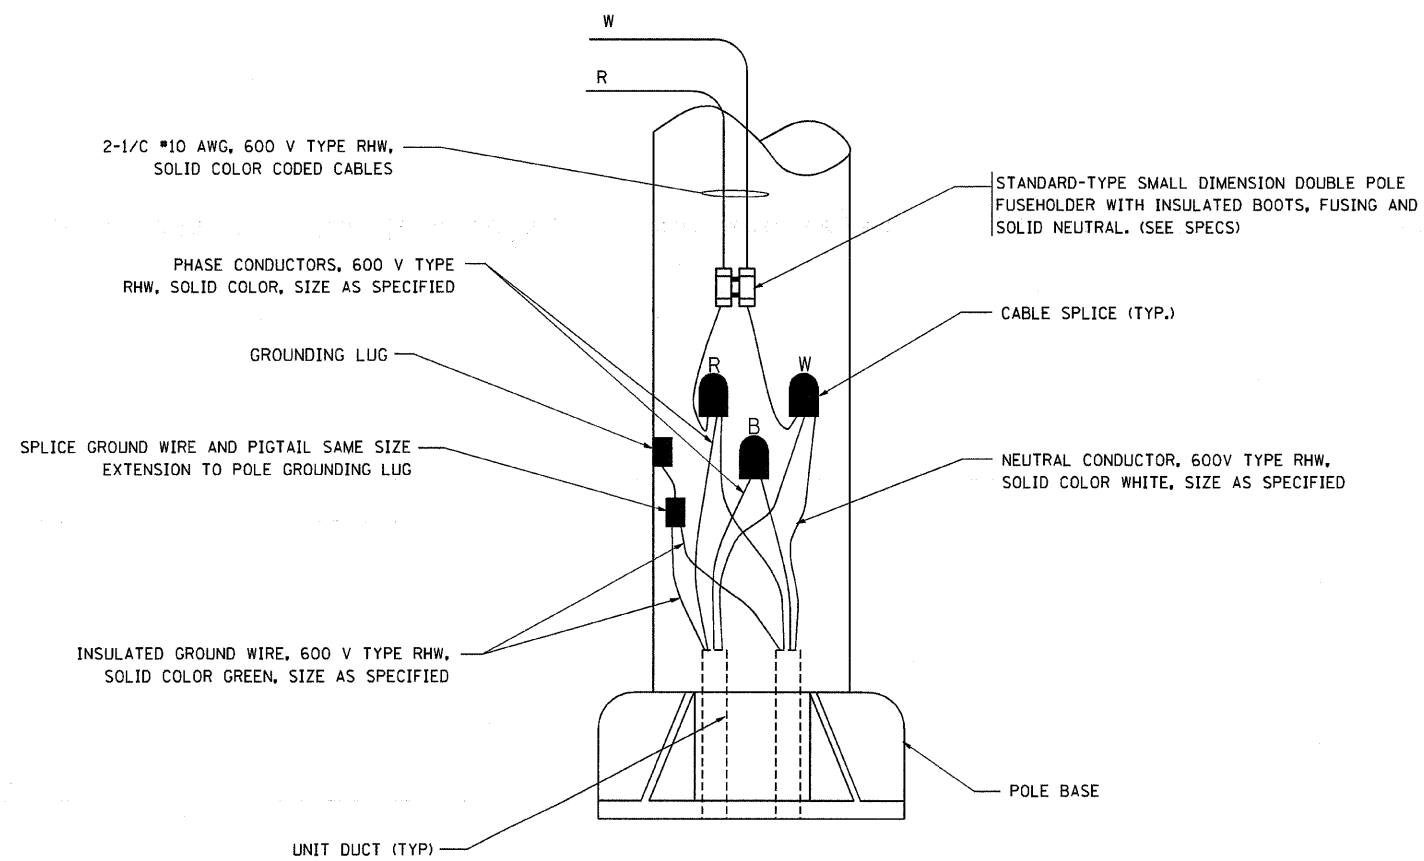

POLE WIRING DETAIL

N.T.S.

REVISIONS	
NAME	DATE
	08/08/03

ILLINOIS DEPARTMENT OF TRANSPORTATION

MISC. ELECTRICAL DETAILS SHEET A

SCALE: VERT. NONE  
HORIZ.

DRAWN BY  
CHECKED BY  
BE-702