


F.A.P. R.T.E.	SECTION	COUNTY	TOTAL SHEETS	SHEET NO.
	06-00199-00-LS	COOK	19	3
<b>E1: SITE PLAN</b>				
ILLINOIS 63041				

**GENERAL ELECTRICAL NOTES:**

1. REFER TO SHEETS E6 THRU E10 FOR ONE LINE DIAGRAM, ONE LINE DIAGRAM NOTES, CONTROL DIAGRAM, BILL OF MATERIALS, CABINET ELEMENTARY DIAGRAM, AND LIGHTING CONTROL CABINET DETAIL.
2. REFER TO SHEET E11 FOR LUMINAIRE SCHEDULE, LIGHTING NOTES, CONTROLLER ELECTRICAL NOTES.
3. REFER TO SHEET E11 FOR GENERAL INSTALLATION NOTES.

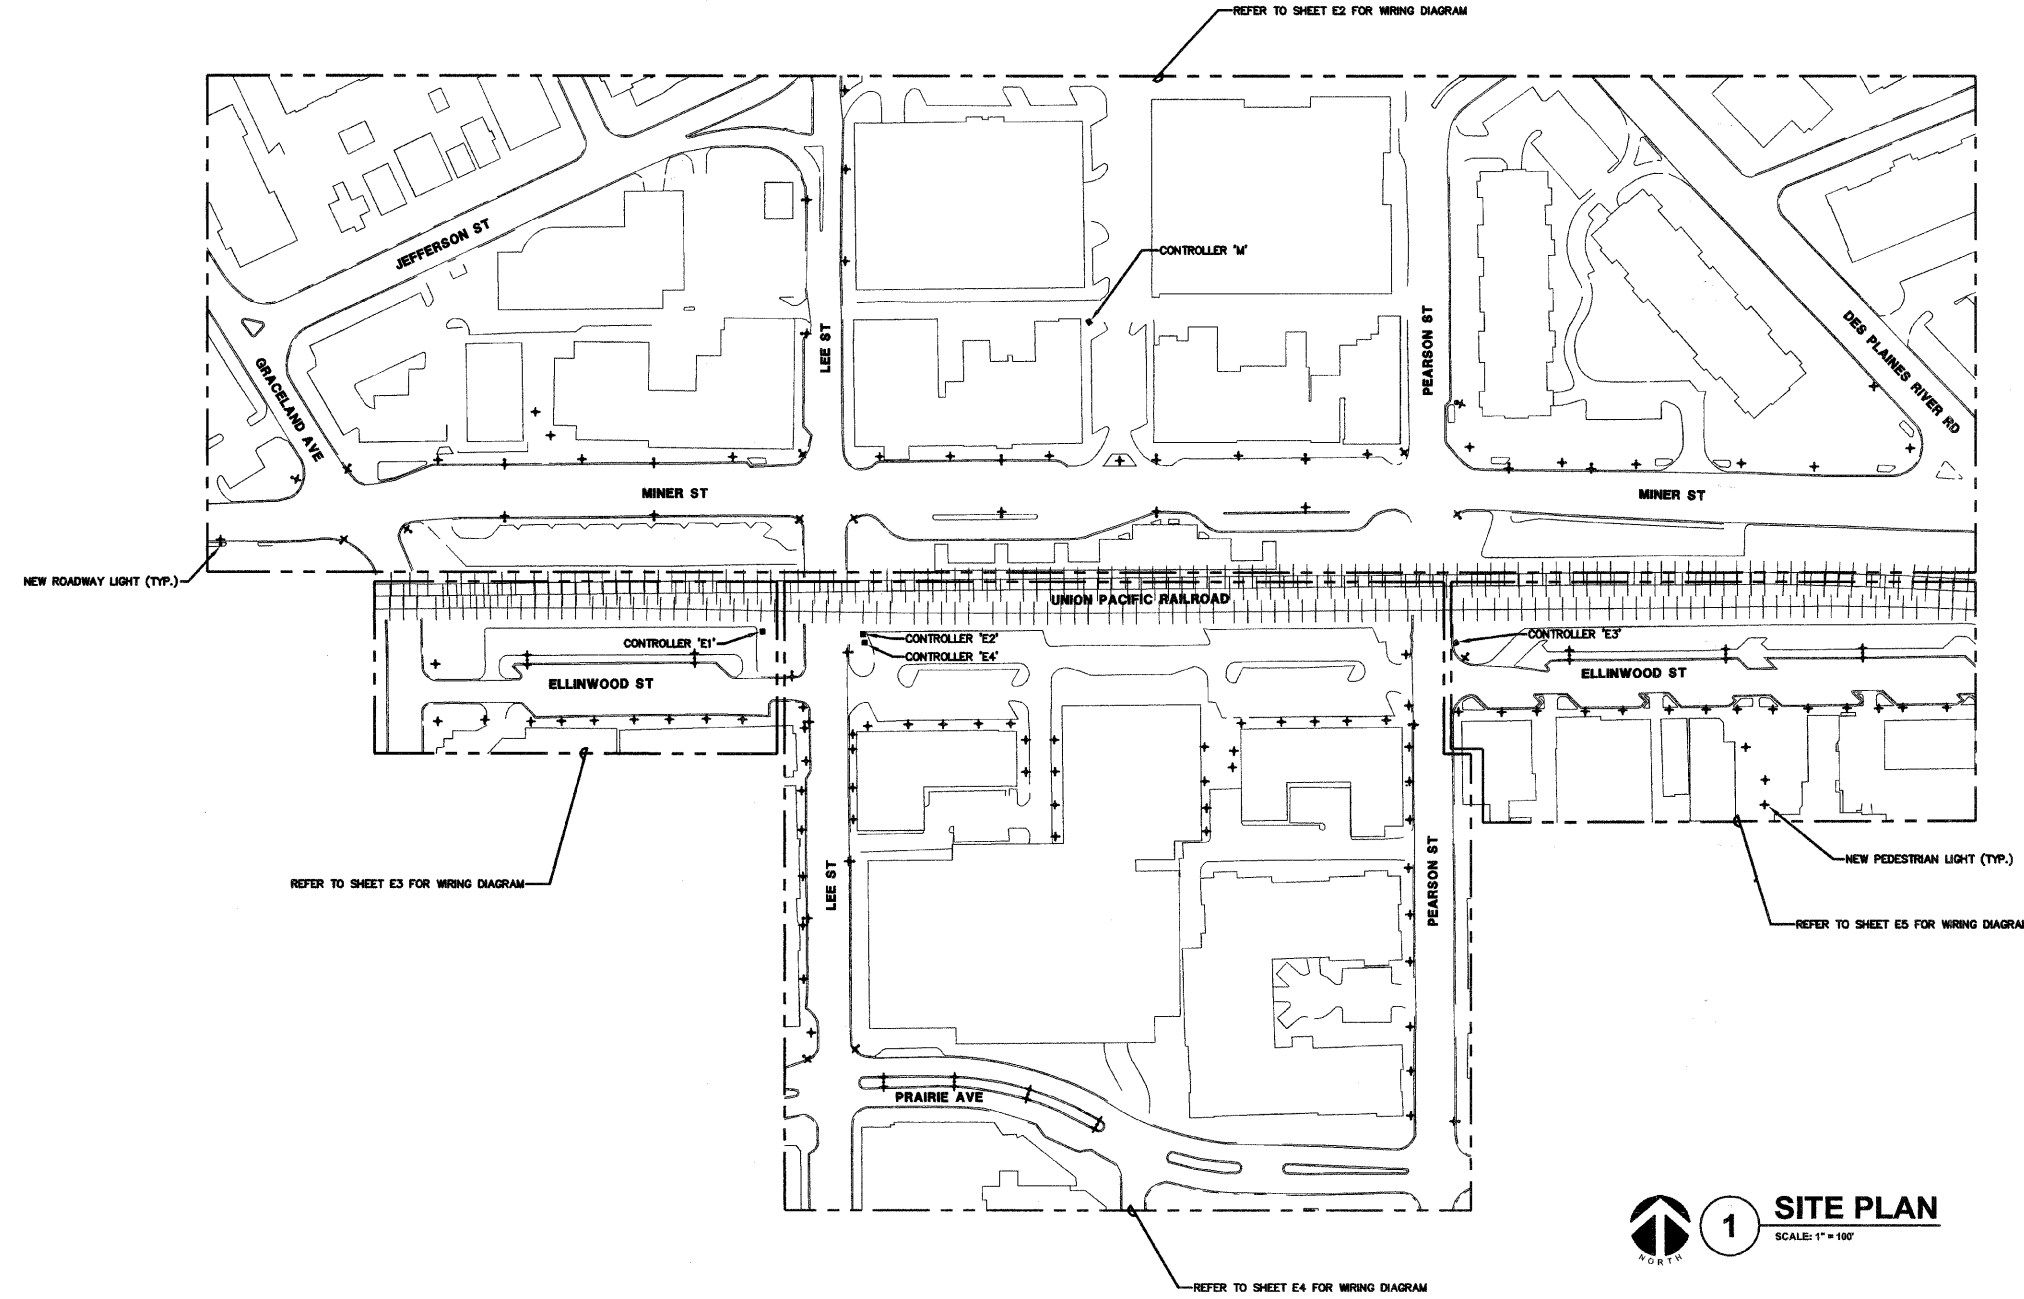

**1 SITE PLAN**  
SCALE: 1" = 100'

CONTRACTOR NOTE: LOCATION AND TYPE OF LANDSCAPING IMPROVEMENTS ARE SPECIFIED IN CONTRACT SPECIFICATIONS.

THERE ARE NO LIGHTING IMPROVEMENTS ON OAKTON STREET.

**K J ENGINEERING CONSULTANTS**  
1771 W. DIEHL ROAD, SUITE 300  
NAPERVILLE, IL 60563  
630.527.2320 FAX: 630.527.2321  
www.kjw.com  
PROJECT #07.0610.00

KJW ENGINEERING RESERVES PROPRIETARY RIGHTS, INCLUDING COPYRIGHTS, TO THIS DRAWING AND THE DATA SHOWN THEREON. SAID DRAWING AND/OR DATA ARE THE EXCLUSIVE PROPERTY OF KJW ENGINEERING AND SHALL NOT BE USED OR REPRODUCED FOR ANY OTHER PROJECT WITHOUT THE EXPRESS WRITTEN APPROVAL AND PARTICIPATION OF KJW ENGINEERING. © 2007 KJW, P.C.

REFERENCE SCALE IN INCHES

PLANS PREPARED BY:  
**GEWALT HAMILTON ASSOCIATES, INC.**  
Consulting Engineers & Surveyors  
850 Forest Ridge Drive  
Vernon Hills, IL 60061  
(847) 476-9700  
(847) 476-9701 Fax

REVISIONS	
NAME	DATE

ILLINOIS DEPARTMENT OF TRANSPORTATION  
**E1: SITE PLAN**  
**DES PLAINES LIGHTING IMPROVEMENTS AND STREETScape DES PLAINES, ILLINOIS**

SCALE: 1"=100'  
DATE: 8-14-2009

DRAWN BY: JOP  
DESIGNED BY: MCK  
CHECKED BY: MCK