



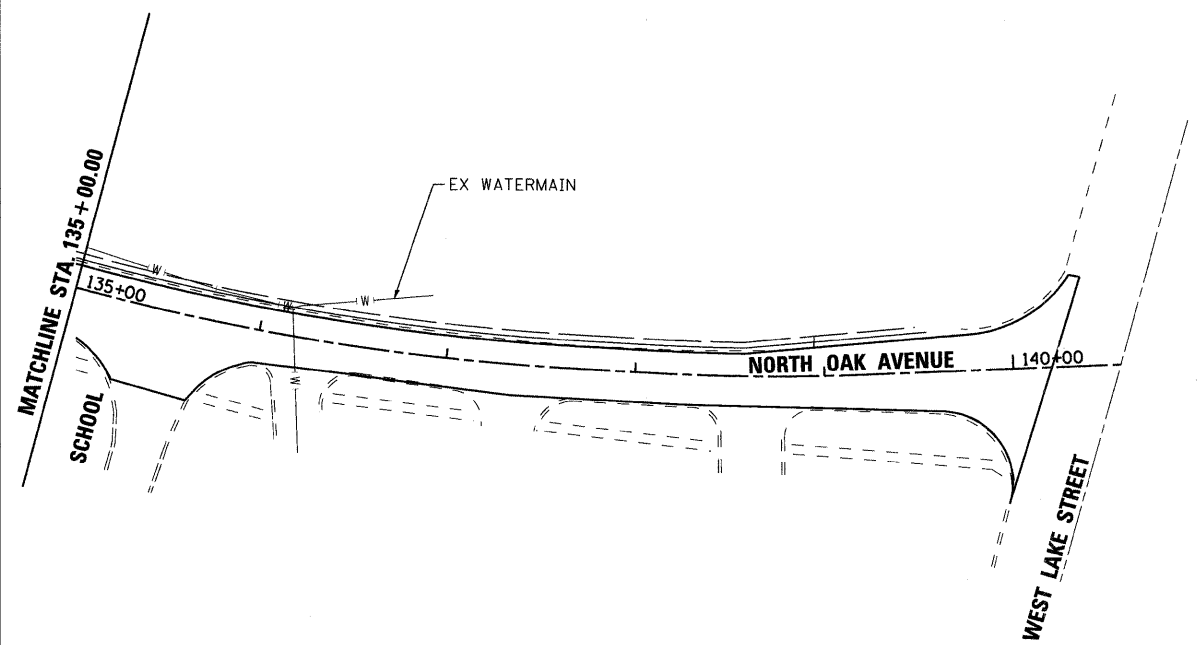

PLAN	SURVEYED	DATE
NOTE BOOK	ALIGNED	
NO.	RT. OF WAY CHECKED	
	ADD. FILE NAME	

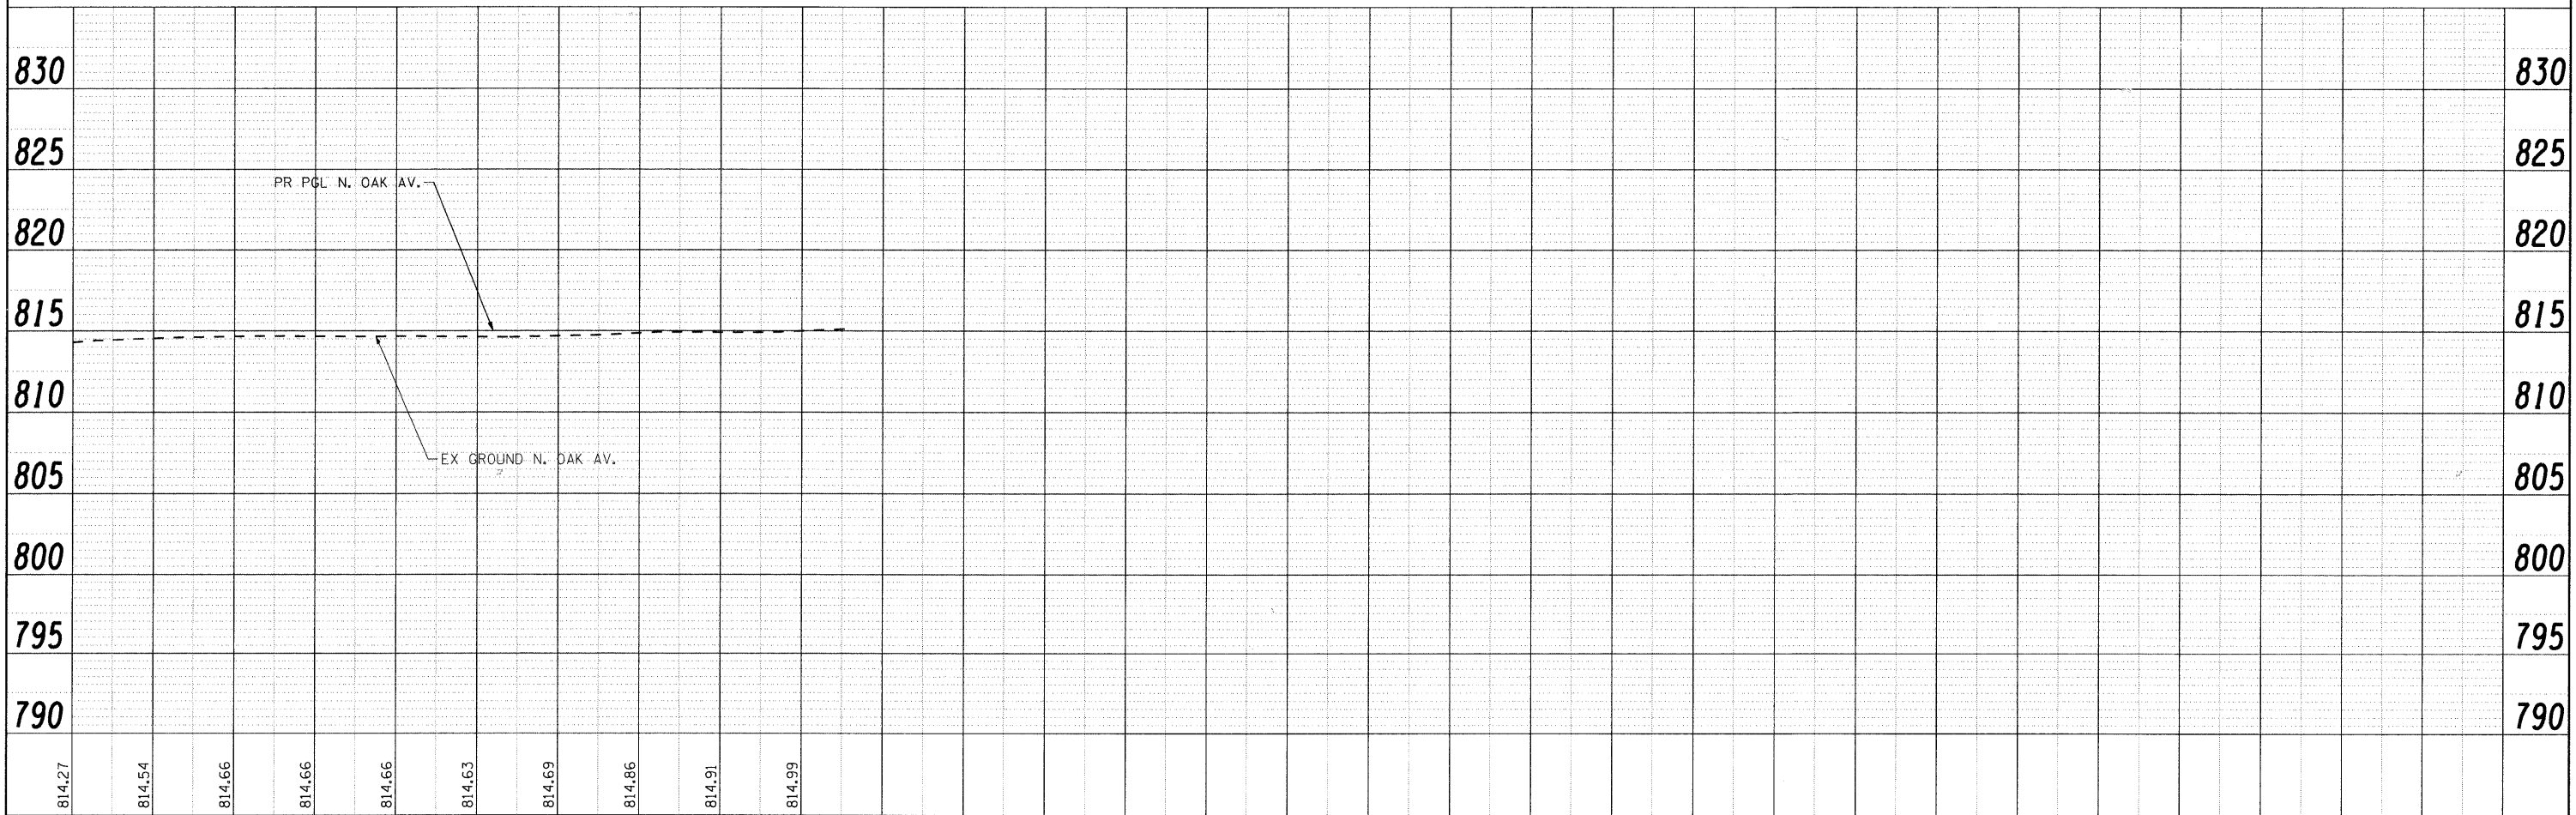

PROFILE	SURVEYED	DATE
NOTE BOOK	GRADES CHECKED	
NO.	B.M. NOTED	
	STRUCTURE NOTATIONS CIPRD	



SEC GROUP, INC.
 COMPANY NAME: J. MELHUSH
 PROJECT CONTACT: VILLAGE OF BARTLETT
 CLIENT: 8/31/2009 426235 PK
 DATE PLOTTED: 090196-drain-03.dgn
 FILE NAME: pot.dgn
 PLOT DRIVER: srtmardr-trans.tbl
 PEN TABLE: srtmardr-trans.tbl

SEC Group, Inc.
 Engineering
 Planning
 Landscape Architecture
 Mulberry • Yorkville • New Lenox • Chicago
 www.secgroupinc.com

USER NAME = jmelhush	DESIGNED - J. ATTANASEO	REVISED -
PLOT SCALE = 1" = 50'	DRAWN -	REVISED -
PLOT DATE = 8/31/2009	CHECKED - T. HAMILTON	REVISED -
	DATE - 8/3/09	REVISED -

**STATE OF ILLINOIS
 DEPARTMENT OF TRANSPORTATION**

**PROPOSED DRAINAGE PLAN
 NORTH OAK AVENUE RECONSTRUCTION**

SCALE: 1" = 50' SHEET NO. 3 OF 5 SHEETS STA. TO STA.

F.A. RTE.	SECTION	COUNTY	TOTAL SHEETS	SHEET NO.
2537	09-00084-00-RS	COOK	53	18
				CONTRACT NO. 63274
ILLINOIS FED. AID PROJECT ARA-9003 (345)				