


F.A.I. RTE.	SECTION	COUNTY	TOTAL SHEETS	SHEET NO.
55		MCLEAN	310	104
FED. ROAD DIST. NO.	ILLINOIS	FED. AID PROJECT		
• (57-4)R, HBY, HBR, (57-4VB)DM CONTRACT #70757				

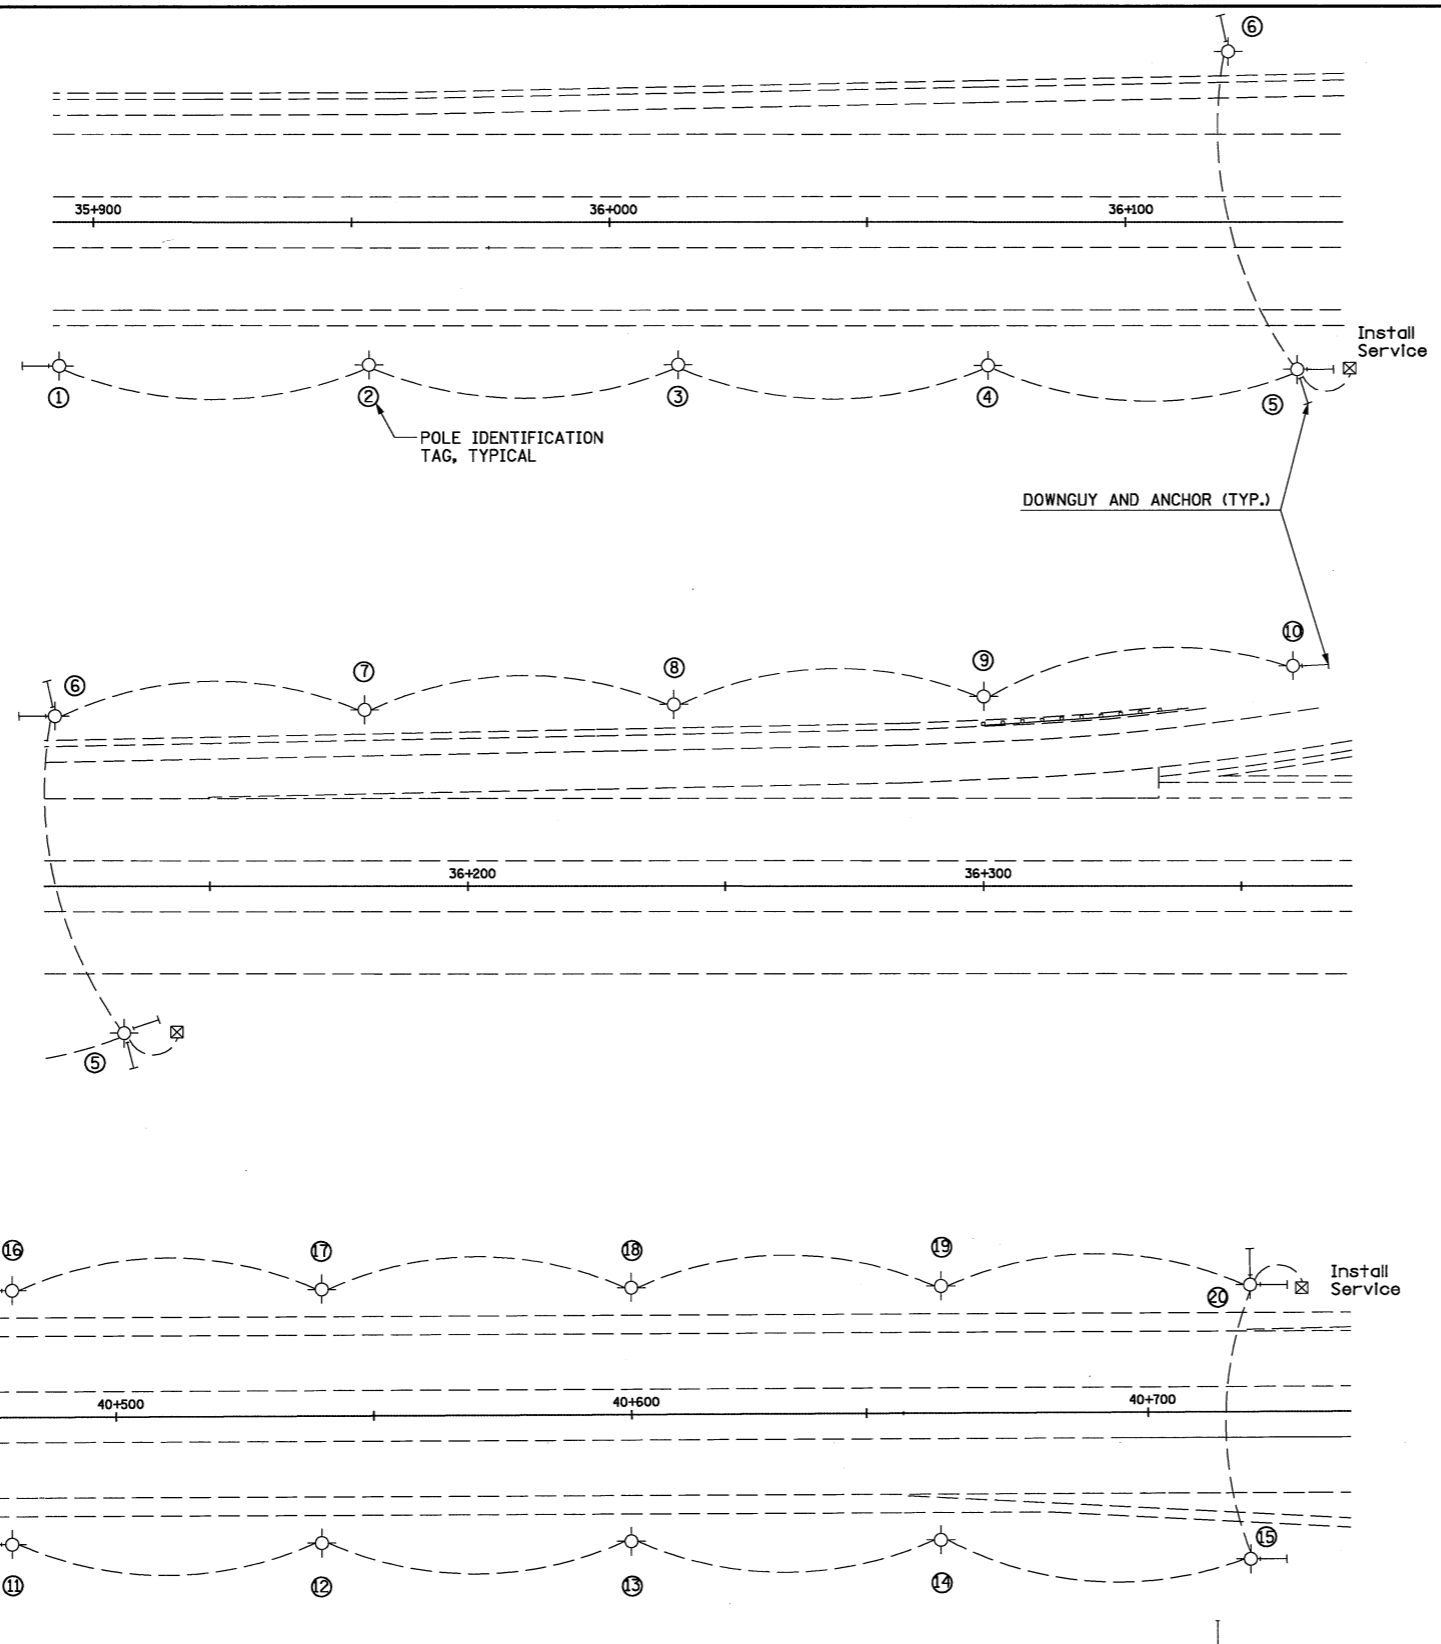

- ① STA. 35+890 RT.
- ② STA. 35+950 RT.
- ③ STA. 36+010 RT.
- ④ STA. 36+070 RT.
- ⑤ STA. 36+130 RT.
- ⑥ STA. 36+120 LT.
- ⑦ STA. 36+180 LT.
- ⑧ STA. 36+240 LT.
- ⑨ STA. 36+300 LT.
- ⑩ STA. 36+360 LT.
- ⑪ STA. 40+480 RT.
- ⑫ STA. 40+540 RT.
- ⑬ STA. 40+600 RT.
- ⑭ STA. 40+660 RT.
- ⑮ STA. 40+720 RT.
- ⑯ STA. 40+480 LT.
- ⑰ STA. 40+540 LT.
- ⑱ STA. 40+600 LT.
- ⑲ STA. 40+660 LT.
- ⑳ STA. 40+720 LT.

NOTE:
 1. SETBACK SHALL BE MIN. 9 m (30') FROM EDGE OF TRAFFIC LANE OR 1.2 m (4') BEHIND GUARDRAIL, UNLESS BREAKAWAY TYPE POLE IS USED.

TYPICAL TEMPORARY LIGHTING FOR MULTIPLE TRAFFIC LANE TAPERS (CROSSOVERS)
 ALL STAGES

LAYOUT	J.H.	04/10/02
DRAWN	J.H.	03/05/04
REVIEWED	D.H.	03/18/04

10/6/2009
#1/ER

REVISIONS	
NAME	DATE

ILLINOIS DEPARTMENT OF TRANSPORTATION
 F.A.I. 55
 SECTION (57-4)R, HBY, HBR, (57-4VB)DM
 MCLEAN COUNTY

TEMPORARY LIGHTING PLANS

JOB NO.	94S2063
DATE	10/6/2009