

 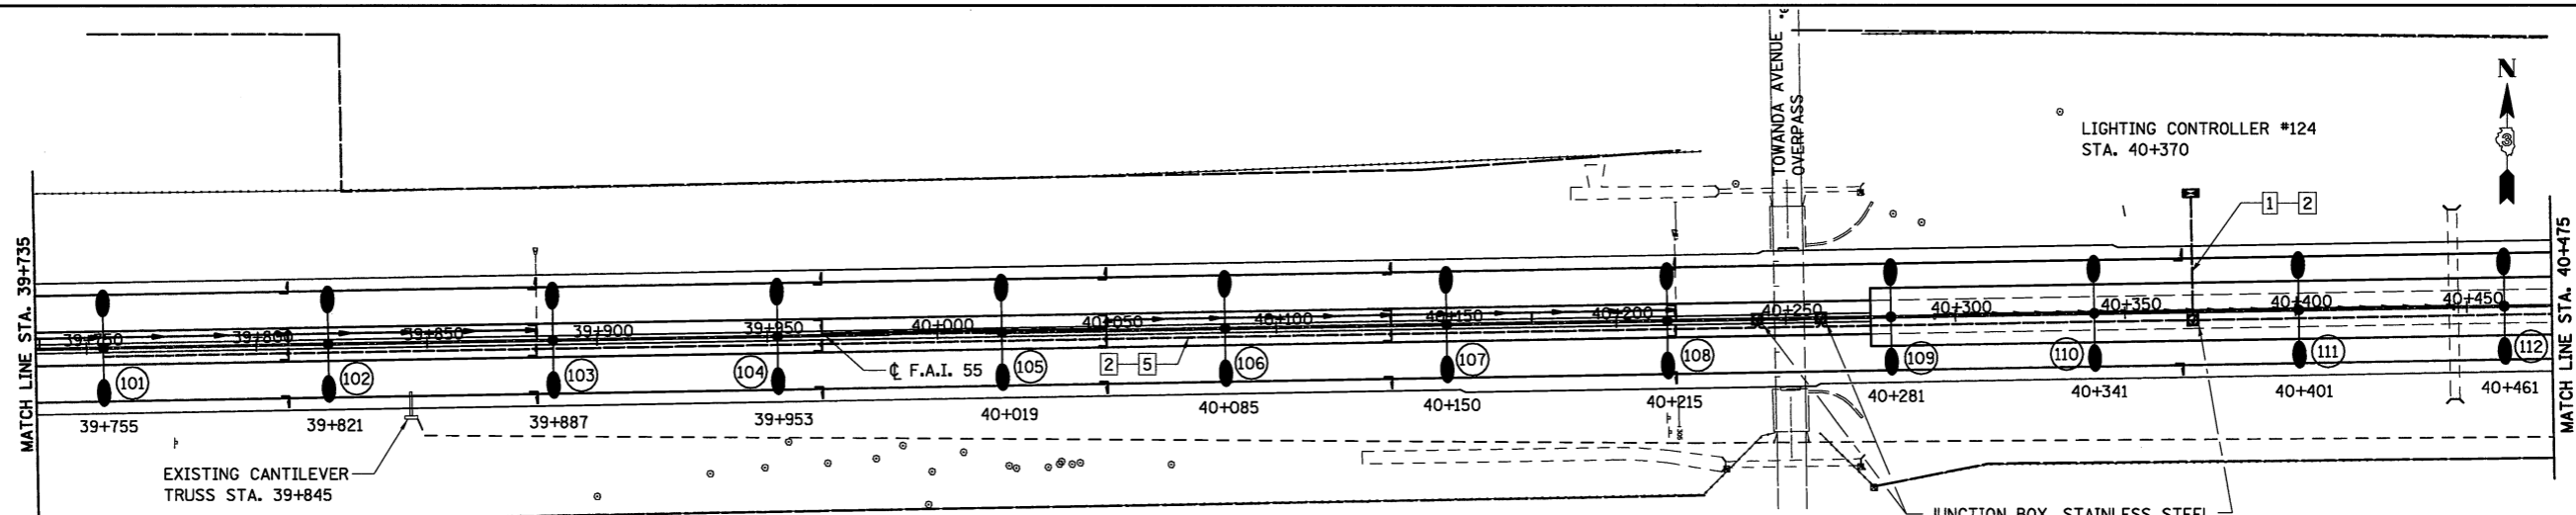
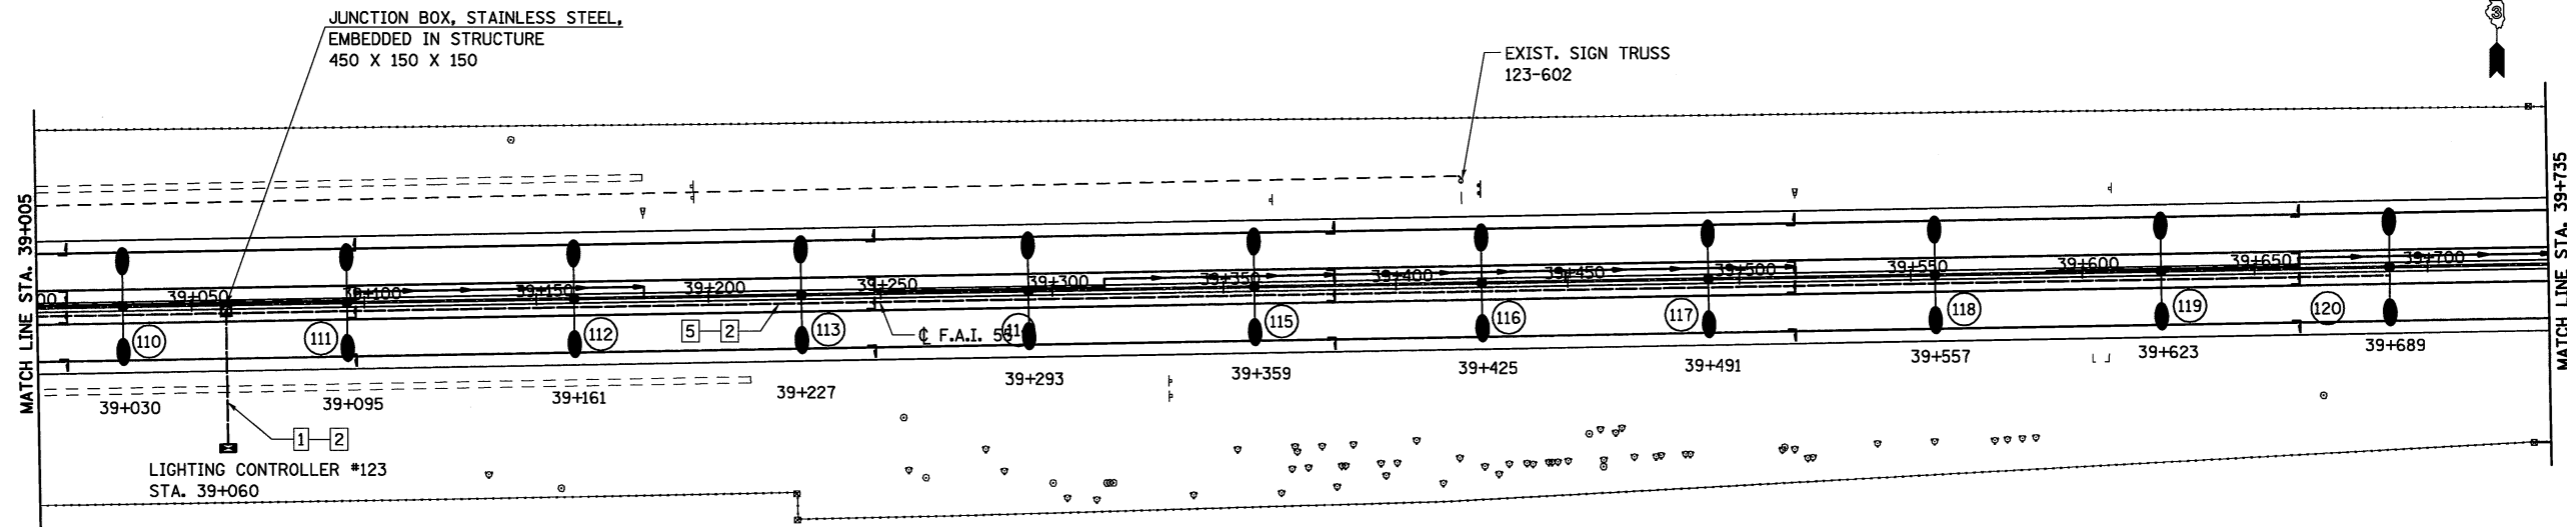


F.A.I. RTE.	SECTION	COUNTY	TOTAL SHEETS	SHEET NO.
55		MCLEAN	310	108
FED. ROAD DIST. NO.	ILLINOIS	FED. AID PROJECT		
* (57-4)R, HBY, HBR, (57-4)B)DM CONTRACT #70757				



LEGEND	
1	CONDUIT PUSHED, 50 mm GALVANIZED STEEL
2	2 #6XLP, 1 #6XLP-G
3	UNIT DUCT, 2 #6XLP, 1 #6XLP-G, 25 P
4	CONDUIT ATTACHED TO STRUCTURE, 50 mm DIA., GALVANIZED STEEL
5	CONDUIT EMBEDDED IN STRUCTURE, 50 mm PVC
6	CONDUIT ATTACHED TO STRUCTURE 20 mm DIA., GALVANIZED STEEL
7	2 #10XLP, 1 #10XLP-G
8	CONDUIT IN TRENCH, 50 mm GALVANIZED STEEL
[Symbol]	UNDERPASS LUMINAIRE, 150W HPS
[Symbol]	JUNCTION BOX, EXISTING
[Symbol]	JUNCTION BOX, PROPOSED, SIZE AS NOTED
[Symbol]	LIGHTING CONTROLLER, PROPOSED
[Symbol]	PROP. LIGHT POLE, TWIN DAVIT/LUMINAIRES
[Symbol]	PROP. LIGHT POLE, TWIN DAVIT/LUMINAIRES INSTALLED ON EXISTING FOUNDATION
[Symbol]	PROPOSED CONDUIT OR UNIT DUCT
[Symbol]	EXISTING LIGHTPOLE AND FOUNDATION TO BE REMOVED
[Symbol]	EXISTING LIGHTING UNIT

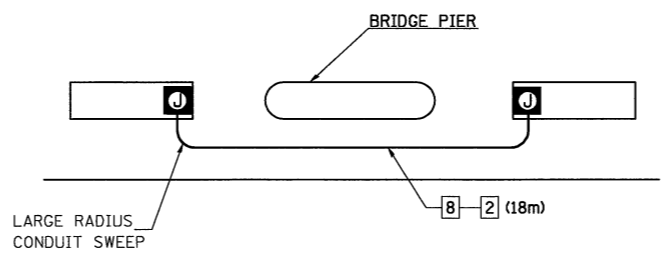

ILLINOIS DEPARTMENT OF TRANSPORTATION  
F.A.I. 55  
SECTION (57-4)R, HBY, HBR, (57-4)B)DM  
MCLEAN COUNTY  
**LIGHTING PLAN**  
I-55

REVISIONS	
NAME	DATE

**HANSON**

JOB NO. 94S2063  
DATE 8/20/2009

LAYOUT	04/10/02
DRAWN	JAH
REVIEWED	DLH
	03/18/04

8/20/2009 #FILE#