

F.A.P. RTE.	SECTION	COUNTY	TOTAL SHEETS	SHEET NO.
609	...	ST. CLAIR	350	50
STA. 84+00		TO STA. 100+00		
FED. ROAD DIST. NO. [ILLINOIS] FED. AID PROJECT				
... 76RS-2, 76-2BR-21				

STAGE 1 SEQUENCE OF OPERATIONS

- CONSTRUCT TEMPORARY RUNAROUNDS AND ASSOCIATED DRAINAGE ITEMS USING TRAFFIC CONTROL AND PROTECTION STANDARDS 701006, 701306 AND 701326
- BEGIN OPERATION OF TRAFFIC ON RUNAROUNDS USING STANDARD 701331. ADD ALL SIGNING ACCORDING TO STANDARD 701331.

NOTE: MAINTAIN ACCESS TO PRIVATE ENTRANCE ON MINE HAUL ROAD DURING STAGE 1.

- (51) STA. 2+38, 18' RT. (ZINGG RD. RUNAROUND) MANHOLES, TYPE A, 4'-DIA., TYPE 8 GRATE
RIM = 571.80
FL(S) = 568.50
FL(E) = 569.38
FL(N) = 567.78
- (52) STA. 2+25 (ZINGG RD. RUNAROUND) PIPE CULVERTS, CL D, TY 2 15" (TEMPORARY) = 64 FOOT
USFL = 567.78 (MANHOLE)
DSFL = 566.50 (STA. 2+00, 35' LT.)
- (53) STA. 2+53, 46' RT. (ZINGG RD. RUNAROUND) PIPE CULVERTS, CL D, TY 2 15" (TEMPORARY) = 36 FOOT
USFL = 570.80 (STA. 2+71, 48' RT.)
DSFL = 569.60 (STA. 2+35, 43' RT.)
- (54) STA. 2+59, 19' RT. (ZINGG RD. RUNAROUND) PIPE CULVERTS, CL D, TY 2 15" (TEMPORARY) = 46 FOOT
USFL = 571.45 (STA. 2+85, 20' RT.)
DSFL = 569.38 (MANHOLE)
- (55) STA. 93+55, 34' LT. (IL RTE 163) PIPE CULVERTS, CL A, TY 1 15" = 98 FOOT PRECAST REINFORCED CONCRETE FLARED END SECTIONS 15" = 2 EACH
USFL = 572.40 (STA. 93+10)
DSFL = 571.50 (STA. 94+20)
- (56) STA. 2+00, 18' LT. (MINE HAUL RD. RUNAROUND) INLET, TY A TYPE 8 GRATE
RIM = 566.80
FL = 564.80
- (57) STA. 2+38 (MINE HAUL RD. RUNAROUND) PIPE CULVERTS, CL D, TY 2 15" (TEMPORARY) = 82 FOOT
USFL = 564.80 (INLET)
DSFL = 564.00 (STA. 2+75, 22' RT.)



LEGEND

- TYPE III BARRICADE WITH FLASHING LIGHTS
- DRUM WITH STEADY BURNING LIGHT STOP LINE 24"
- DOUBLE VERTICAL PANEL
- DOUBLE VERTICAL PANEL W/ TYPE C BIDIRECTIONAL REFLECTOR
- TEMPORARY CONCRETE BARRIER
- IMPACT ATTENUATORS, TEMPORARY (FULLY REDIRECTIVE NARROW)

DATE	
BY	
REVISIONS	
NO.	
DATE	
BY	
REVISIONS	
NO.	
DATE	
BY	
REVISIONS	
NO.	

DATE	
BY	
REVISIONS	
NO.	
DATE	
BY	
REVISIONS	
NO.	
DATE	
BY	
REVISIONS	
NO.	

PLOT DATE = 9/17/2008 @ 11:46 AM
 PLOT SCALE = 1"=50'
 MODEL = 76A34-21
 OPERATOR = sctomvppj

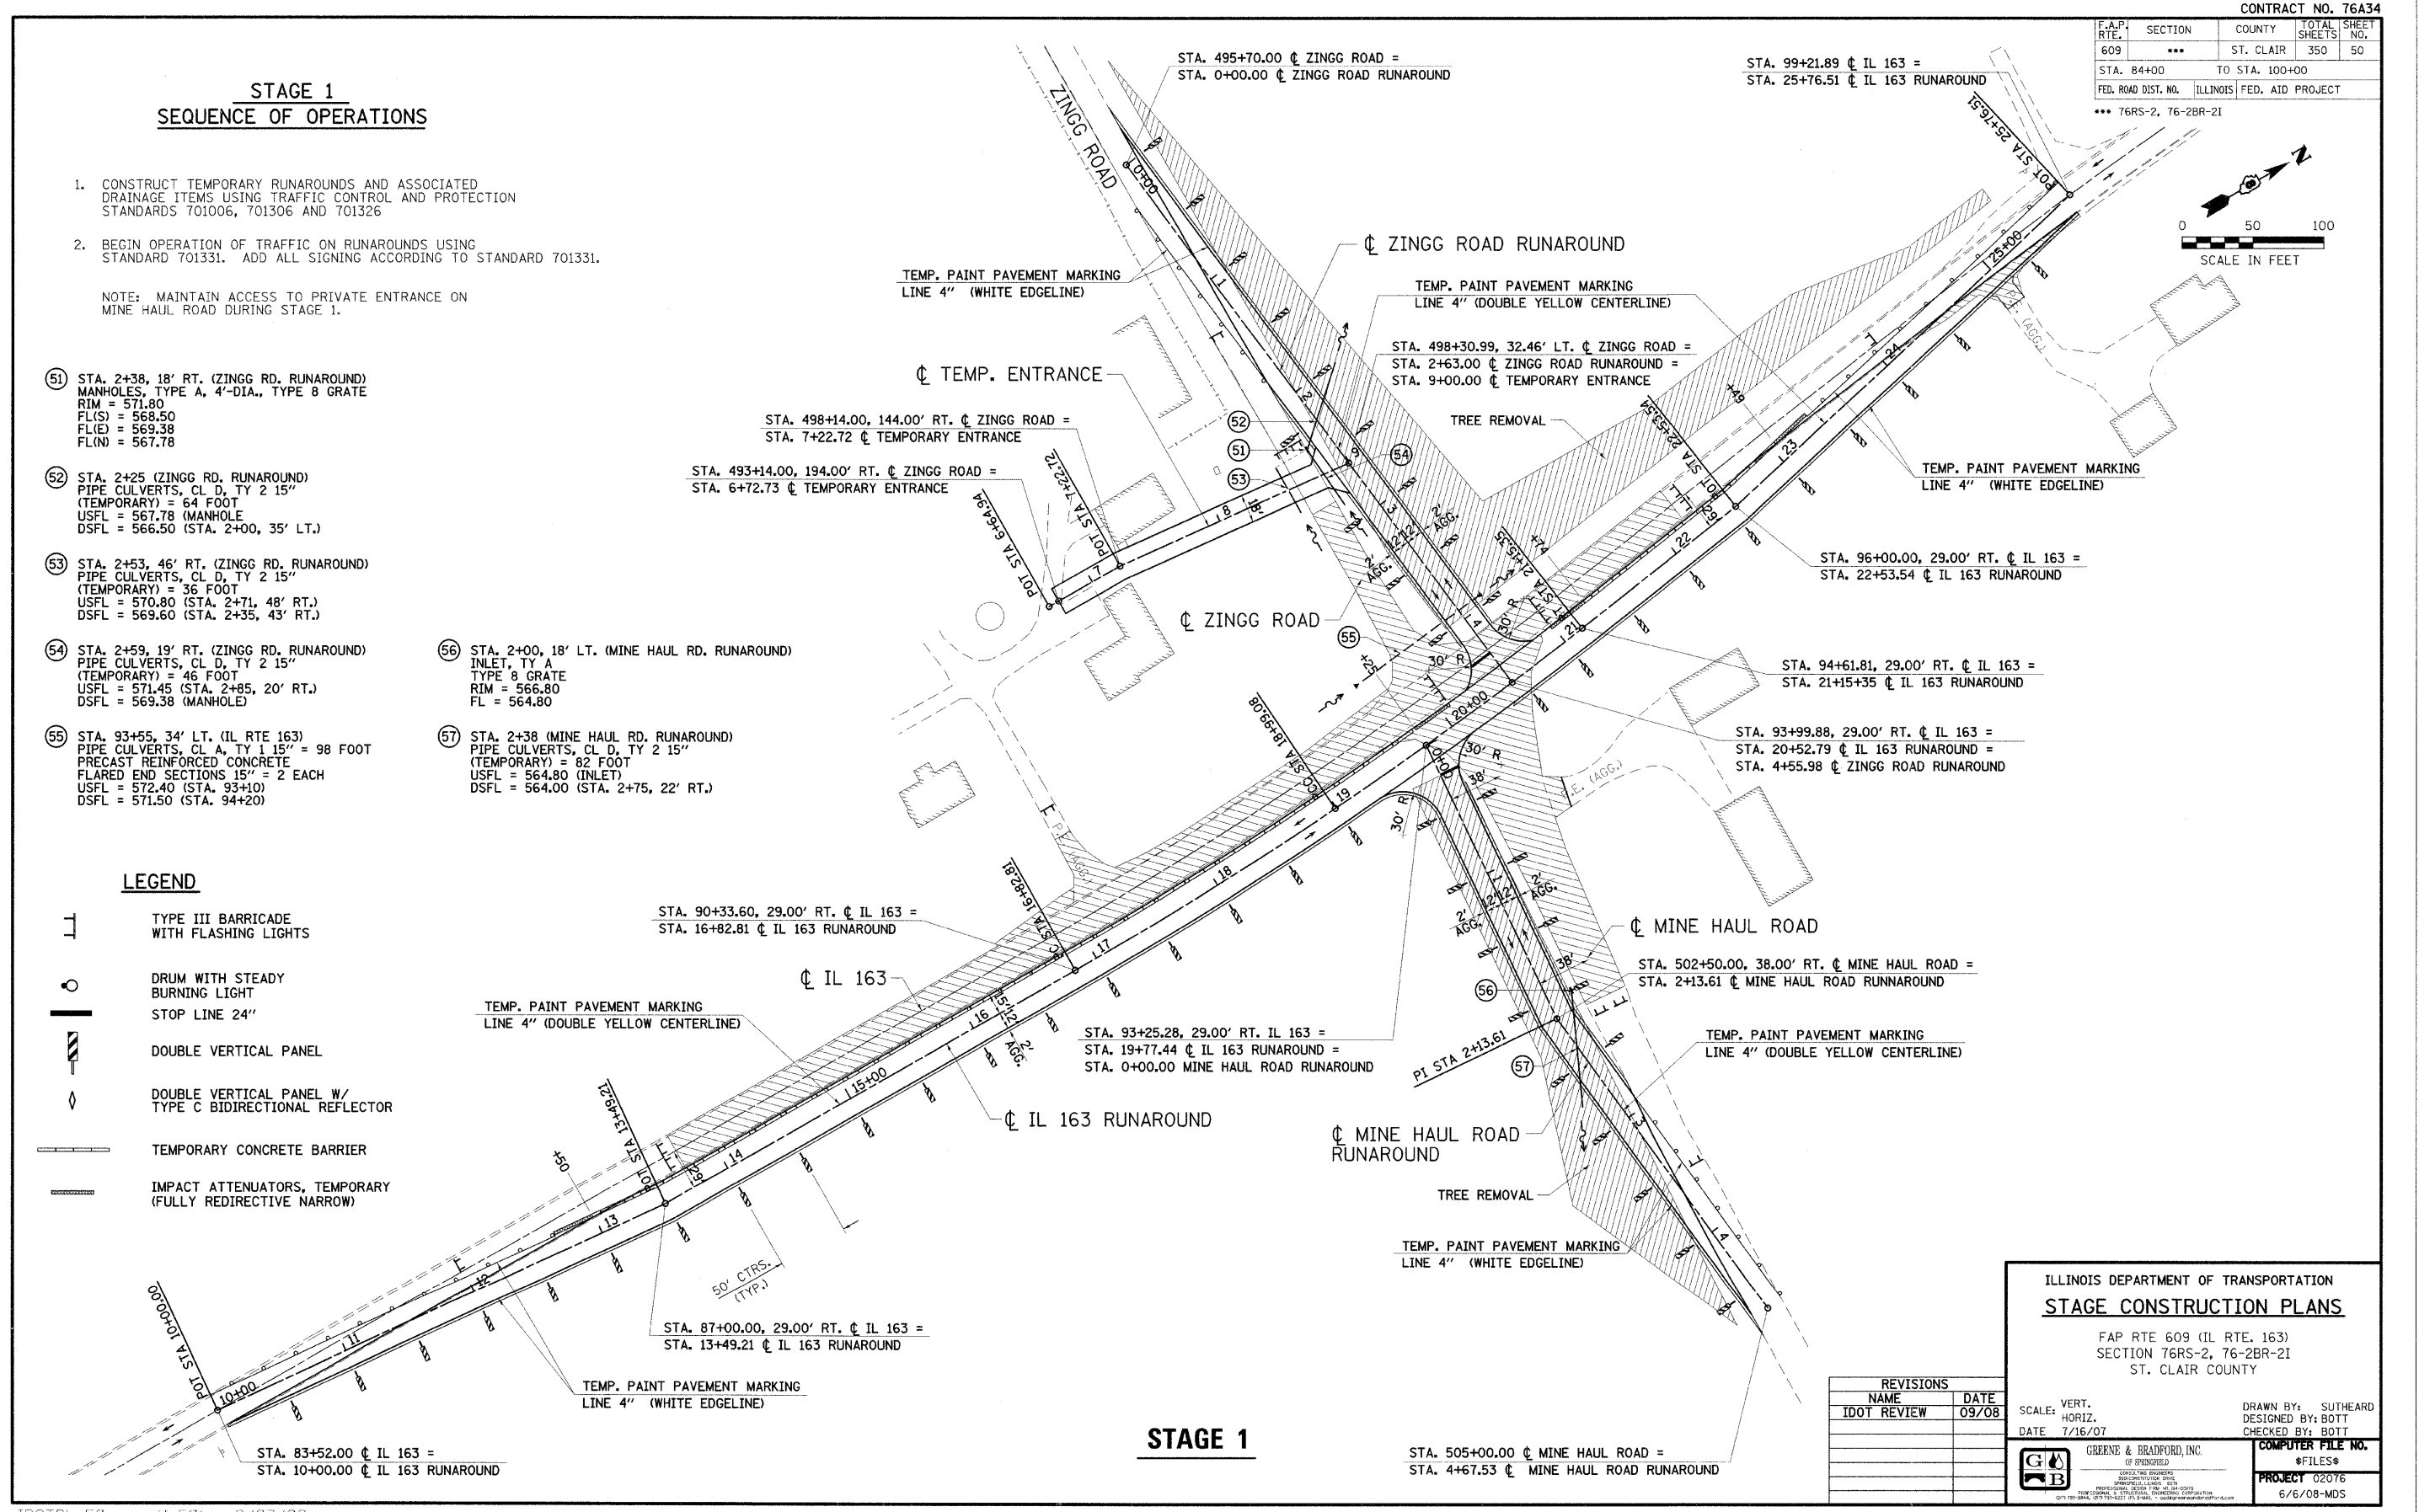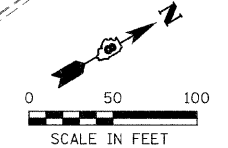

REVISIONS	
NAME	DATE
IDOT REVIEW	09/08

ILLINOIS DEPARTMENT OF TRANSPORTATION
STAGE CONSTRUCTION PLANS
 FAP RTE 609 (IL RTE. 163)
 SECTION 76RS-2, 76-2BR-21
 ST. CLAIR COUNTY

SCALE: VERT. _____
 HORIZ. _____
 DATE 7/16/07

DRAWN BY: SUTHEARD
 DESIGNED BY: BOTT
 CHECKED BY: BOTT

GREENE & BRADFORD, INC.
 OF SPRINGFIELD

COMPUTER FILE NO. #FILES#
 PROJECT 02076
 6/6/08-MDS

STAGE 1