


F.A.P. RTE.	SECTION	COUNTY	TOTAL SHEETS	SHEET NO.
609	***	ST. CLAIR	350	51
STA. 84+00		TO STA. 100+00		
FED. ROAD DIST. NO.		ILLINOIS FED. AID PROJECT		
** 76RS-2, 76-2BR-21				

**STAGE 2A**  
**SEQUENCE OF OPERATIONS**

1. REMOVE EXISTING PAVEMENT, SHOULDERS AND DRAINAGE STRUCTURES.

NOTE: MAINTAIN ACCESS TO PRIVATE ENTRANCE ON MINE HAUL ROAD DURING STAGE 2A.

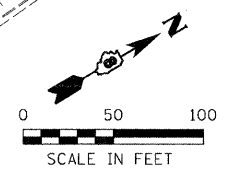


PLAN	DATE	BY
SURVEYED		
PLOTTED		
CHECKED		
RT. OF WAY CHECKED		
CADD FILE NAME		
NO.		

PROFILE	DATE	BY
SURVEYED		
PLOTTED		
CHECKED		
STRUCTURE NOTATIONS CHECKED		
NO.		

PLOT DATE = 7/28/2008 1:37:16 PM  
 PLO NAME = J:\02076\CONTRMINS\PLN\STG2A.dgn  
 PLO SCALE = 1"=50'  
 MODEL = Defaul  
 OPERATOR = mbr-ka

**LEGEND**

PAVEMENT / SHOULDER REMOVAL

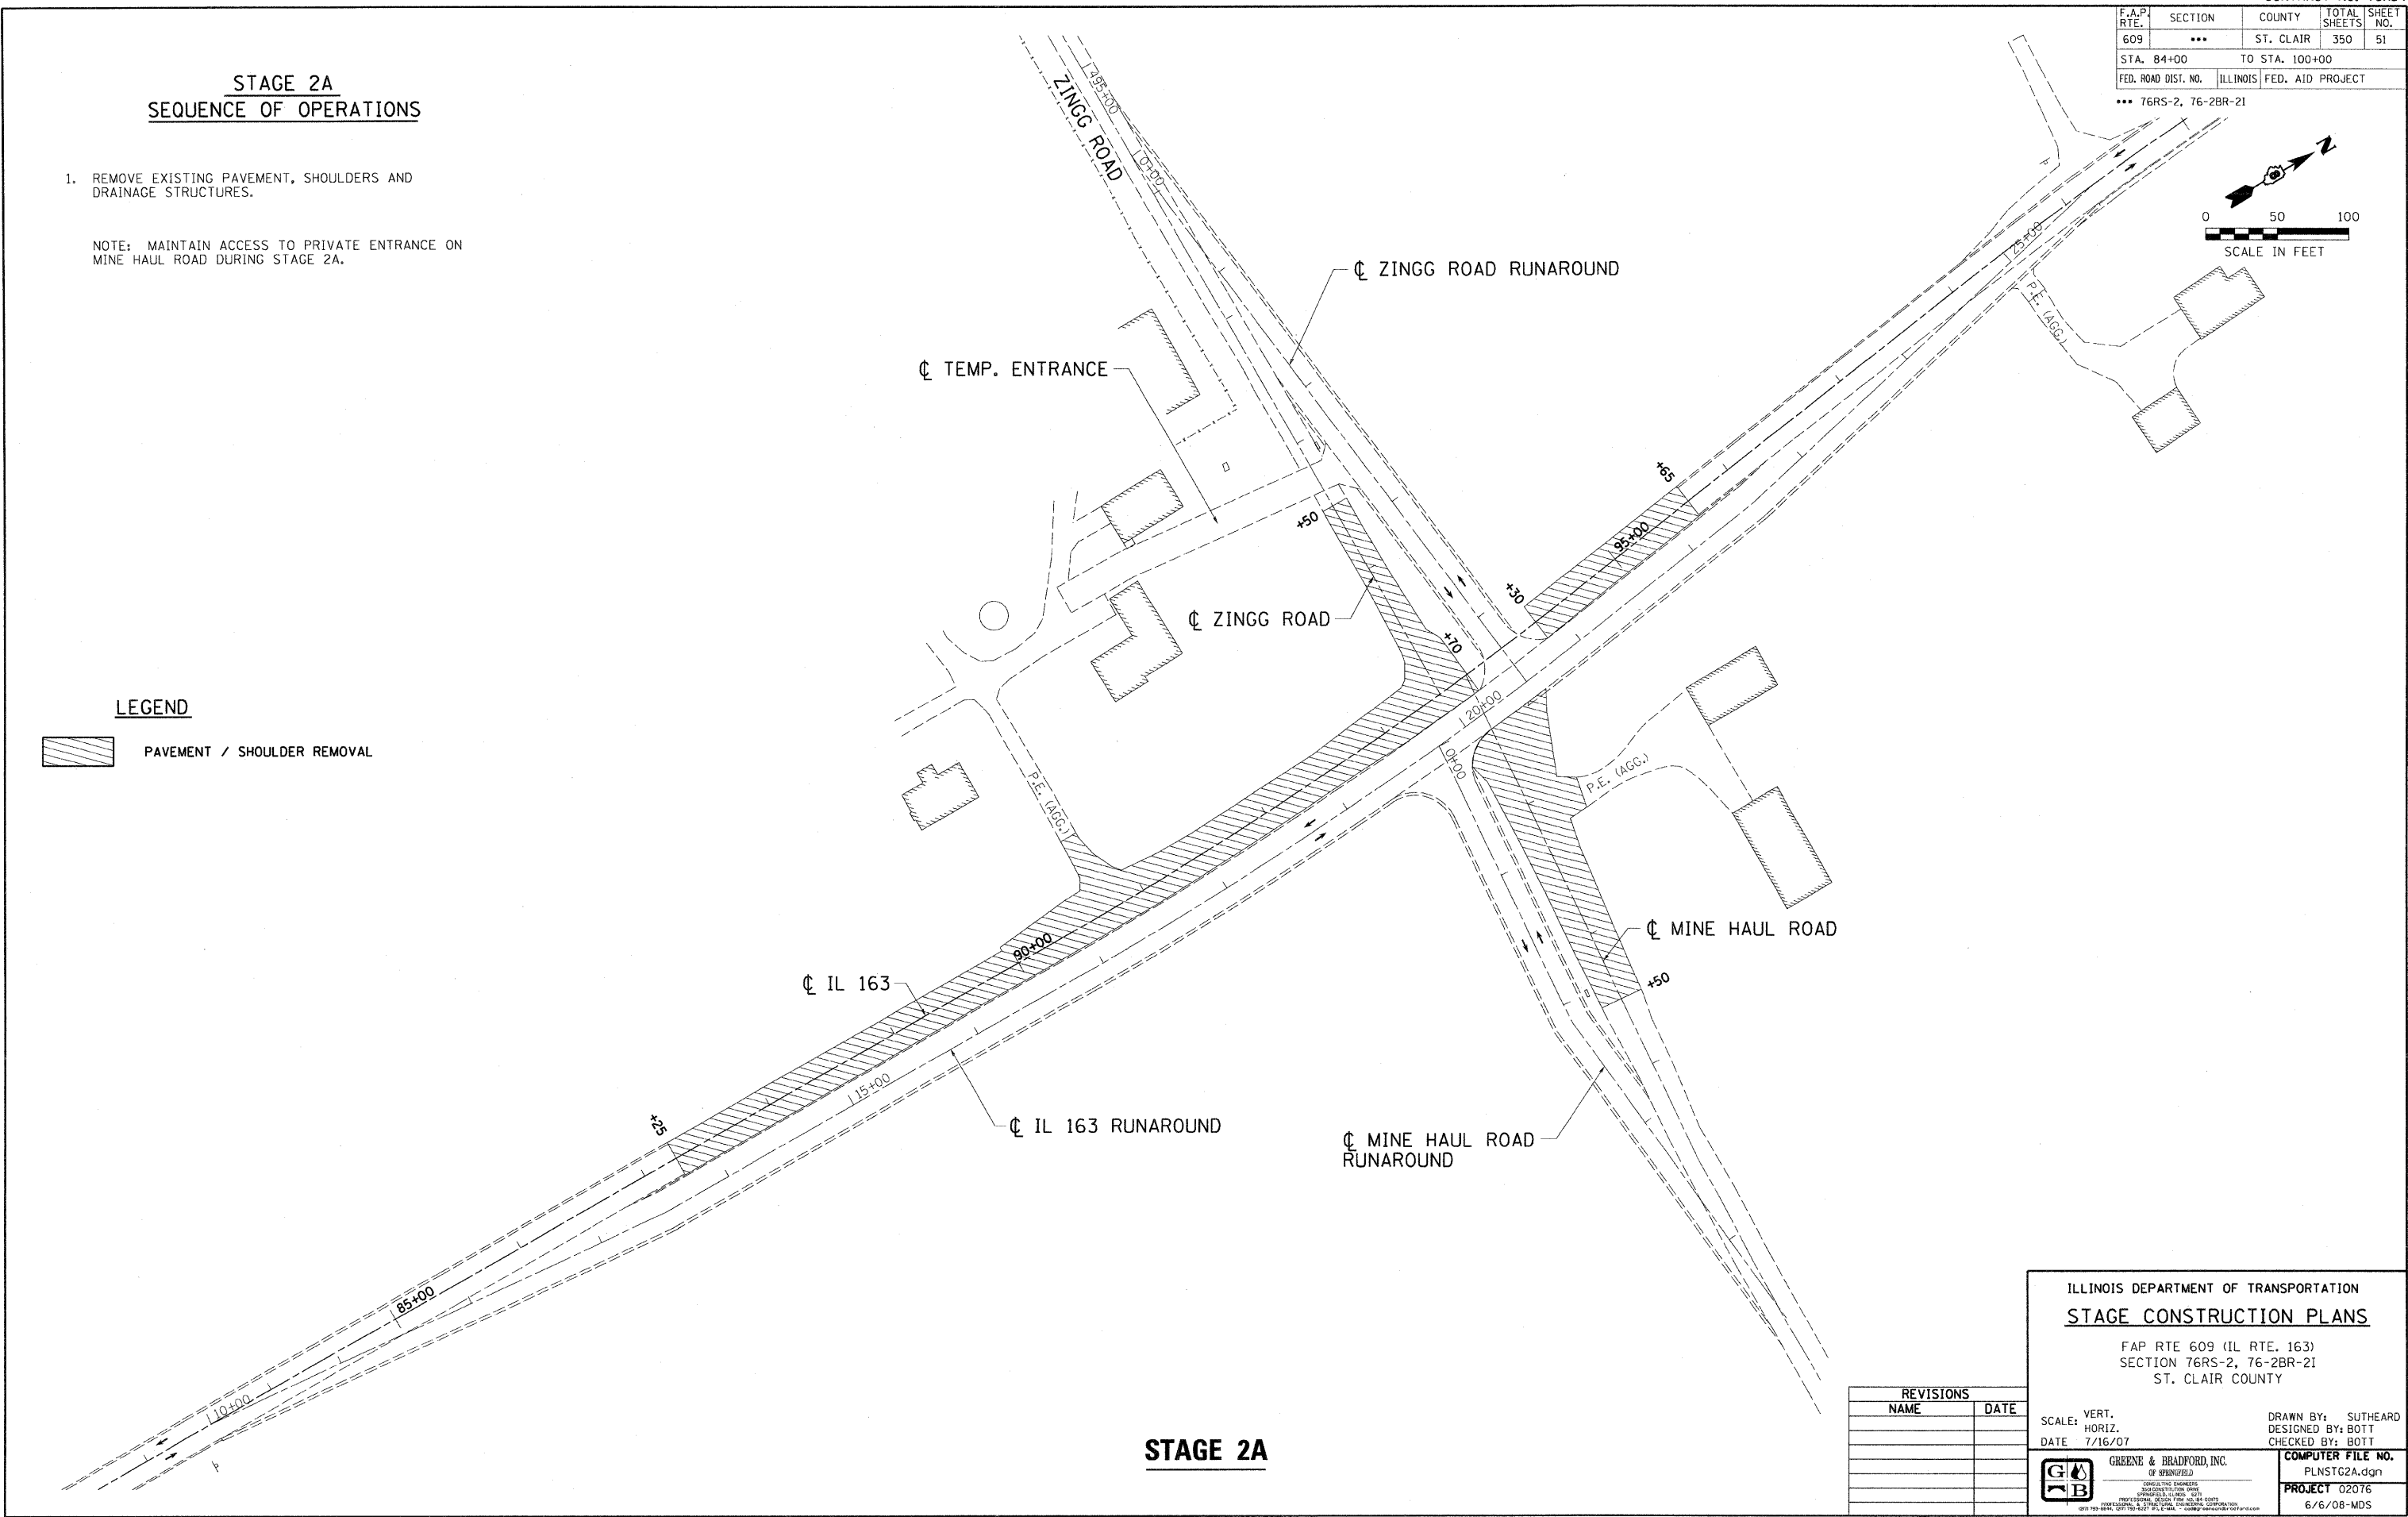

**STAGE 2A**

REVISIONS	
NAME	DATE

ILLINOIS DEPARTMENT OF TRANSPORTATION  
**STAGE CONSTRUCTION PLANS**  
 FAP RTE 609 (IL RTE. 163)  
 SECTION 76RS-2, 76-2BR-21  
 ST. CLAIR COUNTY

SCALE: VERT. \_\_\_\_\_  
 HORIZ. \_\_\_\_\_  
 DATE 7/16/07

DRAWN BY: SUTHEARD  
 DESIGNED BY: BOTT  
 CHECKED BY: BOTT

GREENE & BRADFORD, INC.  
 OF SPRINGFIELD  
 CONSULTING ENGINEERS  
 REGISTERED PROFESSIONAL ENGINEERS  
 PROFESSIONAL OFFICE: 1001 N. WASHINGTON ST., SUITE 200  
 SPRINGFIELD, ILLINOIS 62761-1000  
 (217) 799-8844 FAX (217) 799-8845

COMPUTER FILE NO.  
 PLNSTG2A.dgn  
 PROJECT 02076  
 6/6/08-MDS