


F.A.P. RTE.	SECTION	COUNTY	TOTAL SHEETS	SHEET NO.
609	...	ST. CLAIR	350	52
STA. 84+00		TO STA. 100+00		
FED. ROAD DIST. NO.		ILLINOIS FED. AID PROJECT		

... 76RS-2, 76-2BR-21

**STAGE 2B
SEQUENCE OF OPERATIONS**

1. CONSTRUCT PROPOSED PAVEMENT ON IL 163, ZINGG ROAD AND MINE HAUL ROAD TO BOTTOM OF LEVELING BINDER ELEVATION. CONSTRUCT SHOULDERS, ENTRANCES AND DITCHES (EXCEPT RIGHT SIDE OF IL 163).
2. REMOVE TEMPORARY RUNAROUND PAVEMENT AT IL 163 / ZINGG ROAD INTERSECTION. CONSTRUCT REMAINING PROPOSED PAVEMENT, SHOULDERS AND DITCH AT INTERSECTION.

NOTE: MAINTAIN ACCESS TO PRIVATE ENTRANCE ON MINE HAUL ROAD DURING STAGE 2B.

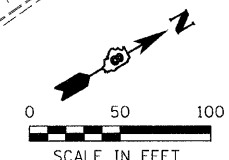



DATE	BY
DATE	BY
PLOT DATE = 7/26/2008 1:37:22 PM
 FILE NAME = J:\A\2007\UPR\AWINDS\PLN\STG2B.dgn
 MODEL SCALE = 1/8" = 1' IN.
 OPERATOR = mbr

LEGEND

PAVEMENT / SHOULDER REMOVAL

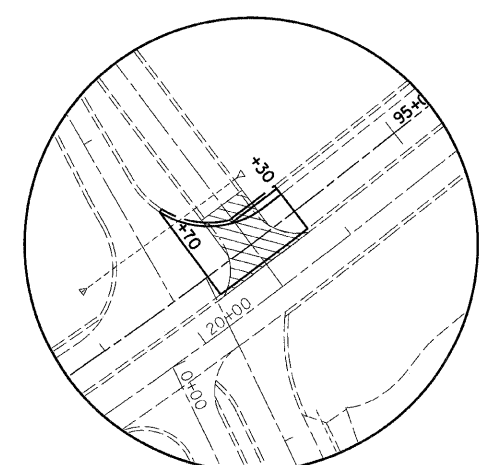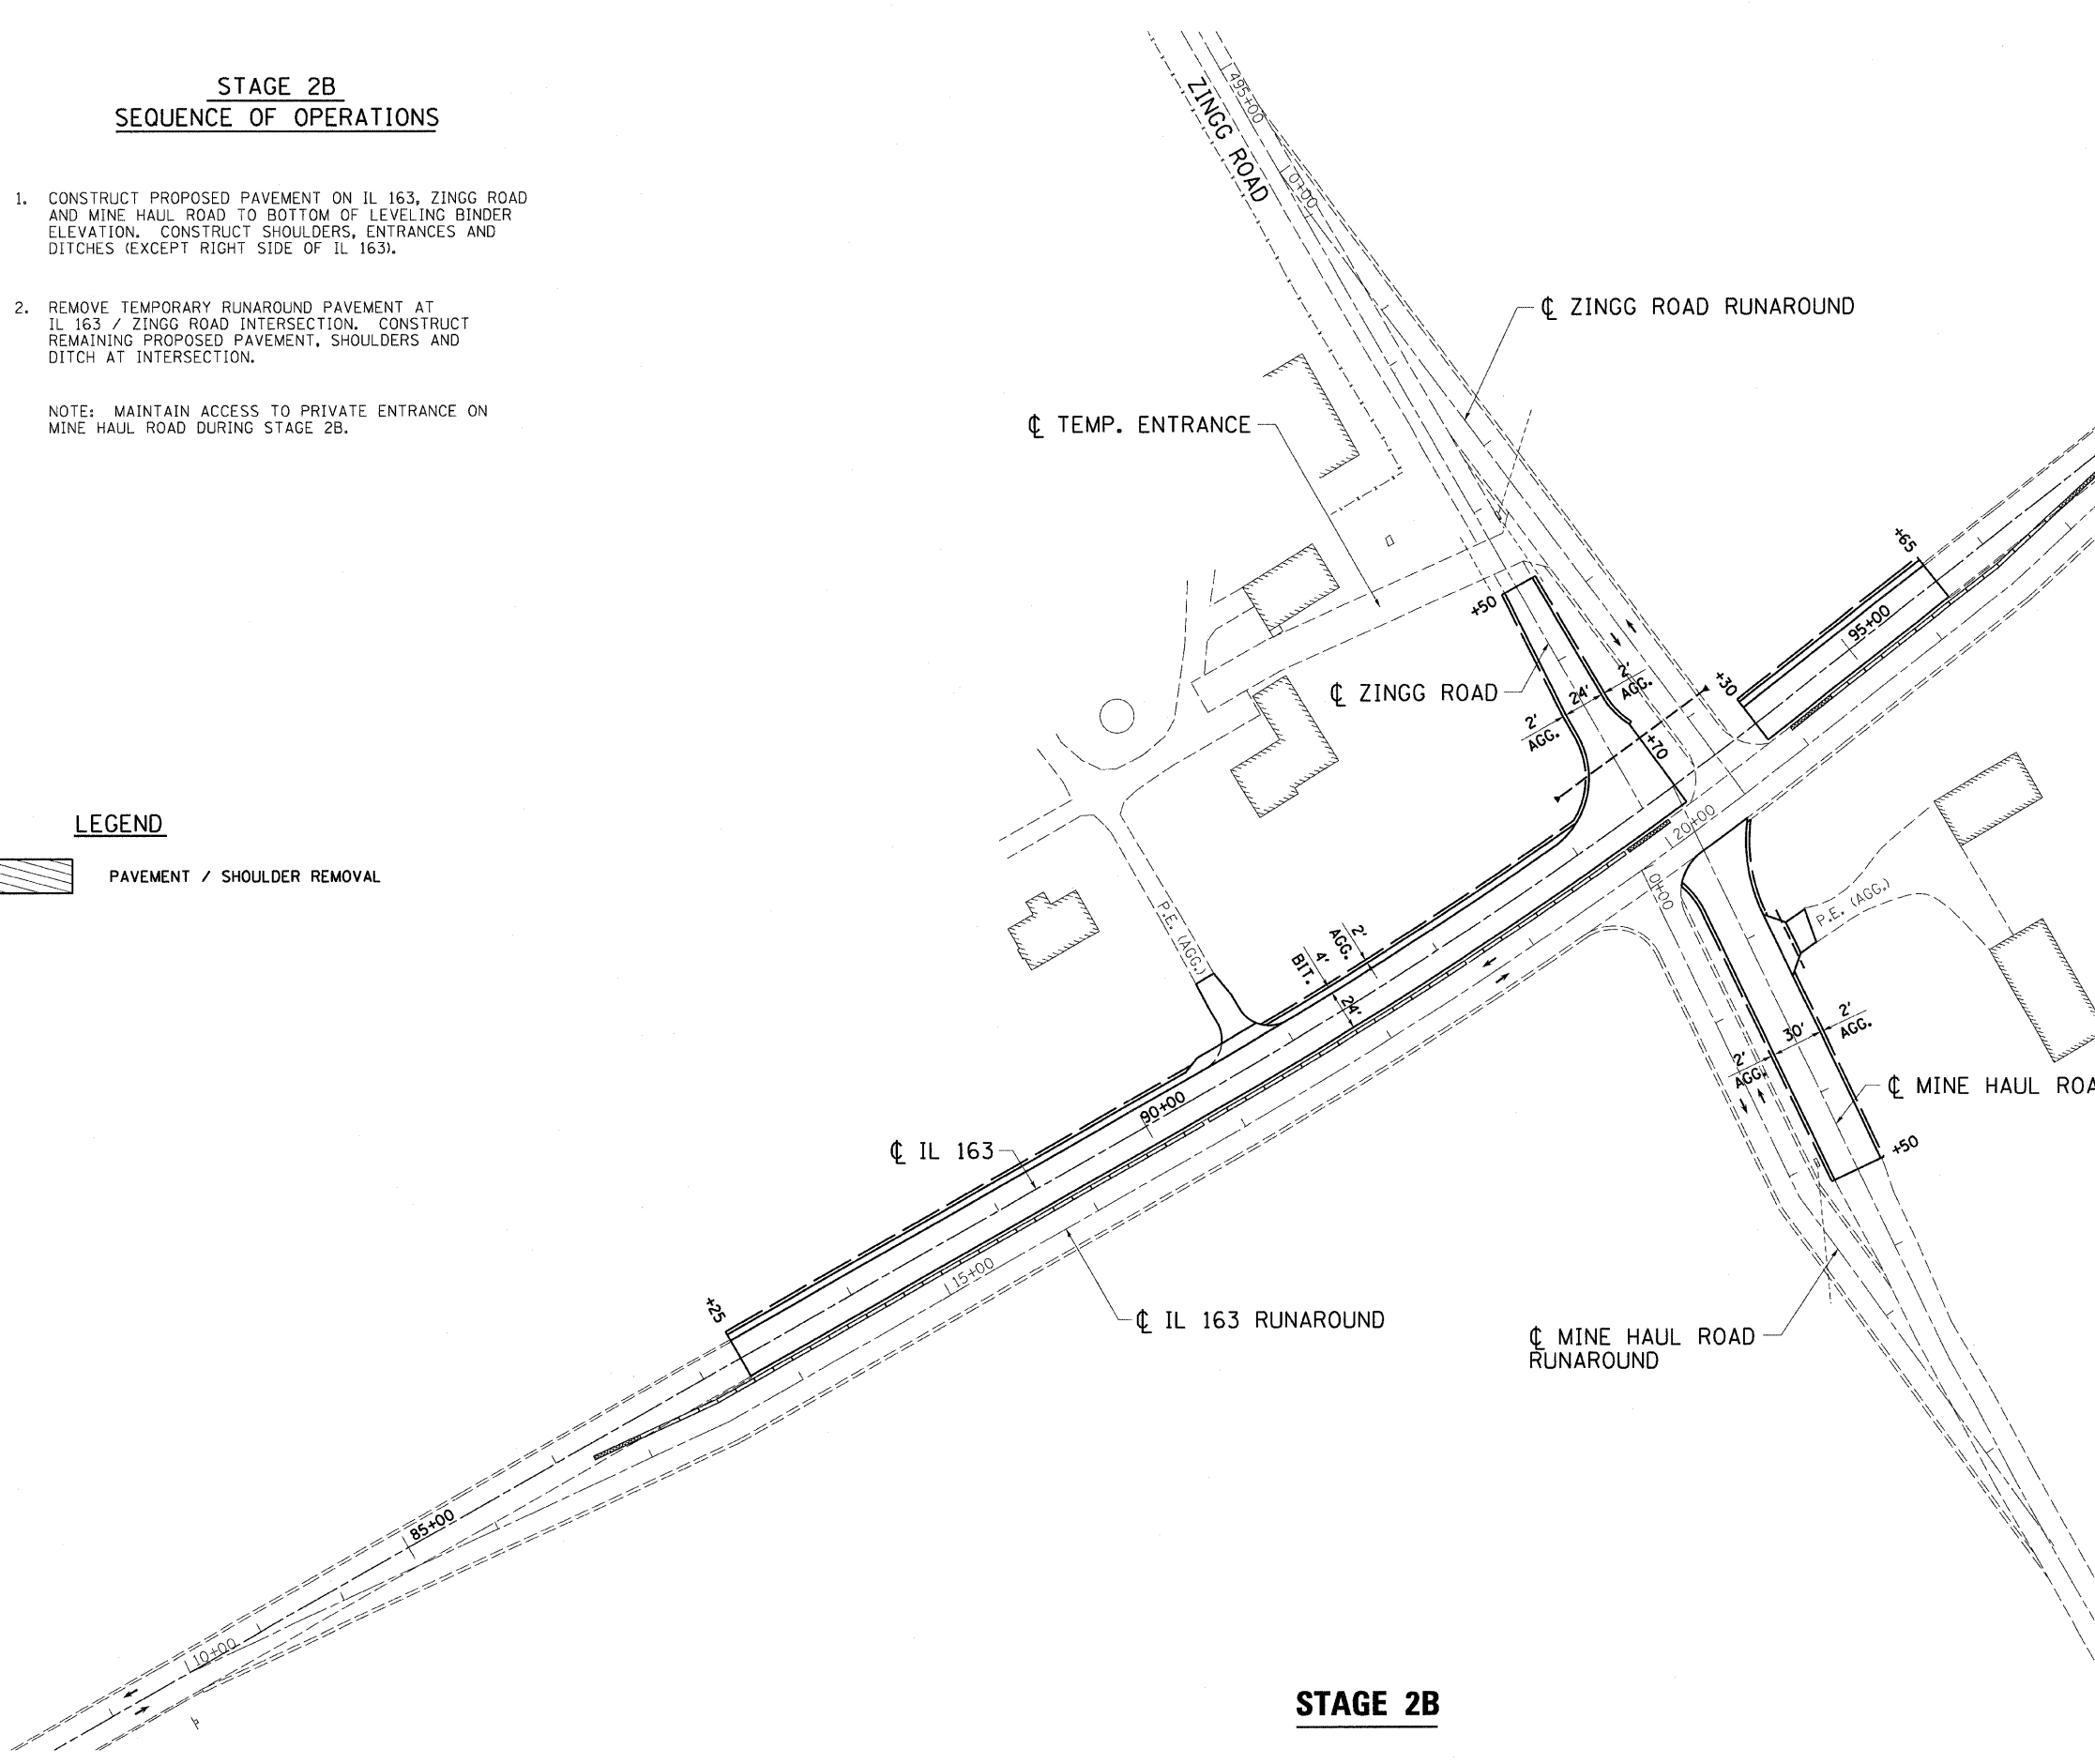

IL 163 / ZINGG ROAD
RADIUS CONSTRUCTION

STAGE 2B

REVISIONS	
NAME	DATE

ILLINOIS DEPARTMENT OF TRANSPORTATION
STAGE CONSTRUCTION PLANS

FAP RTE 609 (IL RTE. 163)
 SECTION 76RS-2, 76-2BR-21
 ST. CLAIR COUNTY

SCALE: VERT. _____
 HORIZ. _____
 DATE 7/16/07

DRAWN BY: SUTHEARD
 DESIGNED BY: BOTT
 CHECKED BY: BOTT

COMPUTER FILE NO.
 PLNSTG2B.dgn

PROJECT 02076
 6/3/08-MDS

GREENE & BRADFORD, INC.
 CIVIL ENGINEERS
 200 EAST HANCOCK AVENUE
 SPRINGFIELD, ILLINOIS 62761
 (217) 522-8844 (217) 522-8227 FAX (217) 522-8844