


F.A.P. RTE.	SECTION	COUNTY	TOTAL SHEETS	SHEET NO.
609	***	ST. CLAIR	350	53
STA. 84+00		TO STA. 100+00		
FED. ROAD DIST. NO.	ILLINOIS	FED. AID PROJECT		

*** 76RS-2, 76-2BR-21

STAGE 3A SEQUENCE OF OPERATIONS


1. MOVE TRAFFIC TO RECONSTRUCTED PAVEMENT ON IL 163, ZINGG ROAD AND MINE HAUL ROAD.
2. REMOVE TEMPORARY RUNAROUND PAVEMENTS, TEMPORARY ENTRANCE AND TEMPORARY DRAINAGE STRUCTURES.
3. CONSTRUCT SHOULDERS ALONG RIGHT SIDE OF IL 163 AND FINISH CONSTRUCTING NEW PAVEMENT ON MINE HAUL ROAD AT INTERSECTION TO BOTTOM OF LEVELING BINDER ELEVATION.
4. REGRADE AND RESHAPE TEMPORARY RUNAROUND AREAS. PERFORM FINAL GRADING AND SHAPING.

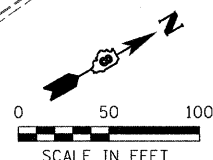

PLAN	REVISIONS	DATE
NO.	BY	
	DATE	
	BY	
	DATE	
	BY	
	DATE	

PROFILE	REVISIONS	DATE
NO.	BY	
	DATE	
	BY	
	DATE	
	BY	
	DATE	

PLOT DATE = 7/31/2008 3:05:56 PM
 FILE NAME = J:\A2076\DRAWINGS\PLN\STG3.dgn
 PLOT SCALE = 50.00000 1/4" = 1'-0"
 MODEL = Default
 OPERATOR =

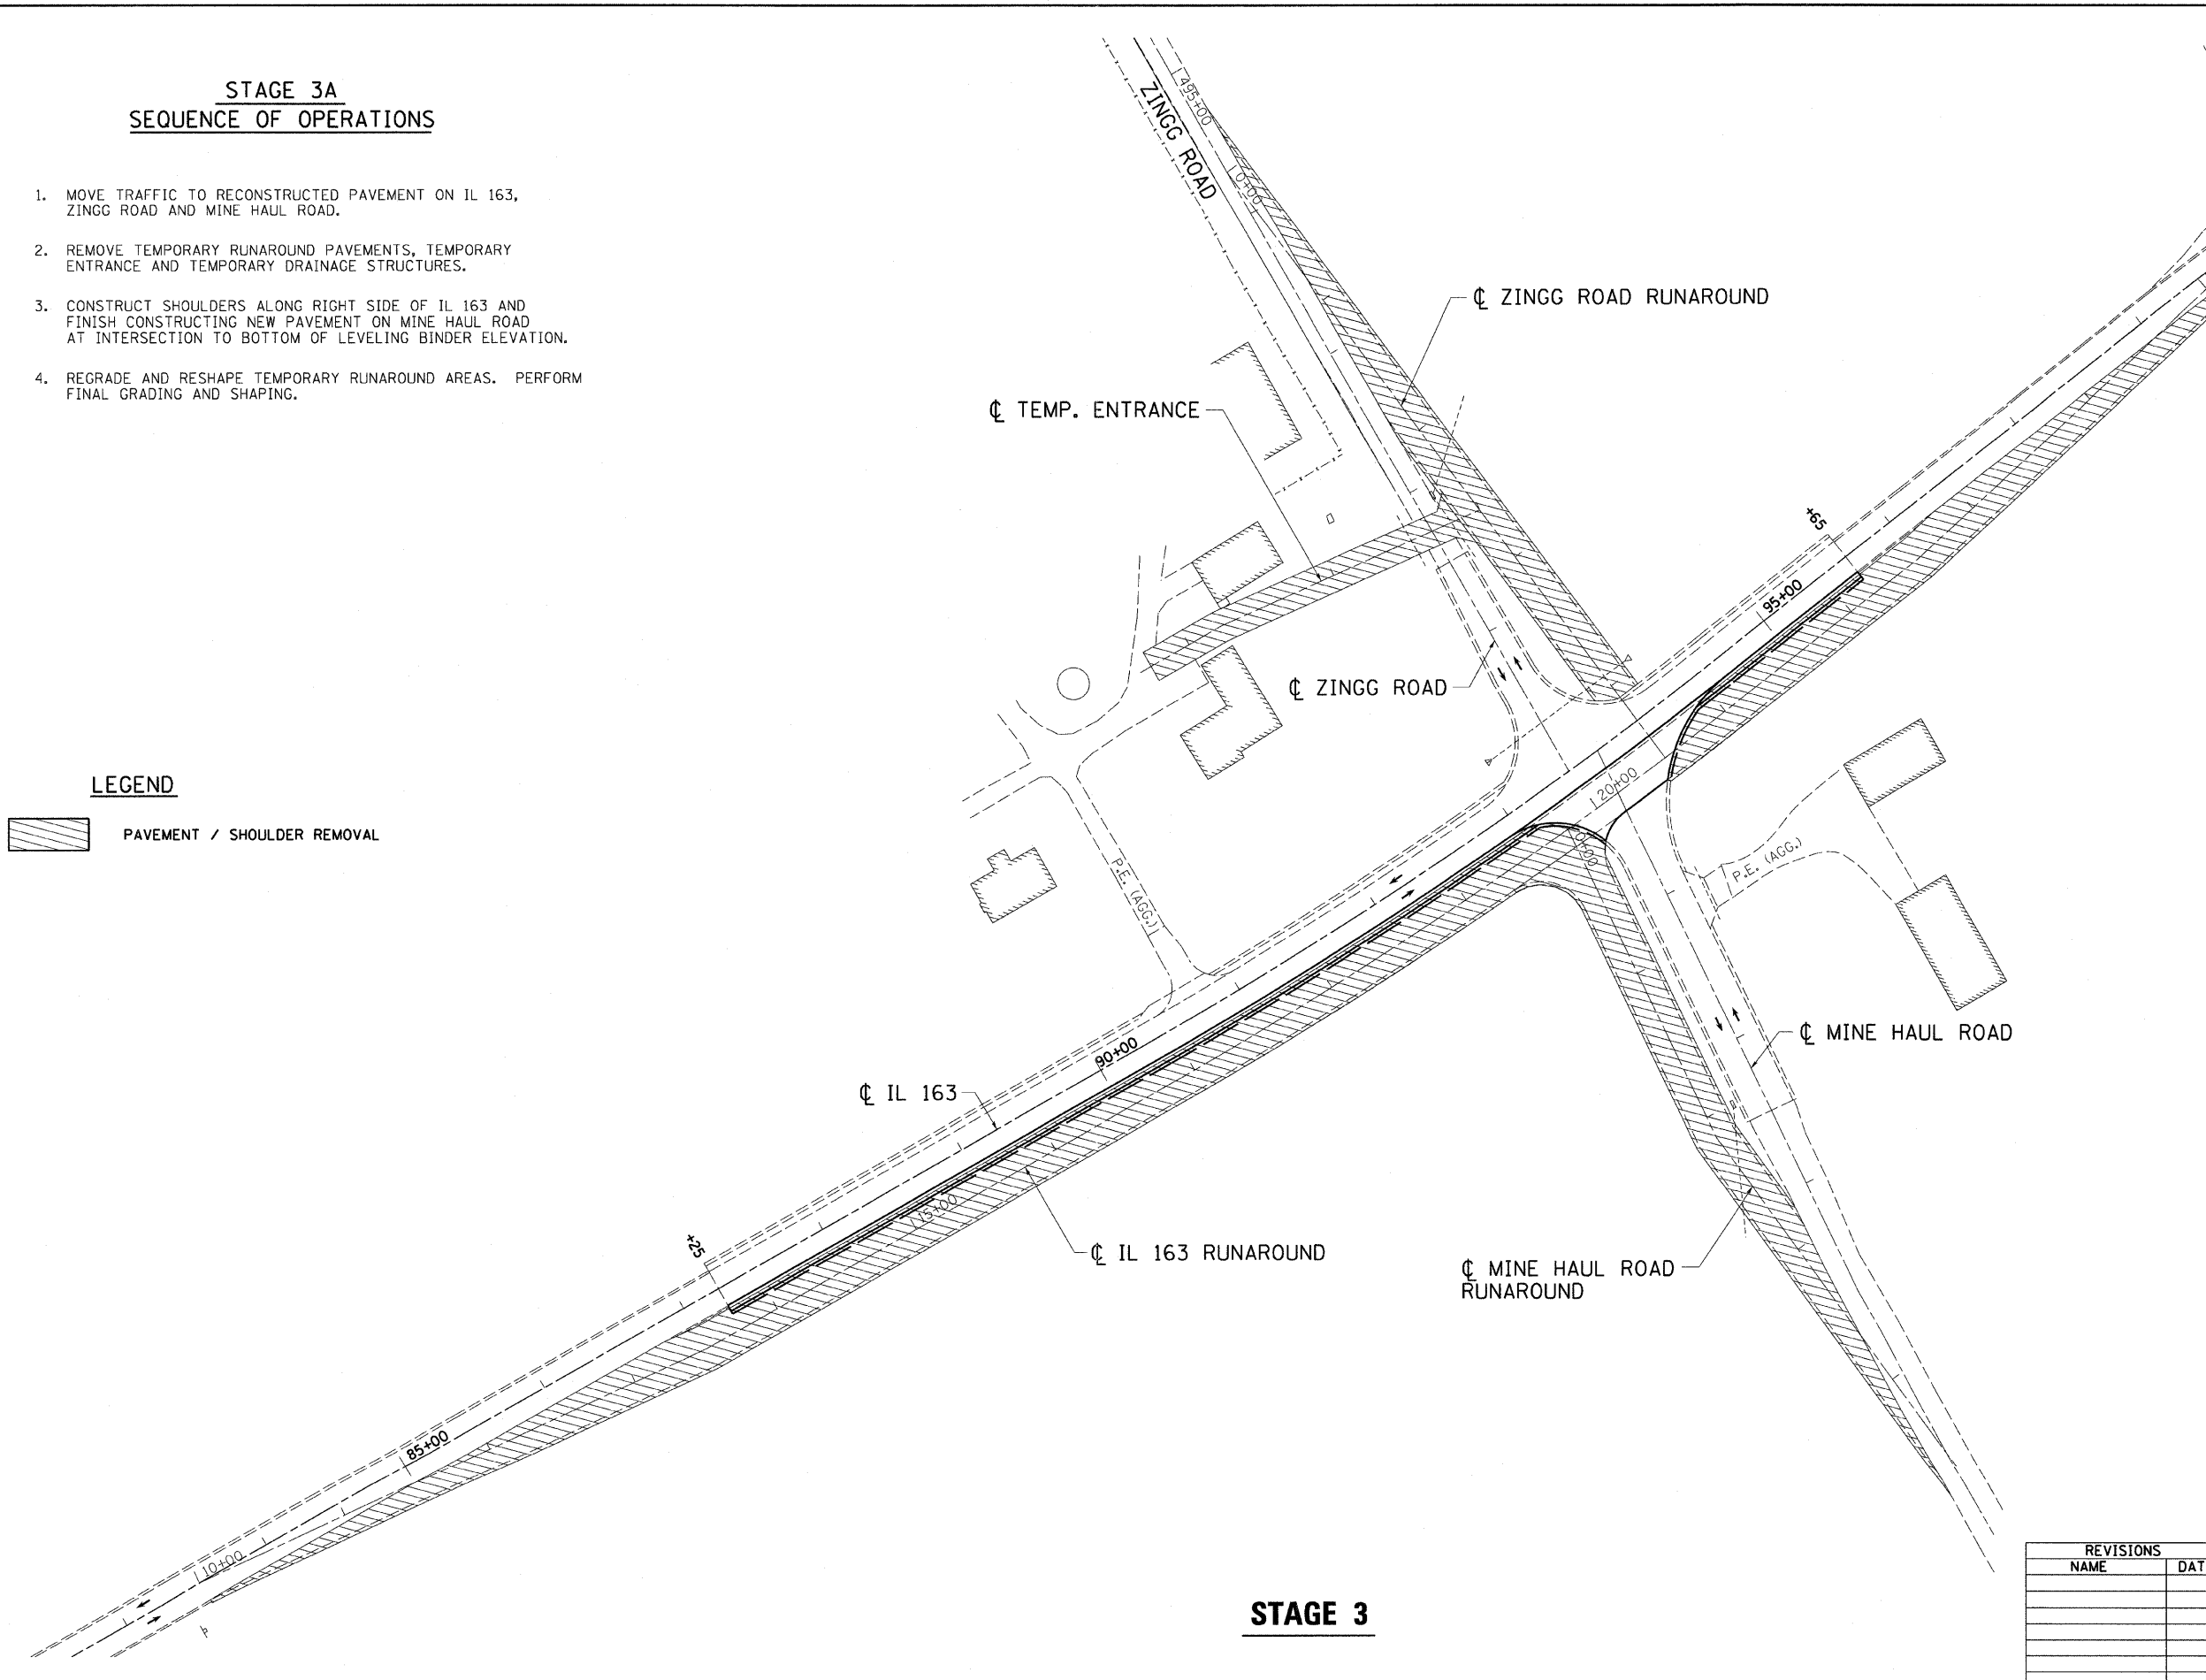

LEGEND

PAVEMENT / SHOULDER REMOVAL

STAGE 3

REVISIONS	
NAME	DATE

ILLINOIS DEPARTMENT OF TRANSPORTATION
STAGE CONSTRUCTION PLANS
 FAP RTE 609 (IL RTE. 163)
 SECTION 76RS-2, 76-2BR-21
 ST. CLAIR COUNTY

SCALE: VERT. _____
 HORIZ. _____
 DATE 7/16/07

DRAWN BY: SUTHEARD
 DESIGNED BY: BOTT
 CHECKED BY: BOTT

GREENE & BRADFORD, INC.
 OF SPRINGFIELD
 REGISTERED PROFESSIONAL ENGINEERS
 PROFESSIONAL DESIGN FIRM NO. 146-0079
 1017 19th St., Springfield, IL 62761-1017

COMPUTER FILE NO.
 PLNSTG3.dgn
 PROJECT 02076
 6/6/08-MDS