

WH007



CRAWFORD, MURPHY & TILLY, INC.
CONSULTING ENGINEERS
© Copyright CMT, Inc.

Whiteside County **AIRPORT**
JOSEPH H. BITTORF FIELD

Whiteside County
Airport

Sterling / Rock Falls,
Illinois

Whiteside County
Airport

AIP: 3-17-0098-B14
SQI-3830

REHABILITATE
TAXIWAY EDGE
LIGHTS (PARALLEL
/ CONNECTING
TAXIWAYS A AND E
EAST OF RUNWAY
18/36)

Revisions

No.	Date	Description

0 1
THIS BAR IS EQUAL TO 1"
AT FULL SCALE (17 X 11).

DESIGN BY: CMT-RFD

DRAWN BY: CMT-RFD

CHECKED BY: CMT-RFD

APPROVED BY: JGP


DATE: 7.25.2008

JOB No: 08292-04-00

**SITE PLAN
(ETP3)**

10

SHEET 10 OF 15 SHEETS

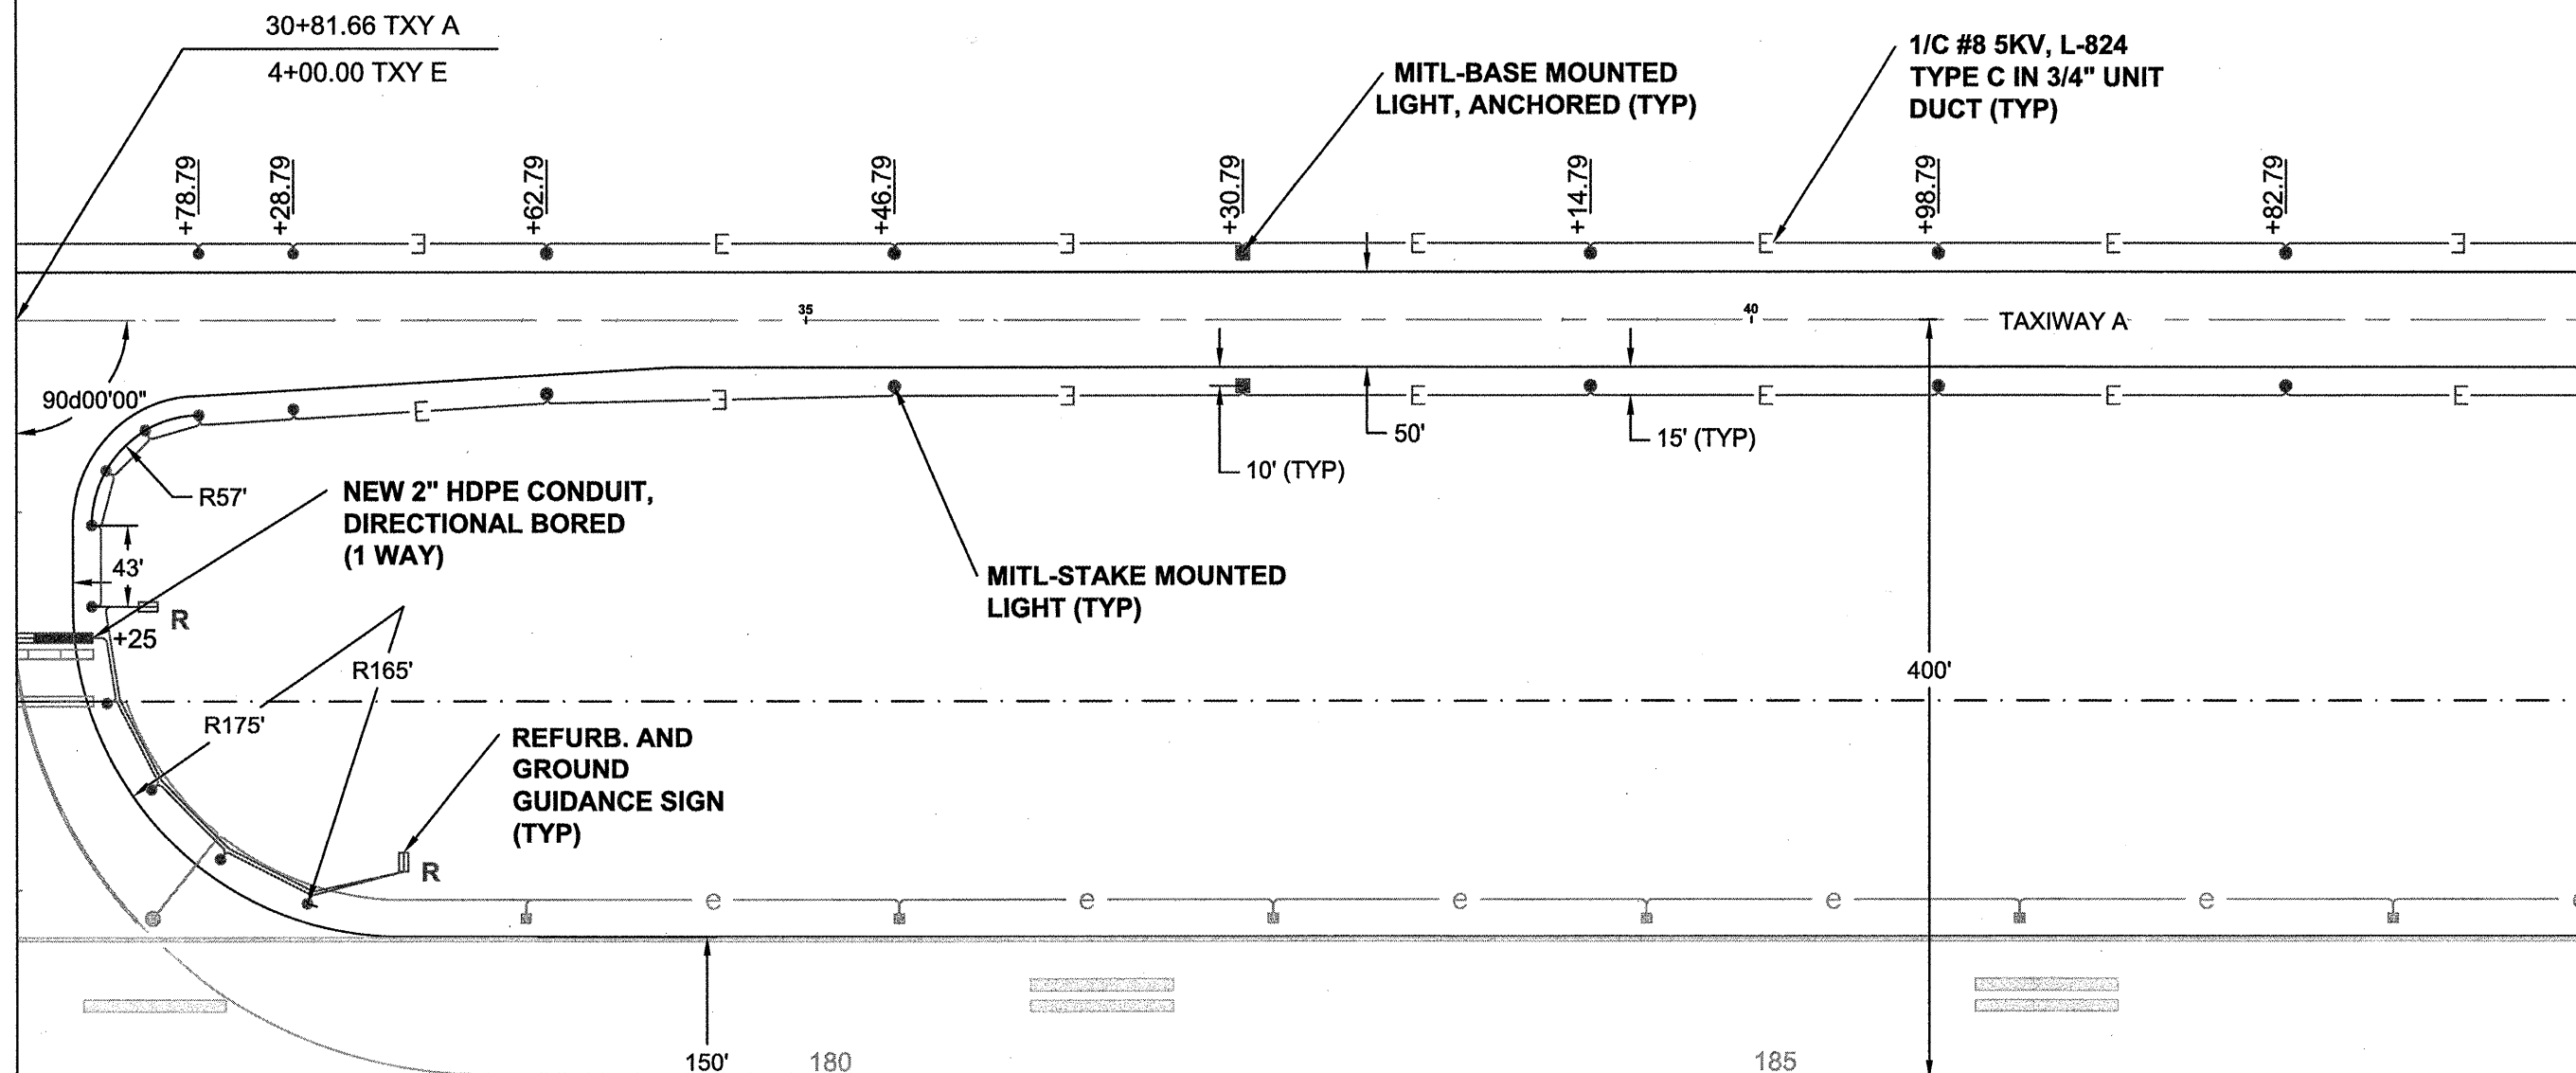

LEGEND

- E— NEW 1/C #8, L-824 TYPE C 5KV CABLE IN UNIT DUCT
- EXIST. 1/C 5KV CABLE
- NEW MITL - BASE MOUNTED LIGHT / ANCHORED
- NEW MITL - STAKE MOUNTED LIGHT
- R— EXIST. GUIDANCE SIGN TO BE REFURBISHED AND GROUNDED
- █— NEW DUCT (NO. OF WAYS SHOWN)
- ▤— EXIST. DUCT (NO. OF WAYS SHOWN)

**ELECTRICAL PLAN 3
TAXIWAY A**