

WH007



CRAWFORD, MURPHY & TILLY, INC.  
CONSULTING ENGINEERS  
© Copyright CMT, Inc.

Whiteside County **AIRPORT**  
JOSEPH H. BITTORF FIELD

Whiteside County  
Airport

Sterling / Rock Falls,  
Illinois

Whiteside County  
Airport

AIP: 3-17-0098-B14  
SQI-3830

REHABILITATE  
TAXIWAY EDGE  
LIGHTS (PARALLEL  
/ CONNECTING  
TAXIWAYS A AND E  
EAST OF RUNWAY  
18/36)

Revisions

No.	Date	Description



0 1  
THIS BAR IS EQUAL TO 1"  
AT FULL SCALE (17 X 11).

DESIGN BY: CMT- RFD  
DRAWN BY: CMT- RFD  
CHECKED BY: CMT- RFD  
APPROVED BY: JGP  
DATE: 7.25.2008  
JOB No: 08292-04-00

SITE PLAN  
(ETP4)

11

SHEET 11 OF 15 SHEETS

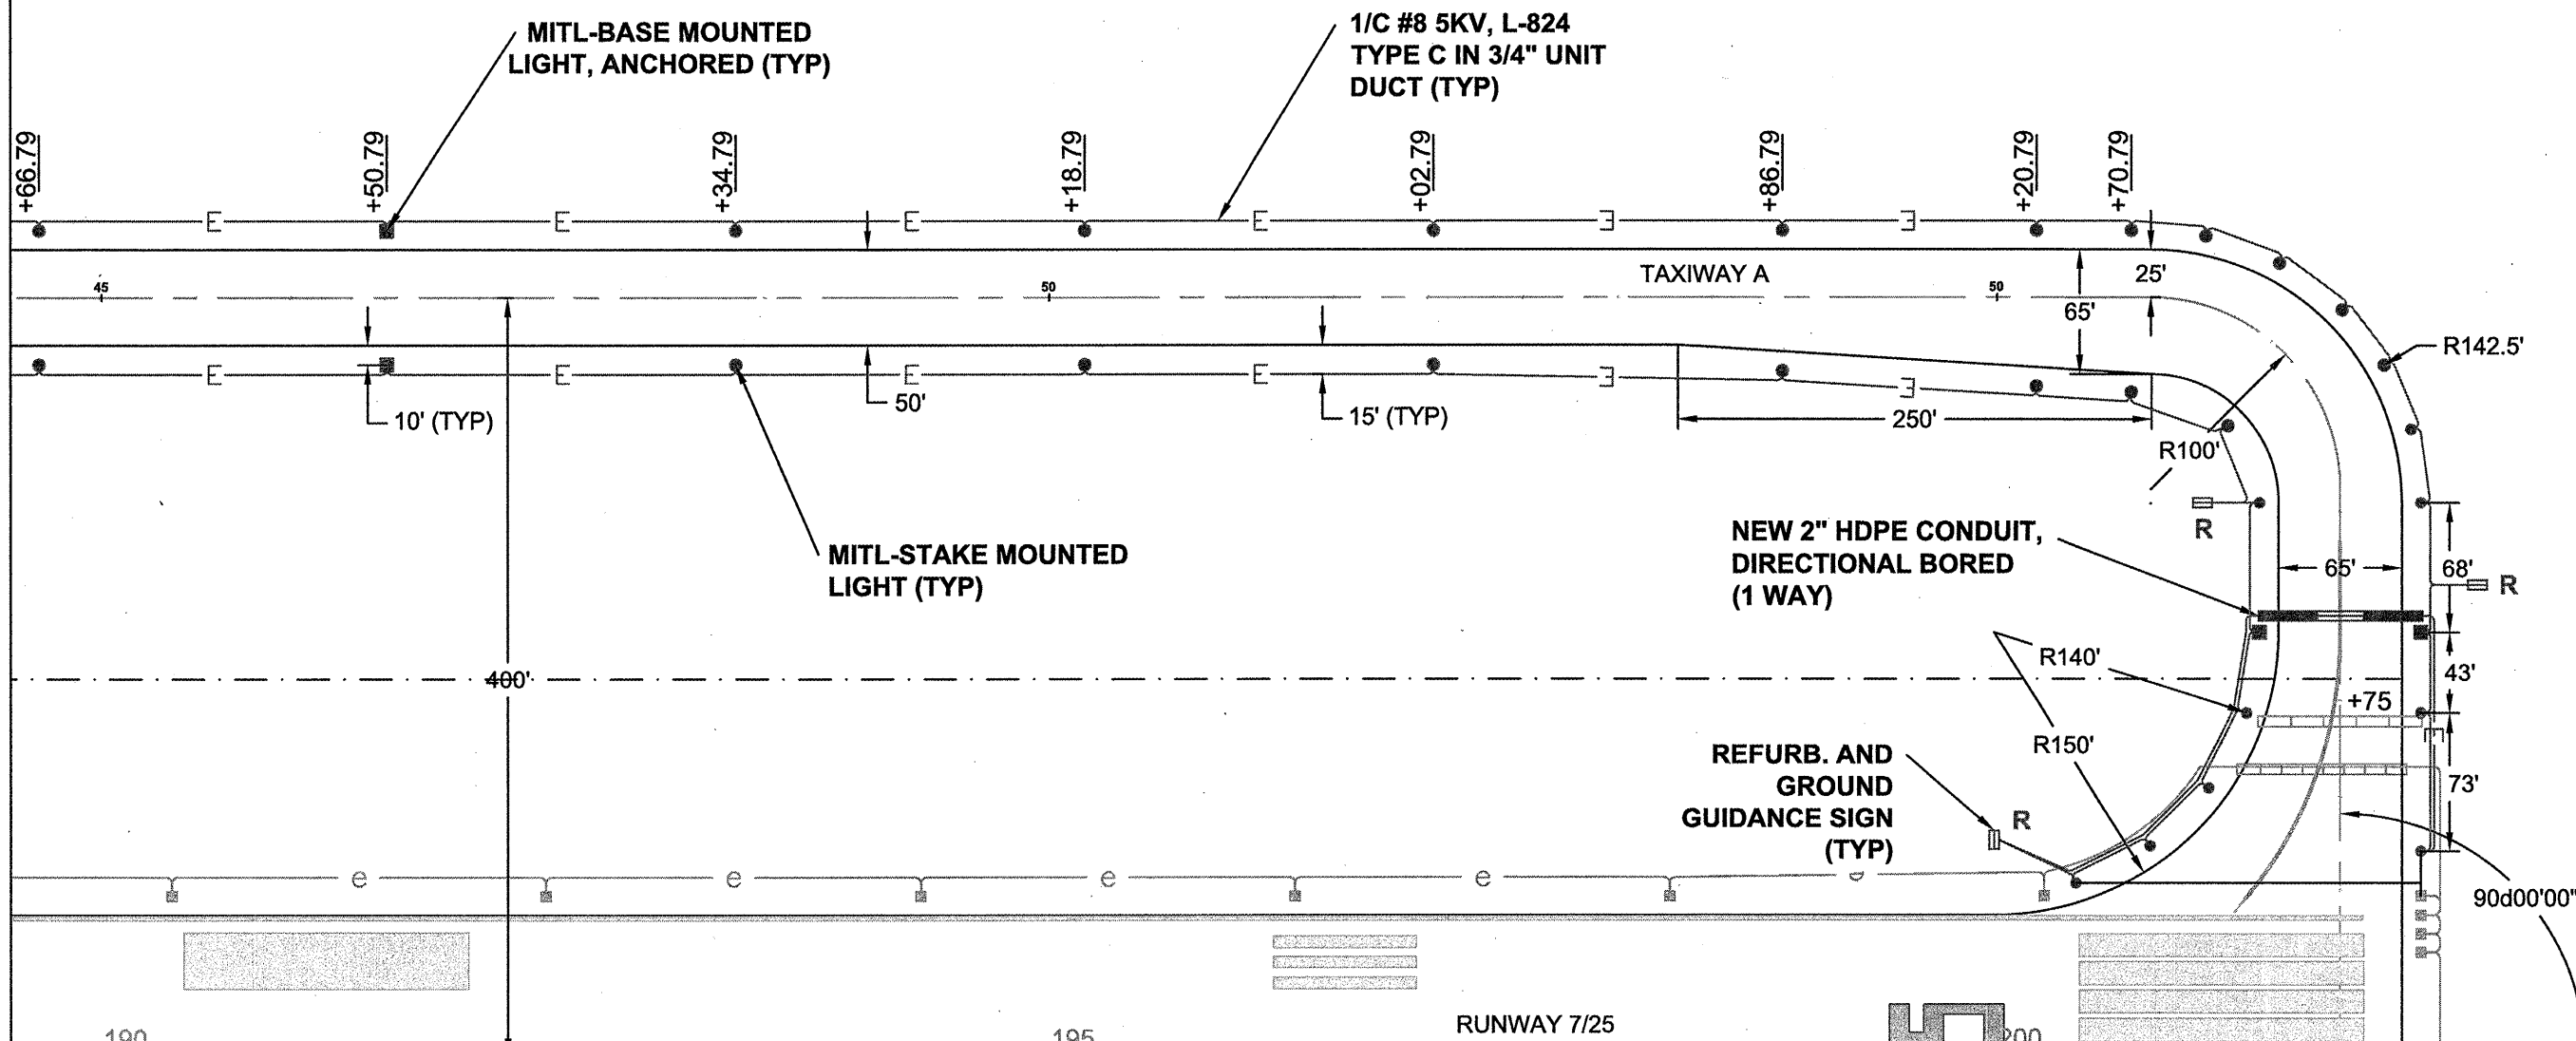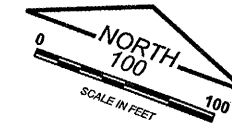

**LEGEND**

- |  |                                                 |  |                                                     |
|--|-------------------------------------------------|--|-----------------------------------------------------|
|  | NEW 1/C #8, L-824 TYPE C 5KV CABLE IN UNIT DUCT |  | NEW DUCT (NO. OF WAYS SHOWN)                        |
|  | EXIST. 1/C 5KV CABLE                            |  | EXIST. DUCT (NO. OF WAYS SHOWN)                     |
|  | NEW MITL - BASE MOUNTED LIGHT / ANCHORED        |  | NEW MITL - STAKE MOUNTED LIGHT                      |
|  |                                                 |  | EXIST. GUIDANCE SIGN TO BE REFURBISHED AND GROUNDED |

**ELECTRICAL PLAN 4  
TAXIWAY A**