
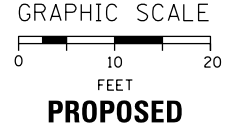
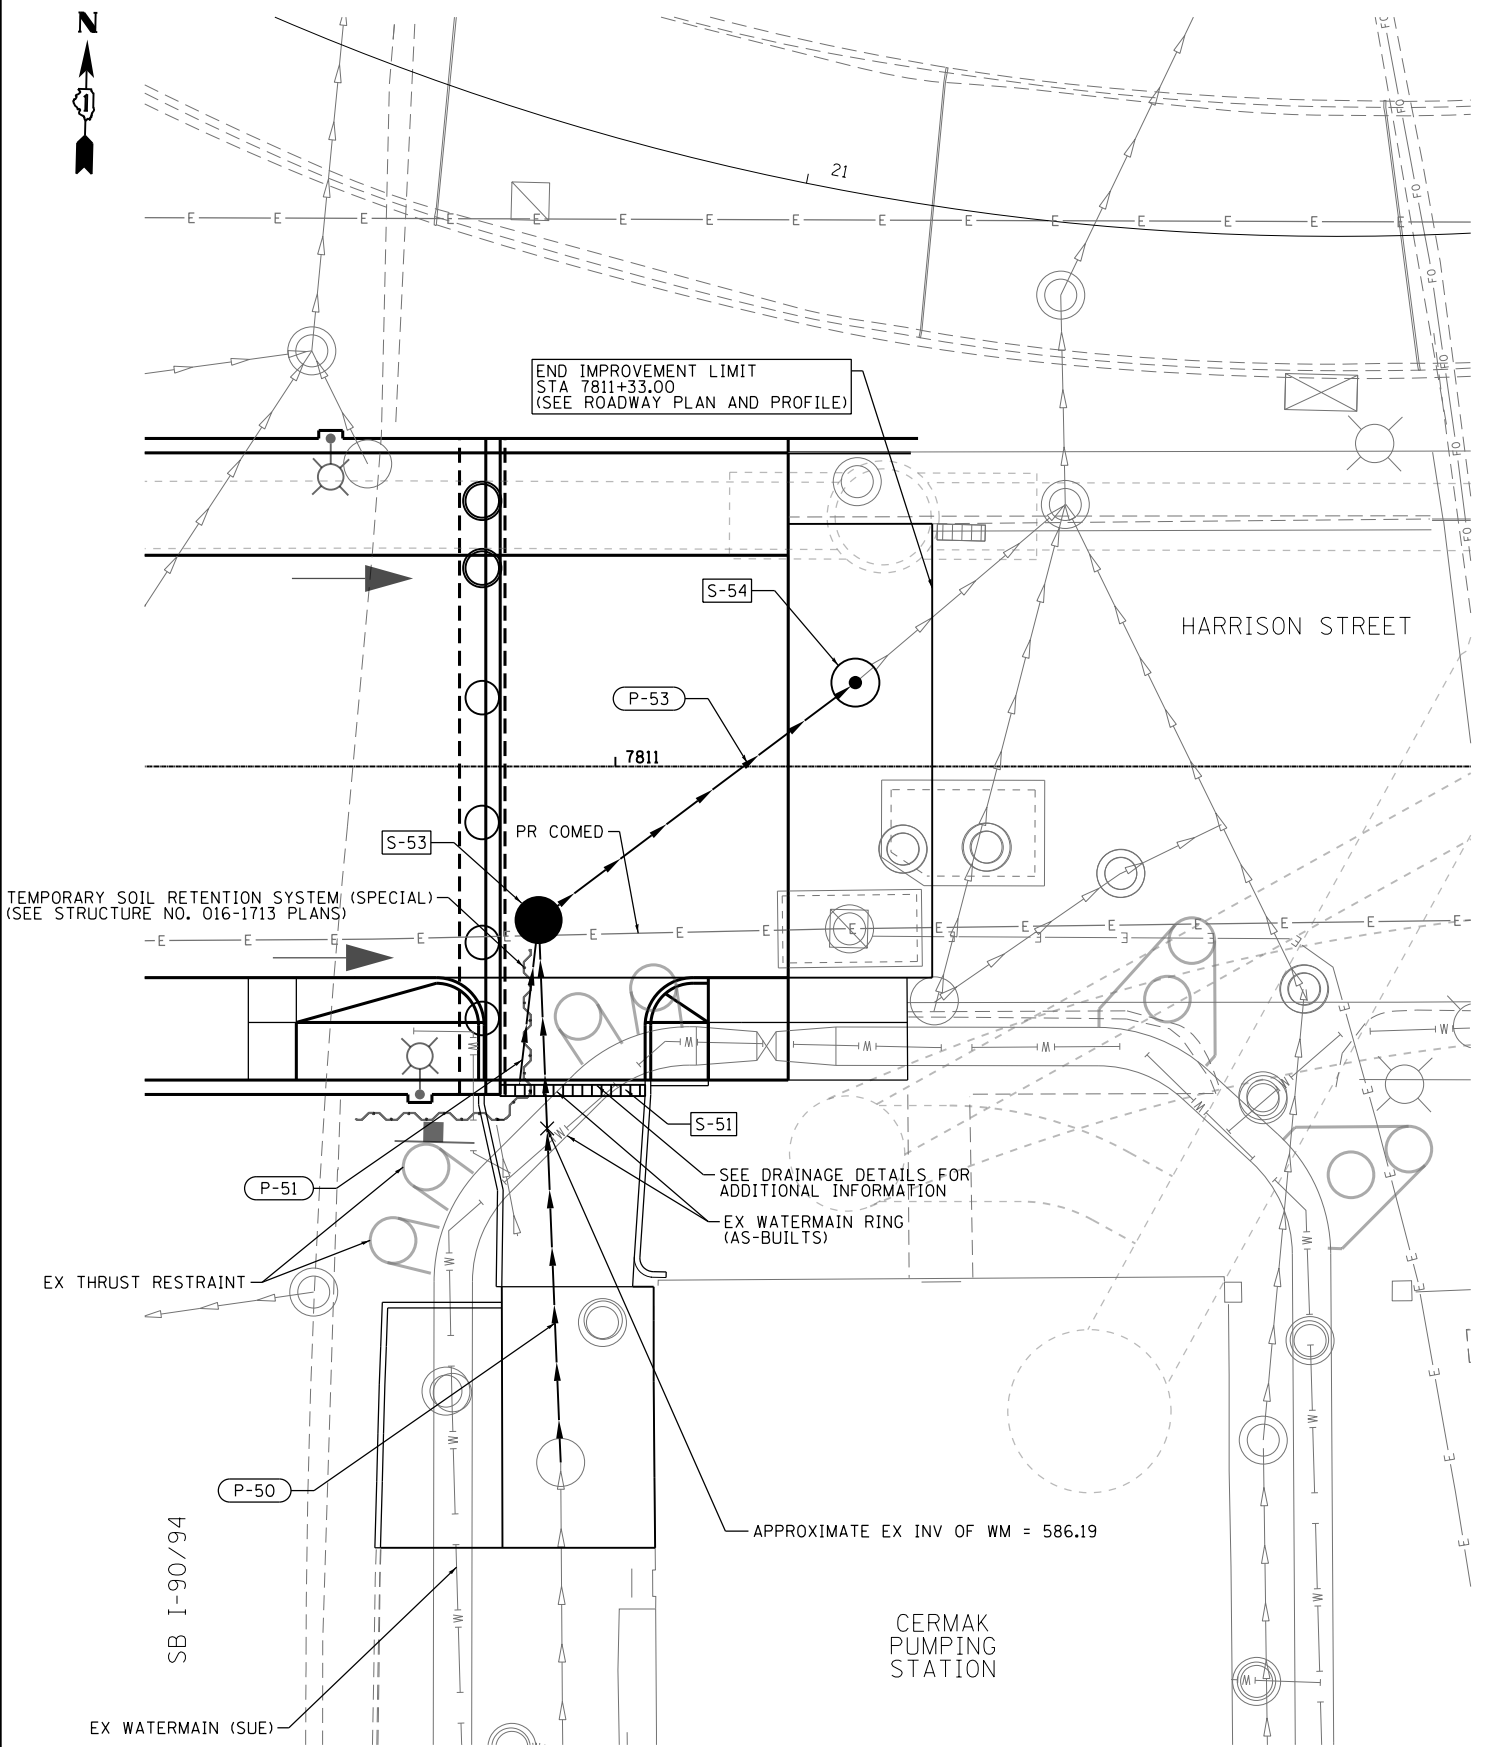
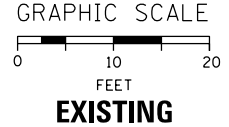


FILE PATH = p:\388035\part1\escomon\line\local\PAECD\00\Documents\01\_Americas\Transportation\62629938\_Circle\Phase\_1\000\_CAD\006\_Roadway\_Sheets\60W26-Contract\0160W26-sht-Drain-07

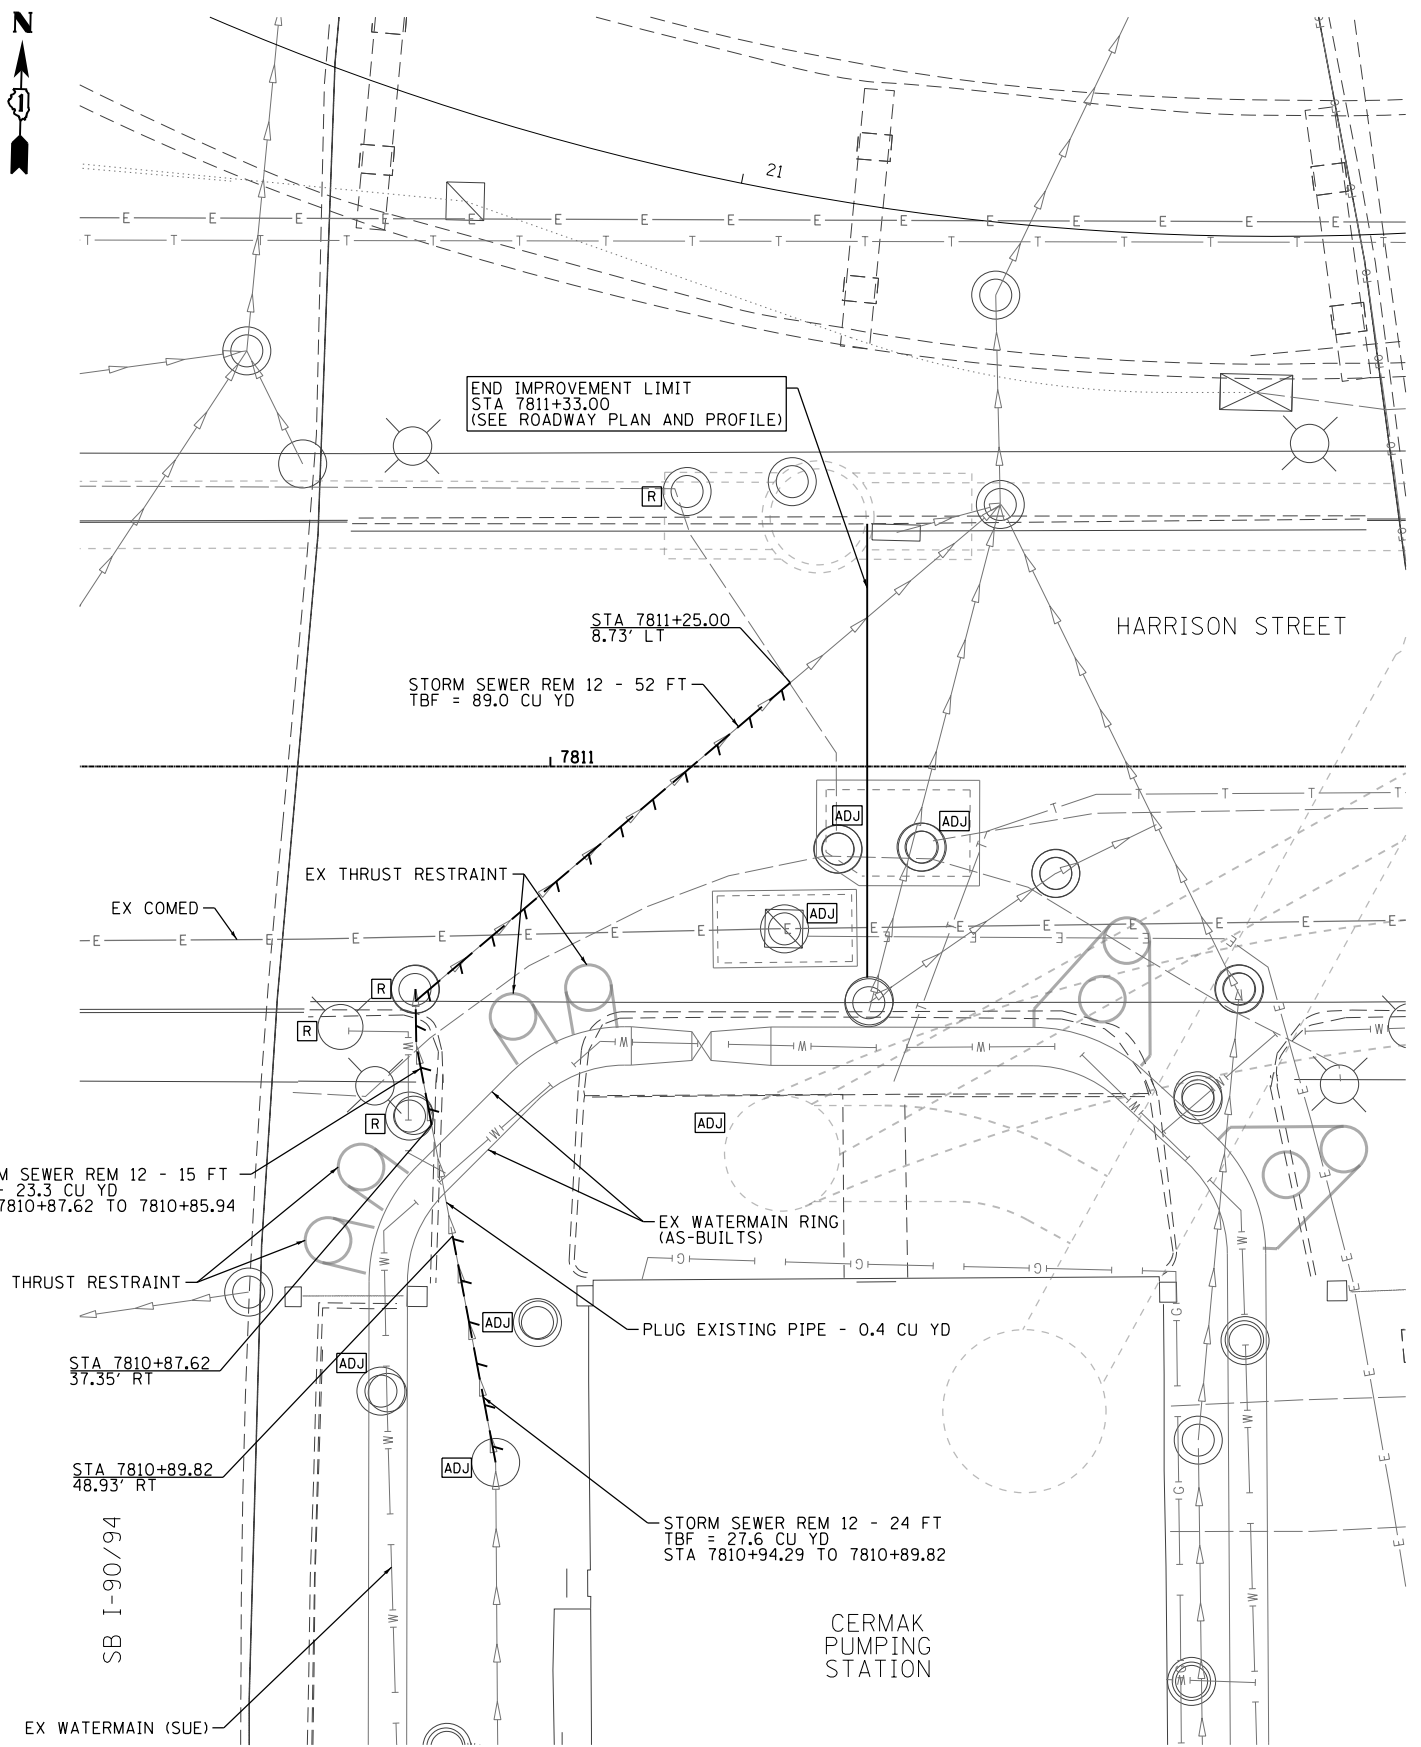

D160W26-sht-Drain-07  
 USER NAME = chitua  
 PLOT SCALE = 10.0000' / in.  
 PLOT DATE = 9/12/2013

DESIGNED - AFC  
 DRAWN - AFC  
 CHECKED - DBM  
 DATE - 9/15/13

**STATE OF ILLINOIS**  
**DEPARTMENT OF TRANSPORTATION**

**DRAINAGE AND UTILITY PLAN AND PROFILE**  
**CERMAK STREET PUMPING STATION**

SCALE: 1" = 10'    SHEET 7 OF 10 SHEETS    STA.    TO STA.

F.A.I. RTE.	SECTION	COUNTY	TOTAL SHEETS	SHEET NO.
90/94/290	2013-008R	COOK	559	136
CONTRACT NO. 60W26				
ILLINOIS FED. AID PROJECT				