



TYPICAL SPLICE DETAIL

N.T.S.

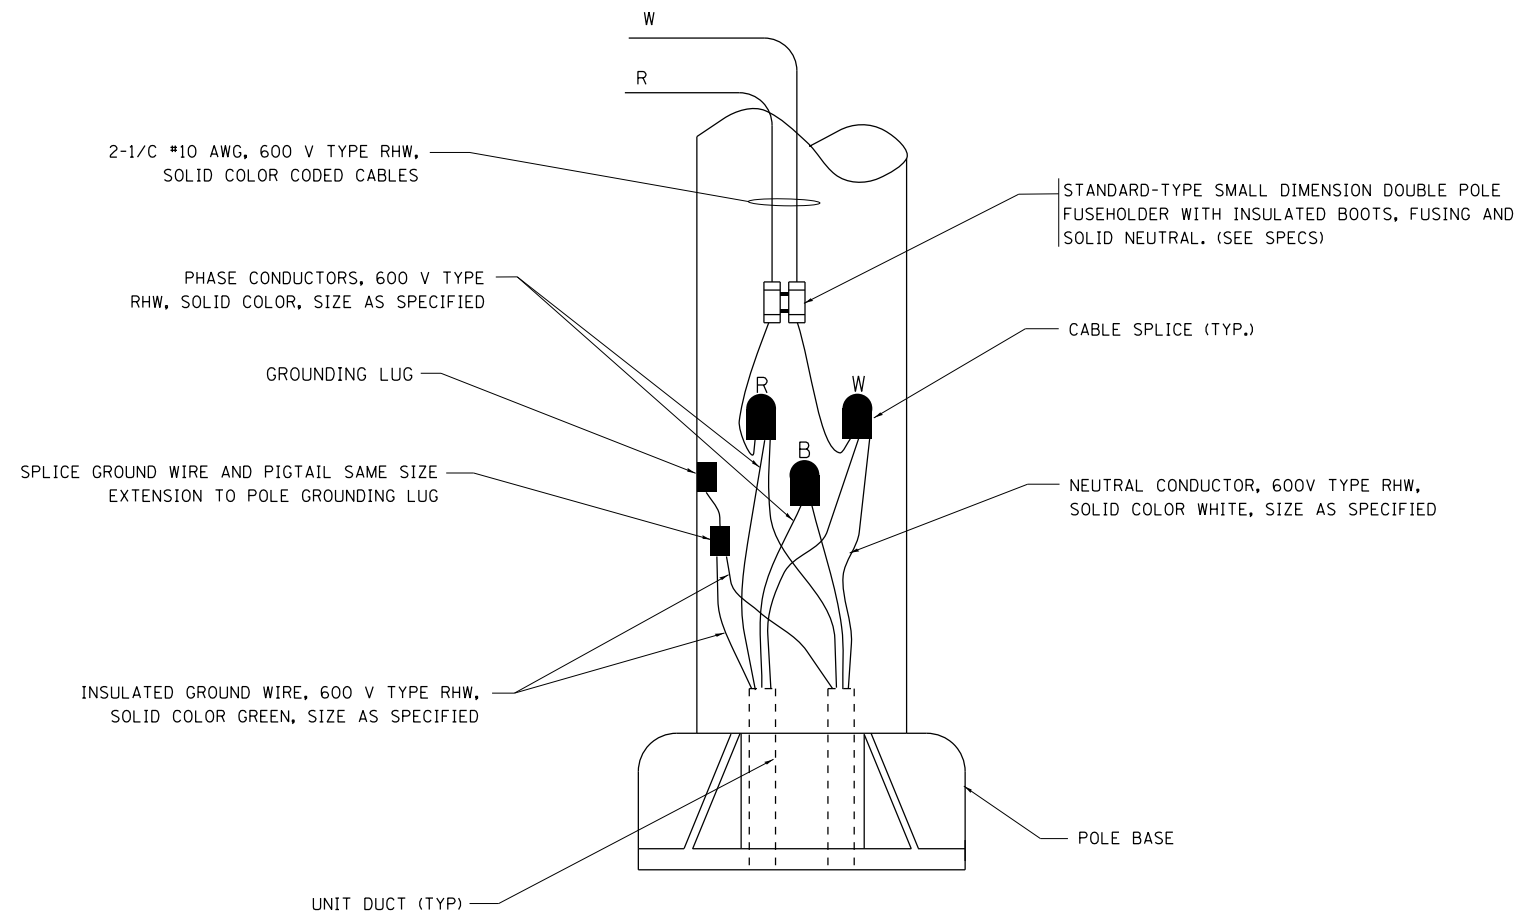

POLE WIRING DETAIL

N.T.S.

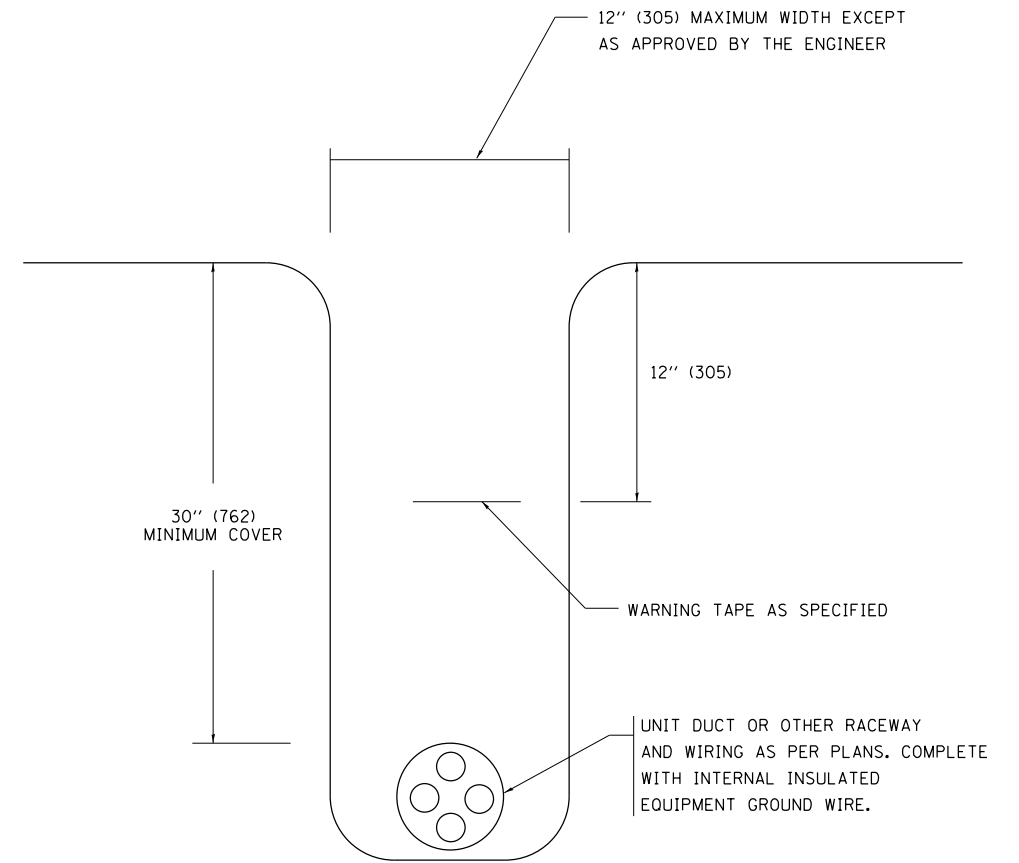

TYPICAL WIRING IN TRENCH DETAIL

N.T.S.

FILE NAME =	USER NAME = ougeungh	DESIGNED -	REVISED - 08-08-03
p:\388039-pwintl\ecomonline\local\pwae	C:\00\Documents\01 Americas\Transportation\0000\0000\CAD\006.Road\006W26.Contract\0160W26-SHT-DI	DRAWN -	CHECKED -
		PLLOT SCALE = 50.000' / in.	REVISIED -
		PLLOT DATE = 8/18/2013	REVISIED -

**STATE OF ILLINOIS
DEPARTMENT OF TRANSPORTATION**

**MISC. ELECTRICAL DETAILS
SHEET A**

SCALE: NONE SHEET NO. 9 OF 27 SHEETS STA. TO STA.

F.A.I. RTE.	SECTION	COUNTY	TOTAL SHEETS	SHEET NO.
*	2013-008R	COOK	559	469
BE-702		CONTRACT NO. 60W26		
FED. ROAD DIST. NO. 1 ILLINOIS FED. AID PROJECT				