


**LEGEND**  
 ■ TELEVISION INSPECTION OF SEWER

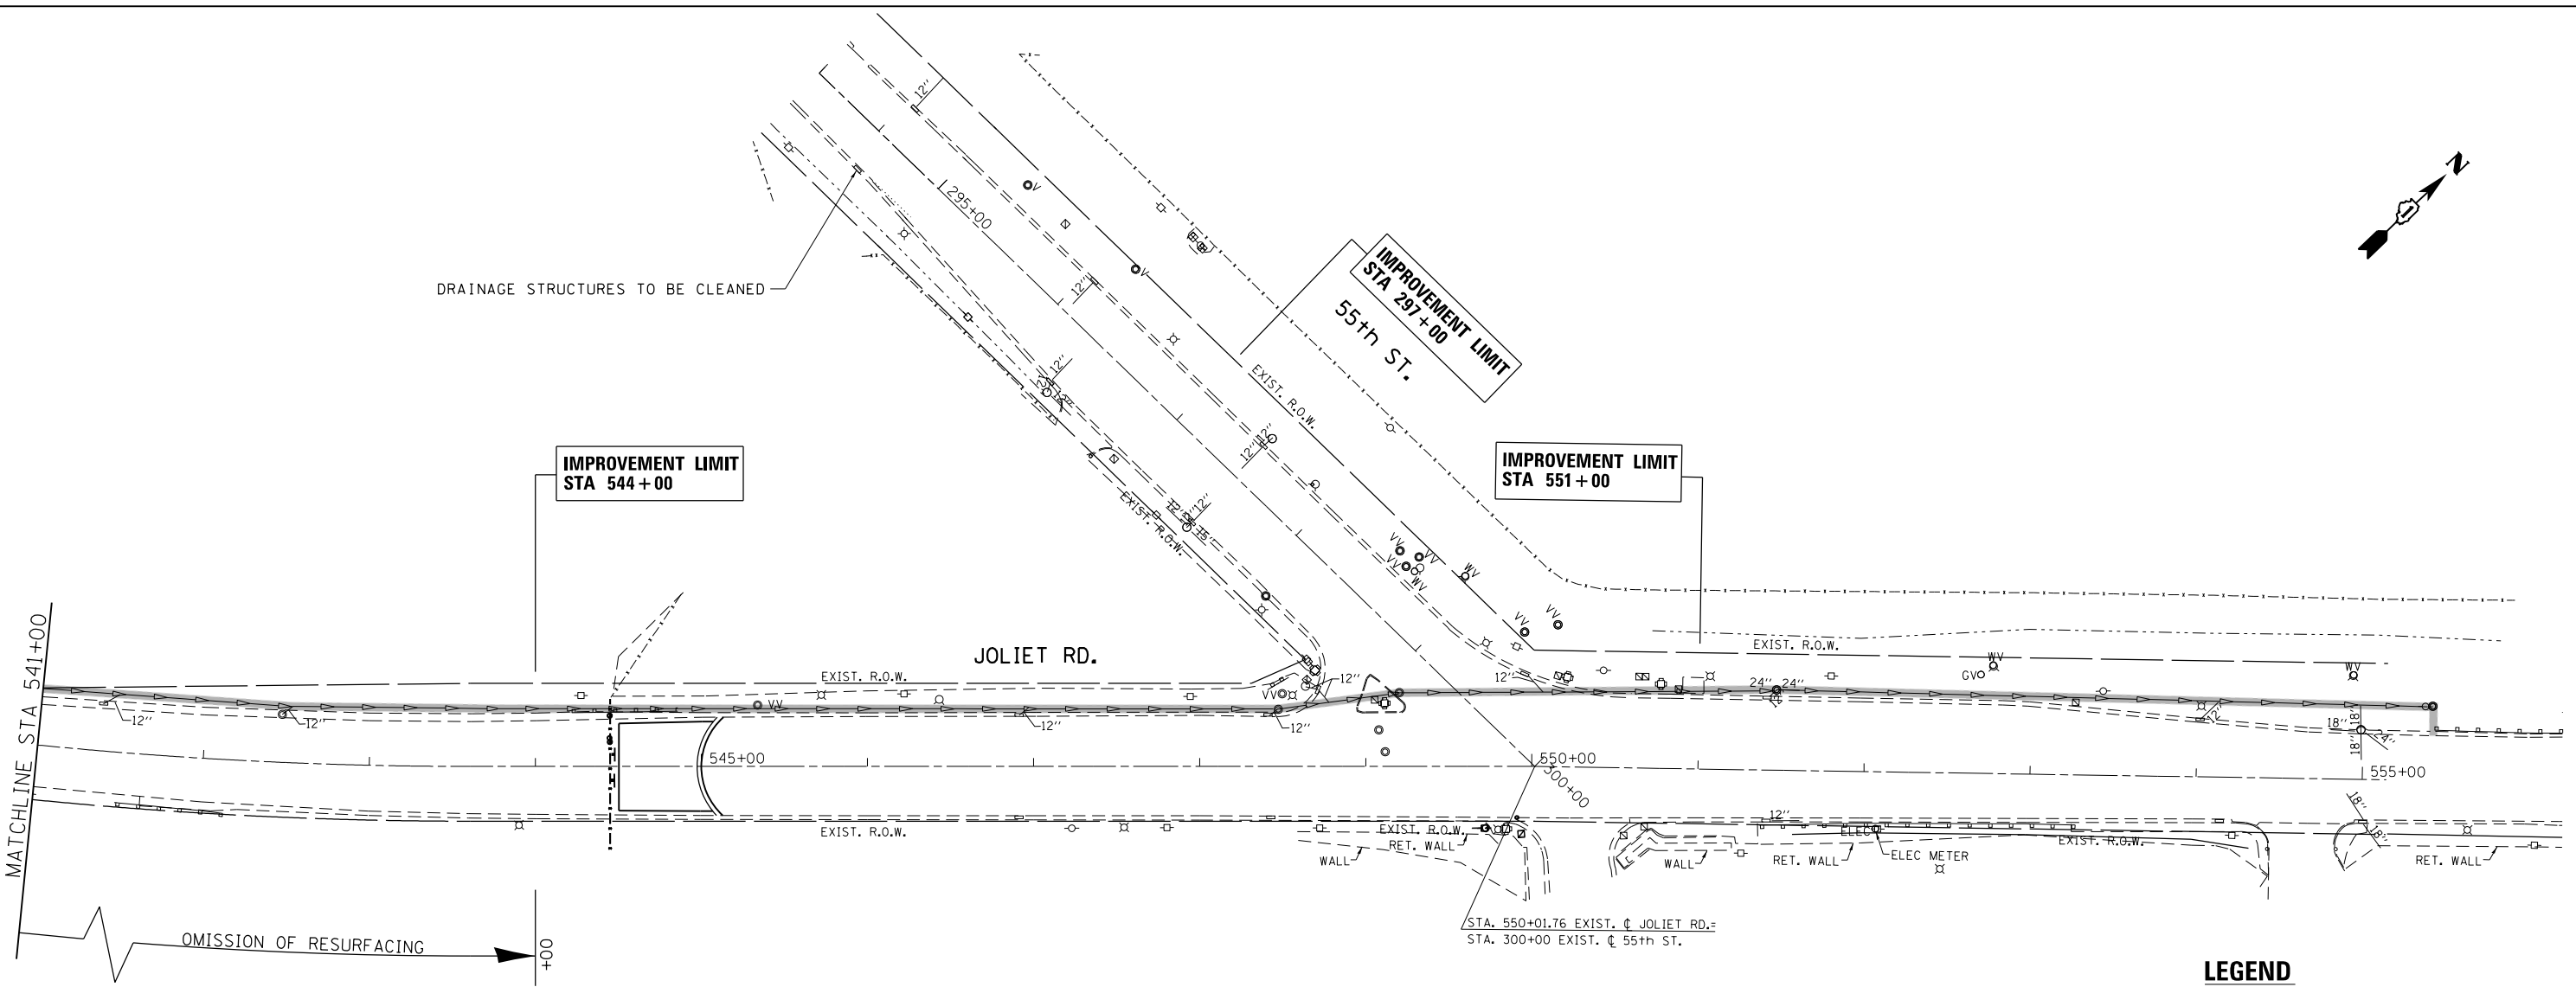

**LEGEND**  
 ■ TELEVISION INSPECTION OF SEWER

FILE NAME =	USER NAME = windot	DESIGNED -	REVISED -
ct:\pwwork\windot\windot\0254883\PI3591\shd-gennote.dgn		DRAWN -	REVISED -
	PLOT SCALE = 100.0026' / in.	CHECKED -	REVISED -
	PLOT DATE = 8/24/2012	DATE -	REVISED -

**STATE OF ILLINOIS  
 DEPARTMENT OF TRANSPORTATION**

**EXISTING AND PROPOSED DRAINAGE PLAN  
 JOLIET ROAD AT 55th STREET**

SCALE: 1"=50'    SHEET NO. 2 OF 2 SHEETS    STA. 526+00.00 TO STA. 555+00.00

F.A.U. RTE.	SECTION	COUNTY	TOTAL SHEETS	SHEET NO.
3562	430Y-N	COOK	12	10
CONTRACT NO. 60T48				
ILLINOIS FED. AID PROJECT				