


PLAN	SUBMITTED	BY	DATE
NOTE BOOK NO.	ALIGNMENT CHECKED		
	CARD FILE NAME		

PROFILE	SURVEY	DATE
NOTE BOOK NO.	GRABS CHECKED	
	STRUCTURE NOTATIONS	

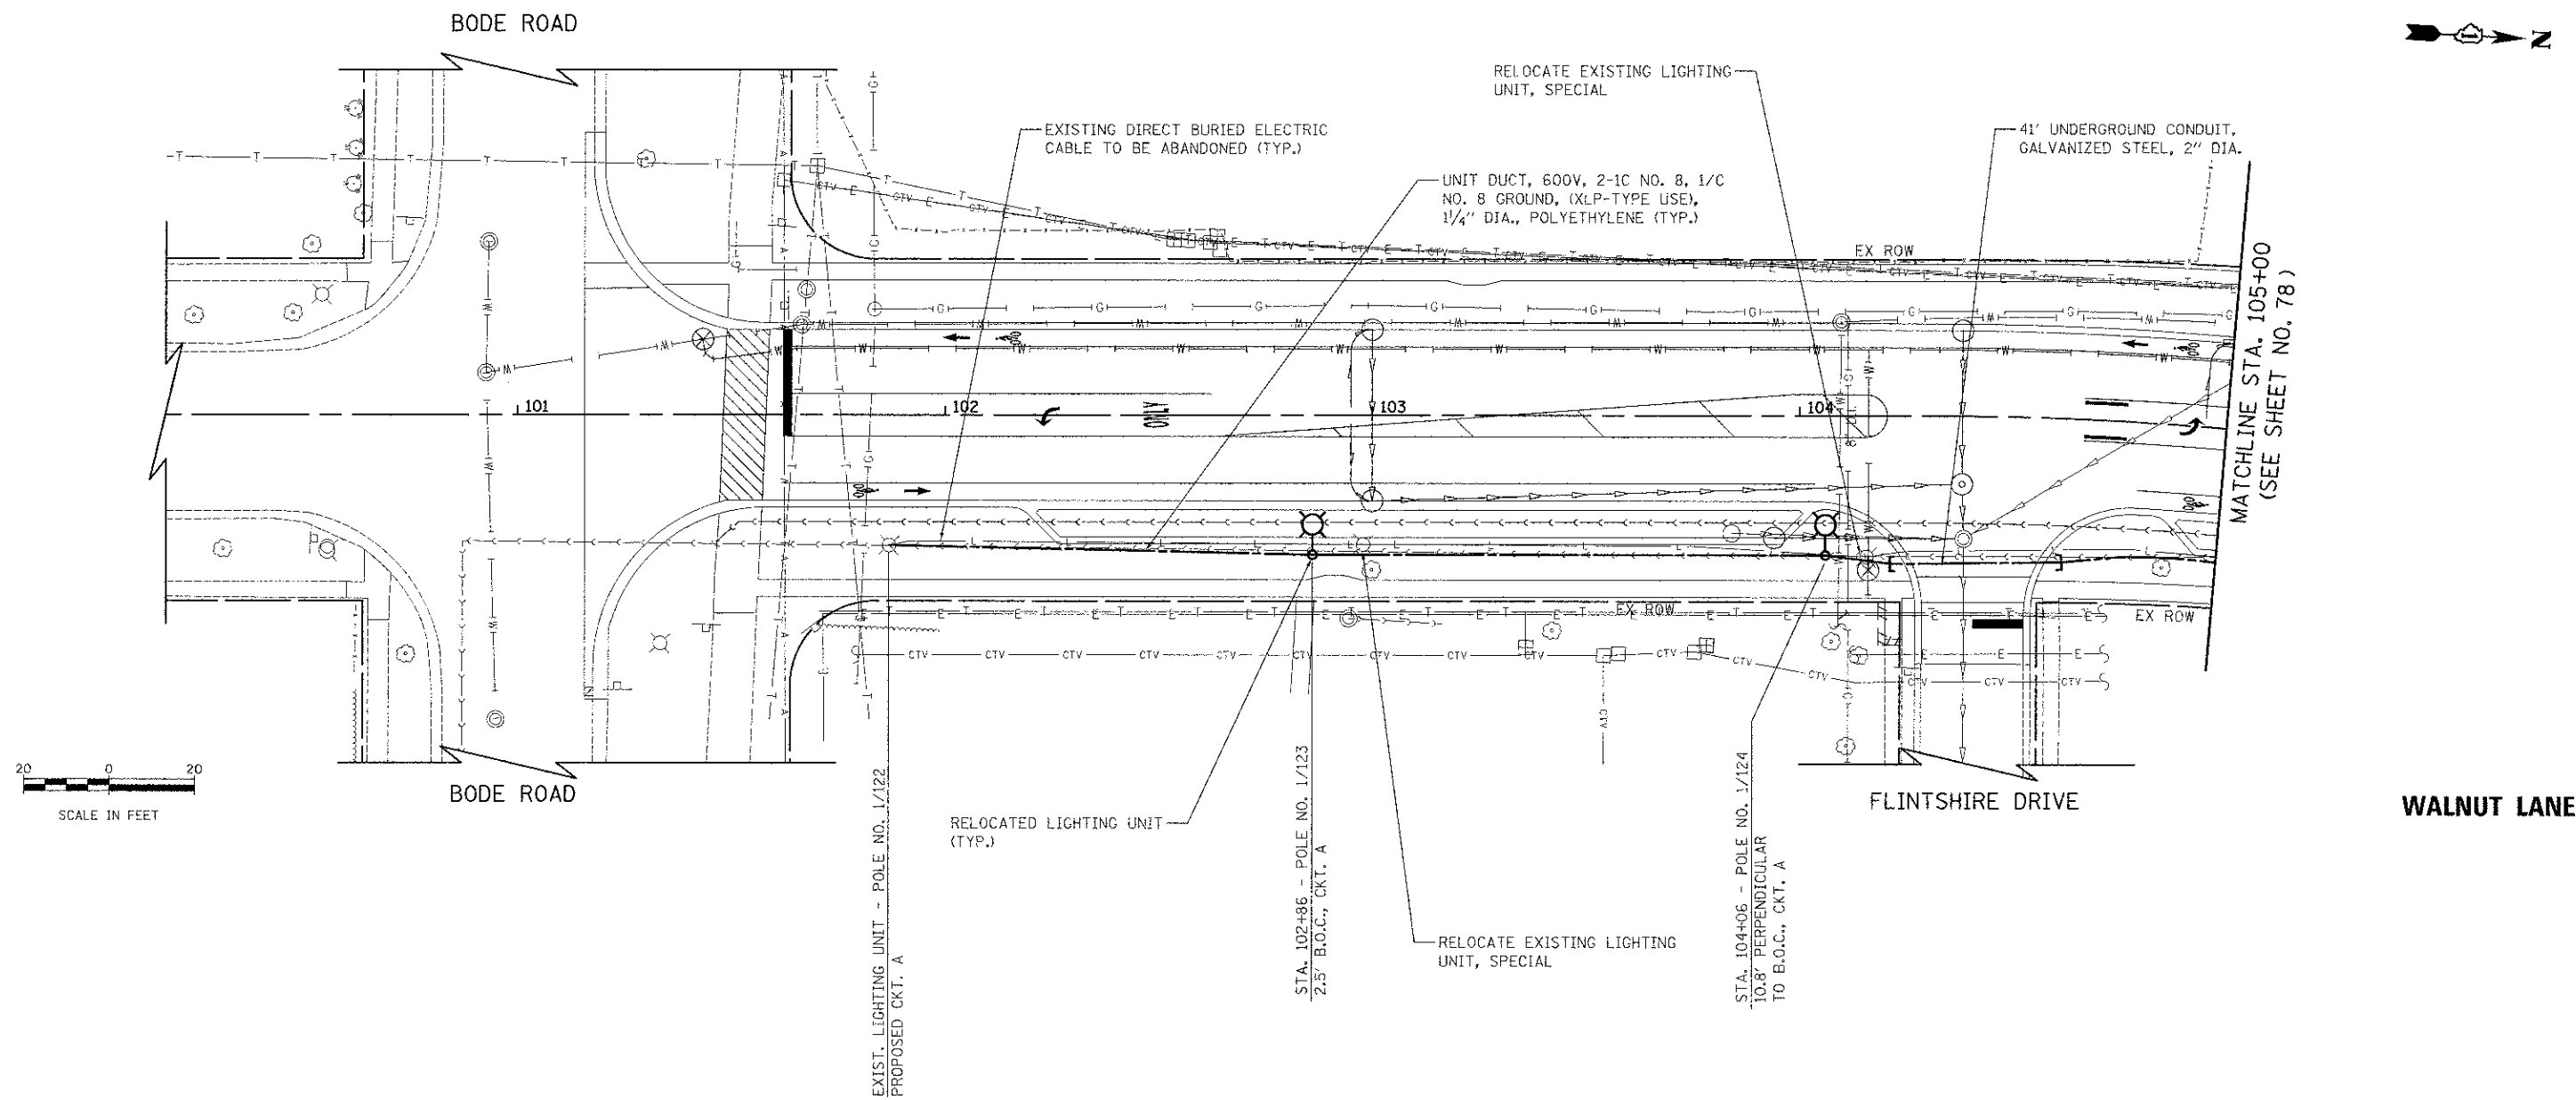

FILE NAME = ...\\16-Lighting\2536-LT_PP_01.dgn

USER NAME = djk
 PLOT SCALE = 20,000 / in.
 PLOT DATE = *DATE*

DESIGNED - JSM
 DRAWN - JSM
 CHECKED - DJK
 DATE - 8/15/2012

REVISED -
 REVISED -
 REVISED -
 REVISED -

**STATE OF ILLINOIS
 DEPARTMENT OF TRANSPORTATION**

**WALNUT LANE
 LIGHTING PLAN**
 SCALE: 1" = 20' SHEET NO. 1 OF 6 SHEETS STA. 101+15.67 TO STA. 105+00.00

F.A.U. RTE.	SECTION	COUNTY	TOTAL SHEETS	SHEET NO.
2556	08-00094-00-PV	COOK	113	77
CONTRACT NO. 63738				
ILLINOIS FED. AID PROJECT W-5003(494)				