 



PLAN	DESIGNED	BY	DATE
NOTE BOOK	ALIGNED		
NO.	FILE NAME		

PROFILE	DESIGNED	BY	DATE
NOTE BOOK	CHECKED		
NO.	STRUCTURE		

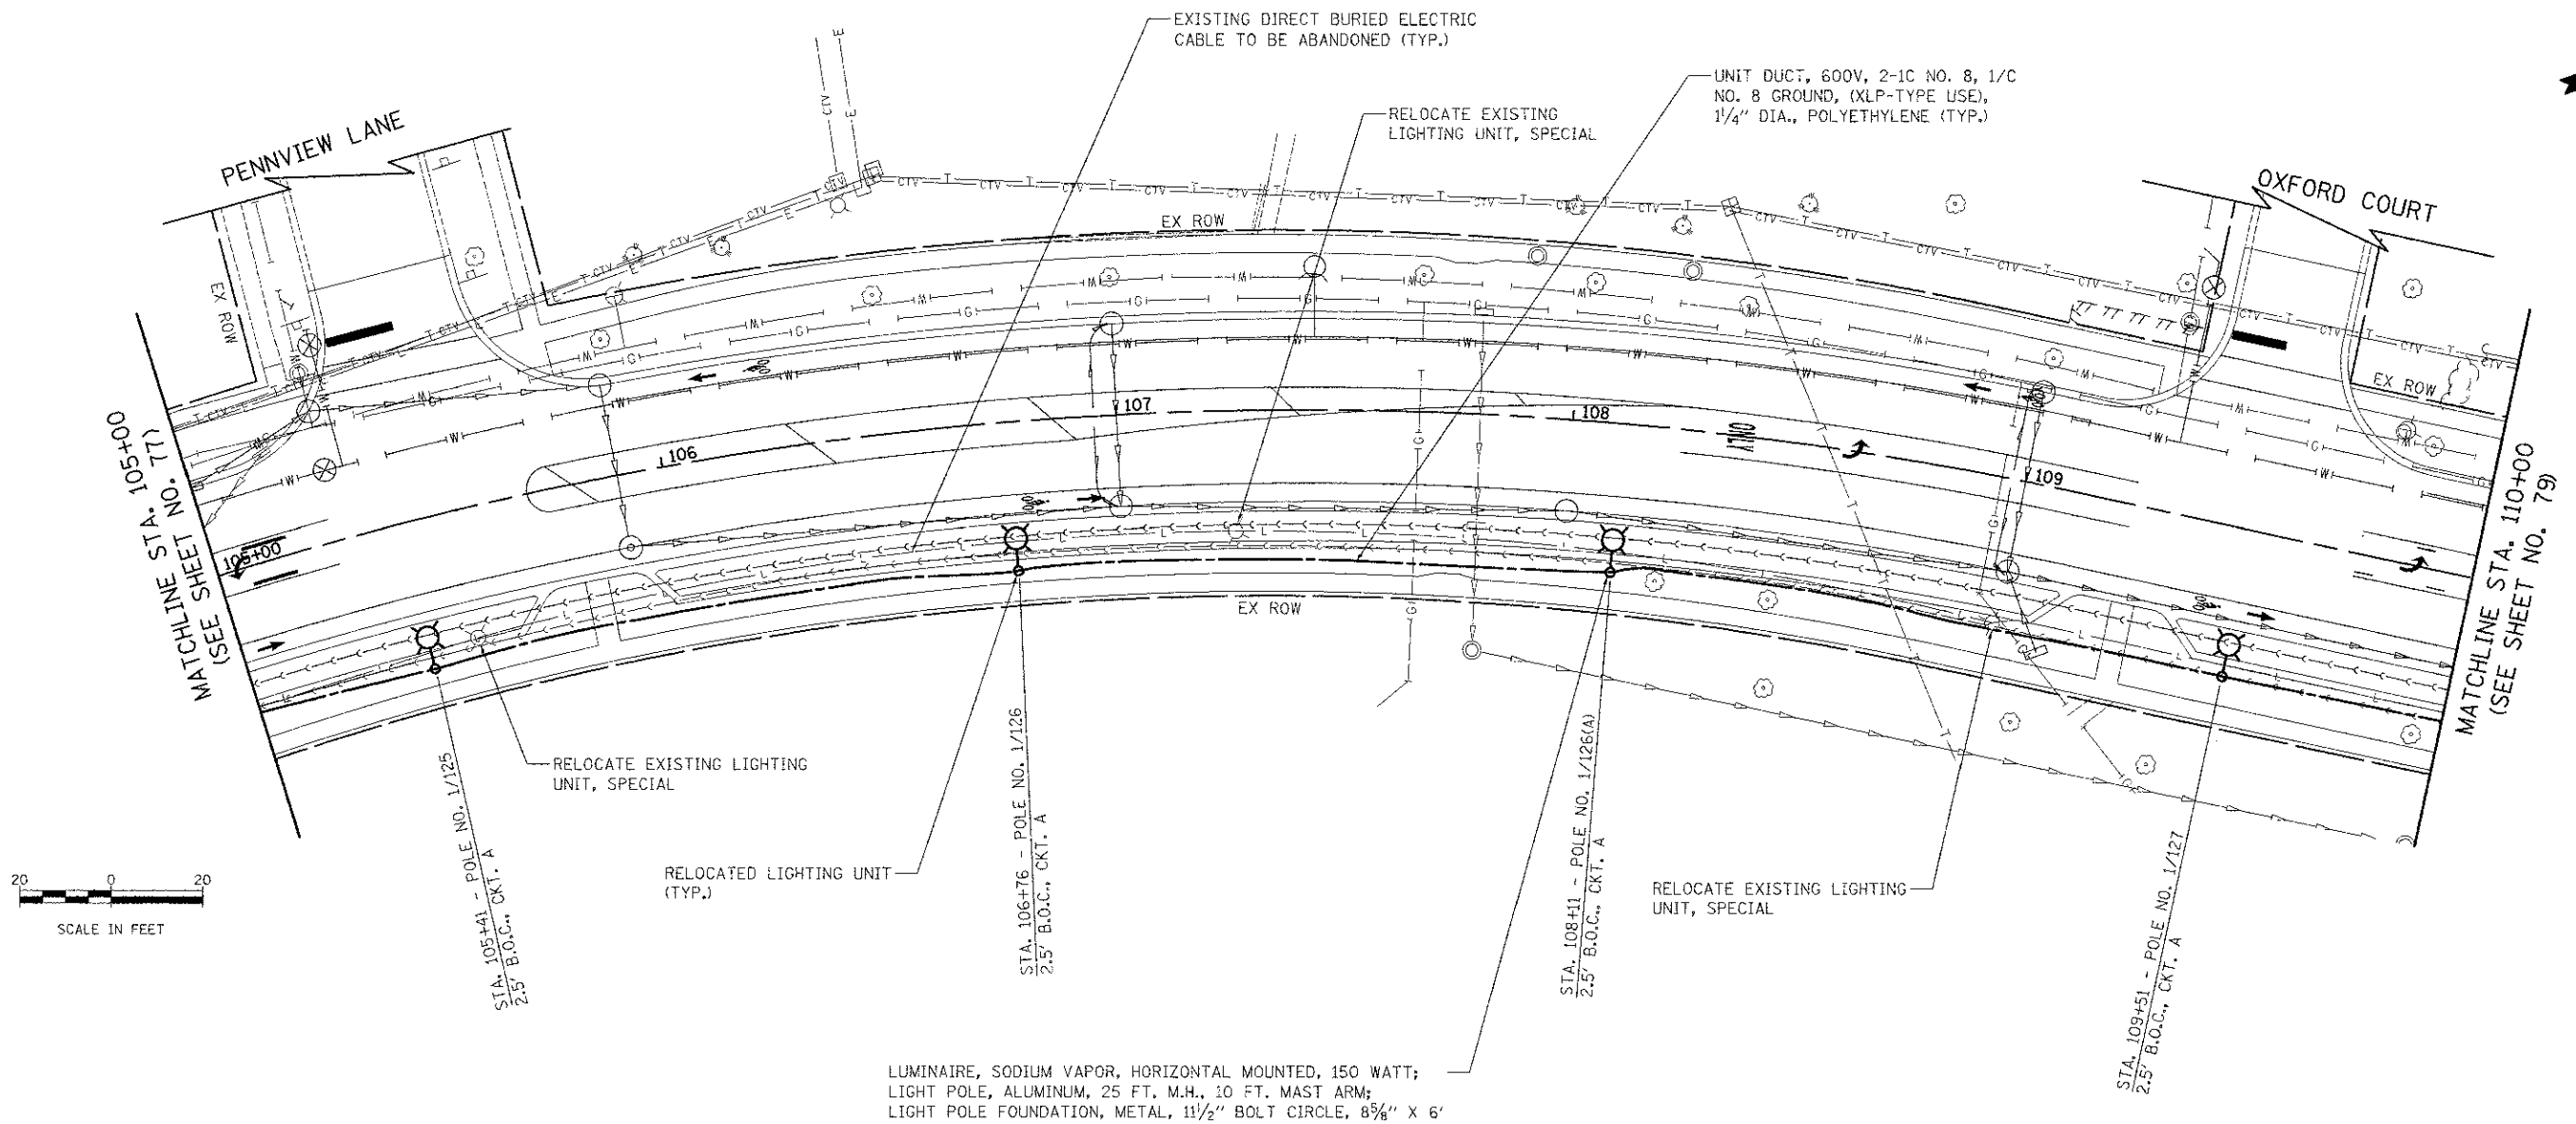

LUMINAIRE, SODIUM VAPOR, HORIZONTAL MOUNTED, 150 WATT;
 LIGHT POLE, ALUMINUM, 25 FT. M.H., 10 FT. MAST ARM;
 LIGHT POLE FOUNDATION, METAL, 1 1/2" BOLT CIRCLE, 8 5/8" X 6"

FILE NAME = ...\\6-Lighting\2536-LT_PP_32.dgn	USER NAME = djjk	DESIGNED - JSM	REVISED -	STATE OF ILLINOIS DEPARTMENT OF TRANSPORTATION	WALNUT LANE LIGHTING PLAN		F.A.J. RTE. 2556	SECTION 08-00094-00-PV	COUNTY COOK	TOTAL SHEETS 113	SHEET NO. 78	
PLOT SCALE = 20.0000 1/16"	CHECKED - DJK	REVISED -	REVISED -		SCALE: 1" = 20'	SHEET NO. 2 OF 6 SHEETS	STA. 105+00.00 TO STA. 110+00.00	CONTRACT NO. 63738				
PLOT DATE = #DATE#	DATE = 8/15/2012	REVISED -	REVISED -		ILLINOIS FED. AID PROJECT M-9003(494)							