



PLAN	SURVEYED	DATE
	PLOTTED	BY
	CHECKED	NO.
	ATTEMPTED	
	FILE NAME	

PROFILE	SURVEYED	DATE
	PLOTTED	BY
	CHECKED	NO.
	STRUCTURE	
	NOTATION	

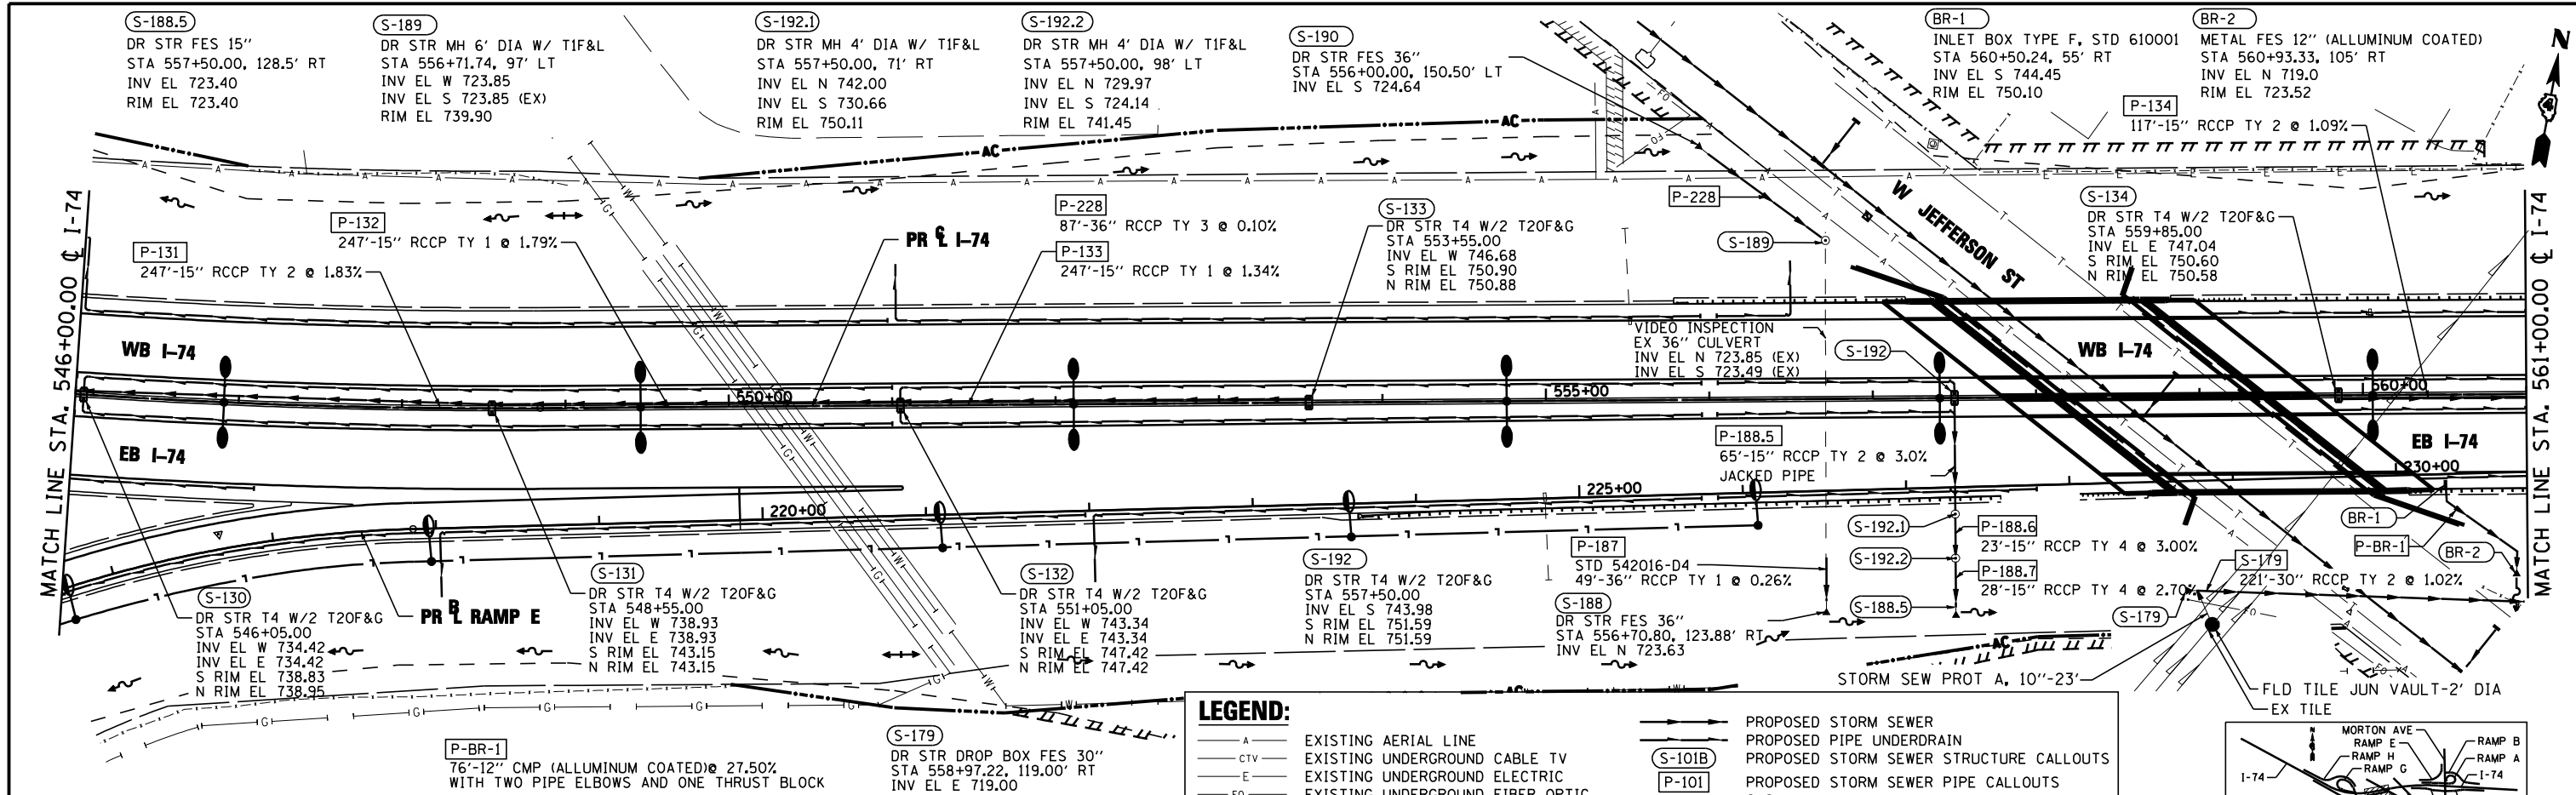

LEGEND:

- A - EXISTING AERIAL LINE
- E - EXISTING UNDERGROUND CABLE TV
- E - EXISTING UNDERGROUND ELECTRIC
- FO - EXISTING UNDERGROUND FIBER OPTIC
- G - EXISTING UNDERGROUND GAS LINE
- T - EXISTING UNDERGROUND SANITARY SEWER
- T - EXISTING UNDERGROUND TELEPHONE
- W - EXISTING UNDERGROUND WATER
- - - - - PROPOSED STORM SEWER
- - - - - PROPOSED PIPE UNDERDRAIN
- - - - - PROPOSED STORM SEWER STRUCTURE CALLOUTS
- - - - - PROPOSED STORM SEWER PIPE CALLOUTS
- - - - - SAG
- - - - - SUMMIT
- - - - - DITCH
- - - - - SWALE
- - - - - MANHOLE

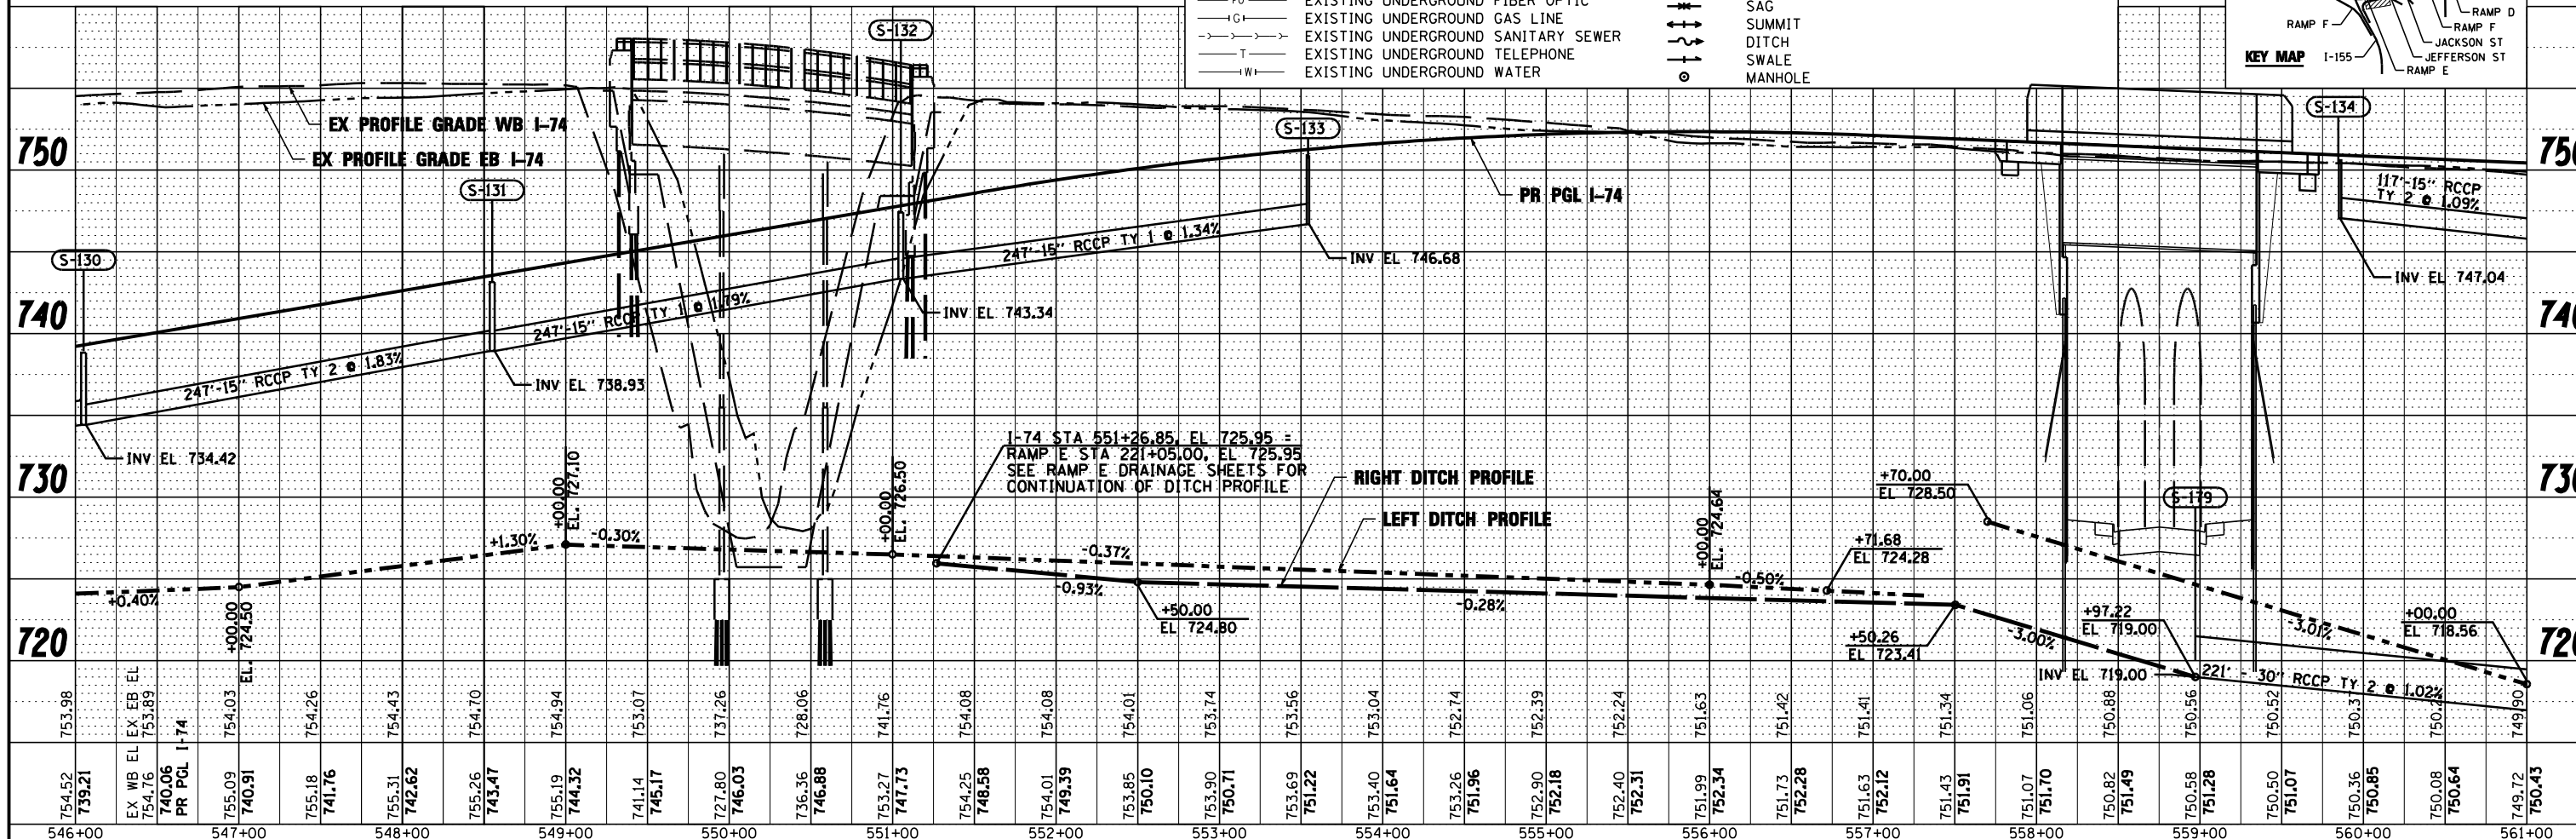

FILE NAME =	DESIGNED - EJA	REVISED -		STATE OF ILLINOIS DEPARTMENT OF TRANSPORTATION	DRAINAGE AND UTILITY PLAN AND PROFILE I-74	SECTION COUNTY TAZEWELL CONTRACT NO. 68620	TOTAL SHEETS 2433 SHEET NO. 1420
...D468620-sht-1-74-drain07.dgn	DRAWN - TMB	REVISED -					
USER NAME = toddbenk	CHECKED - JNR	REVISED -					
PLOT DATE = 7/18/2012	DATE - JULY 20, 2012	REVISED -					

SCALE: 1"=50' SHEET NO. 7 OF 13 SHEETS STA. 546+00.00 TO STA. 561+00.00