




PLAN	SURVEYED	DATE
	PLOTTED	BY
	CHECKED	
	ALIGNED	
	MAX	
	CADD FILE NAME	
	NO.	

PROFILE	SURVEYED	DATE
	PLOTTED	BY
	CHECKED	
	GRADES	
	STRUCTURE	
	NOTATIS	
	CHFD	
	NO.	

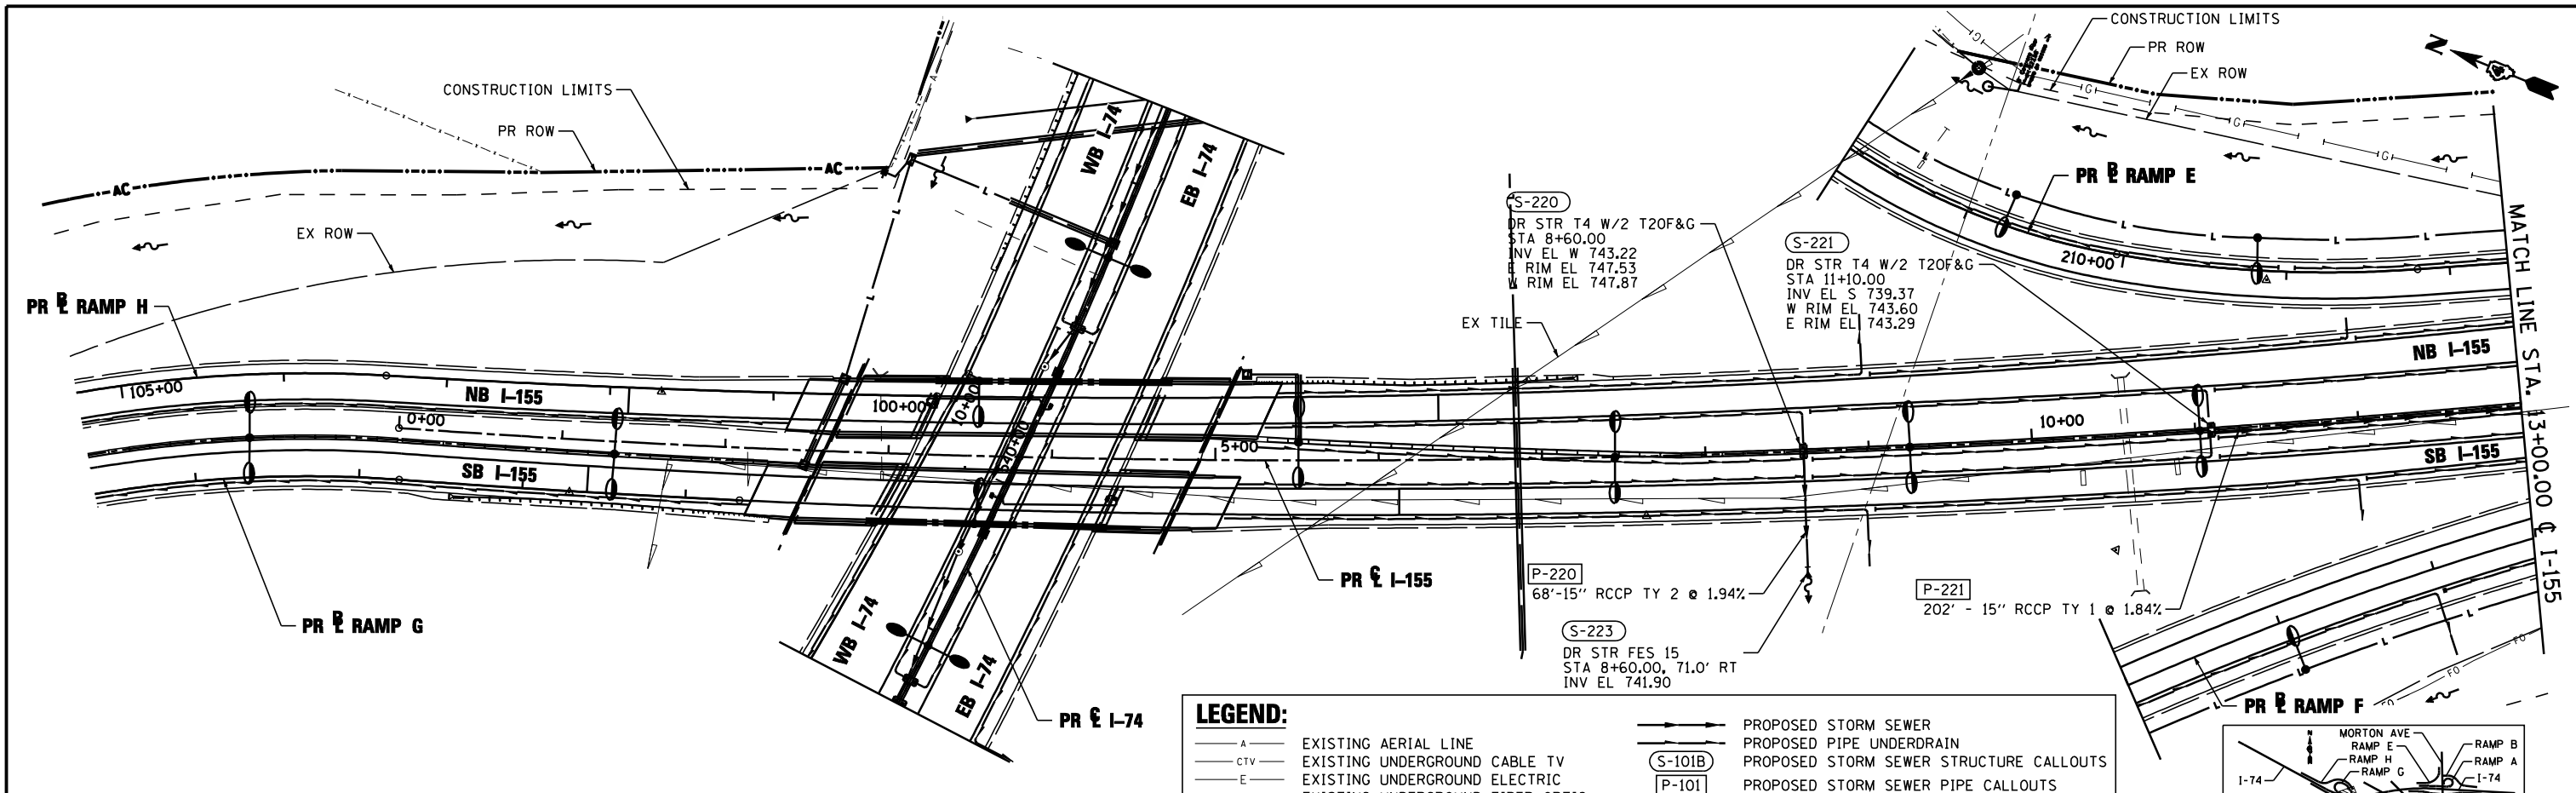

LEGEND:

- A — EXISTING AERIAL LINE
- CTV — EXISTING UNDERGROUND CABLE TV
- E — EXISTING UNDERGROUND ELECTRIC
- FO — EXISTING UNDERGROUND FIBER OPTIC
- IG — EXISTING UNDERGROUND GAS LINE
- T — EXISTING UNDERGROUND SANITARY SEWER
- W — EXISTING UNDERGROUND TELEPHONE
- W — EXISTING UNDERGROUND WATER
- — PROPOSED STORM SEWER
- — PROPOSED PIPE UNDERDRAIN
- (S-101B) — PROPOSED STORM SEWER STRUCTURE CALLOUTS
- (P-101) — PROPOSED STORM SEWER PIPE CALLOUTS
- — SAG
- — SUMMIT
- — DITCH
- — SWALE
- — MANHOLE

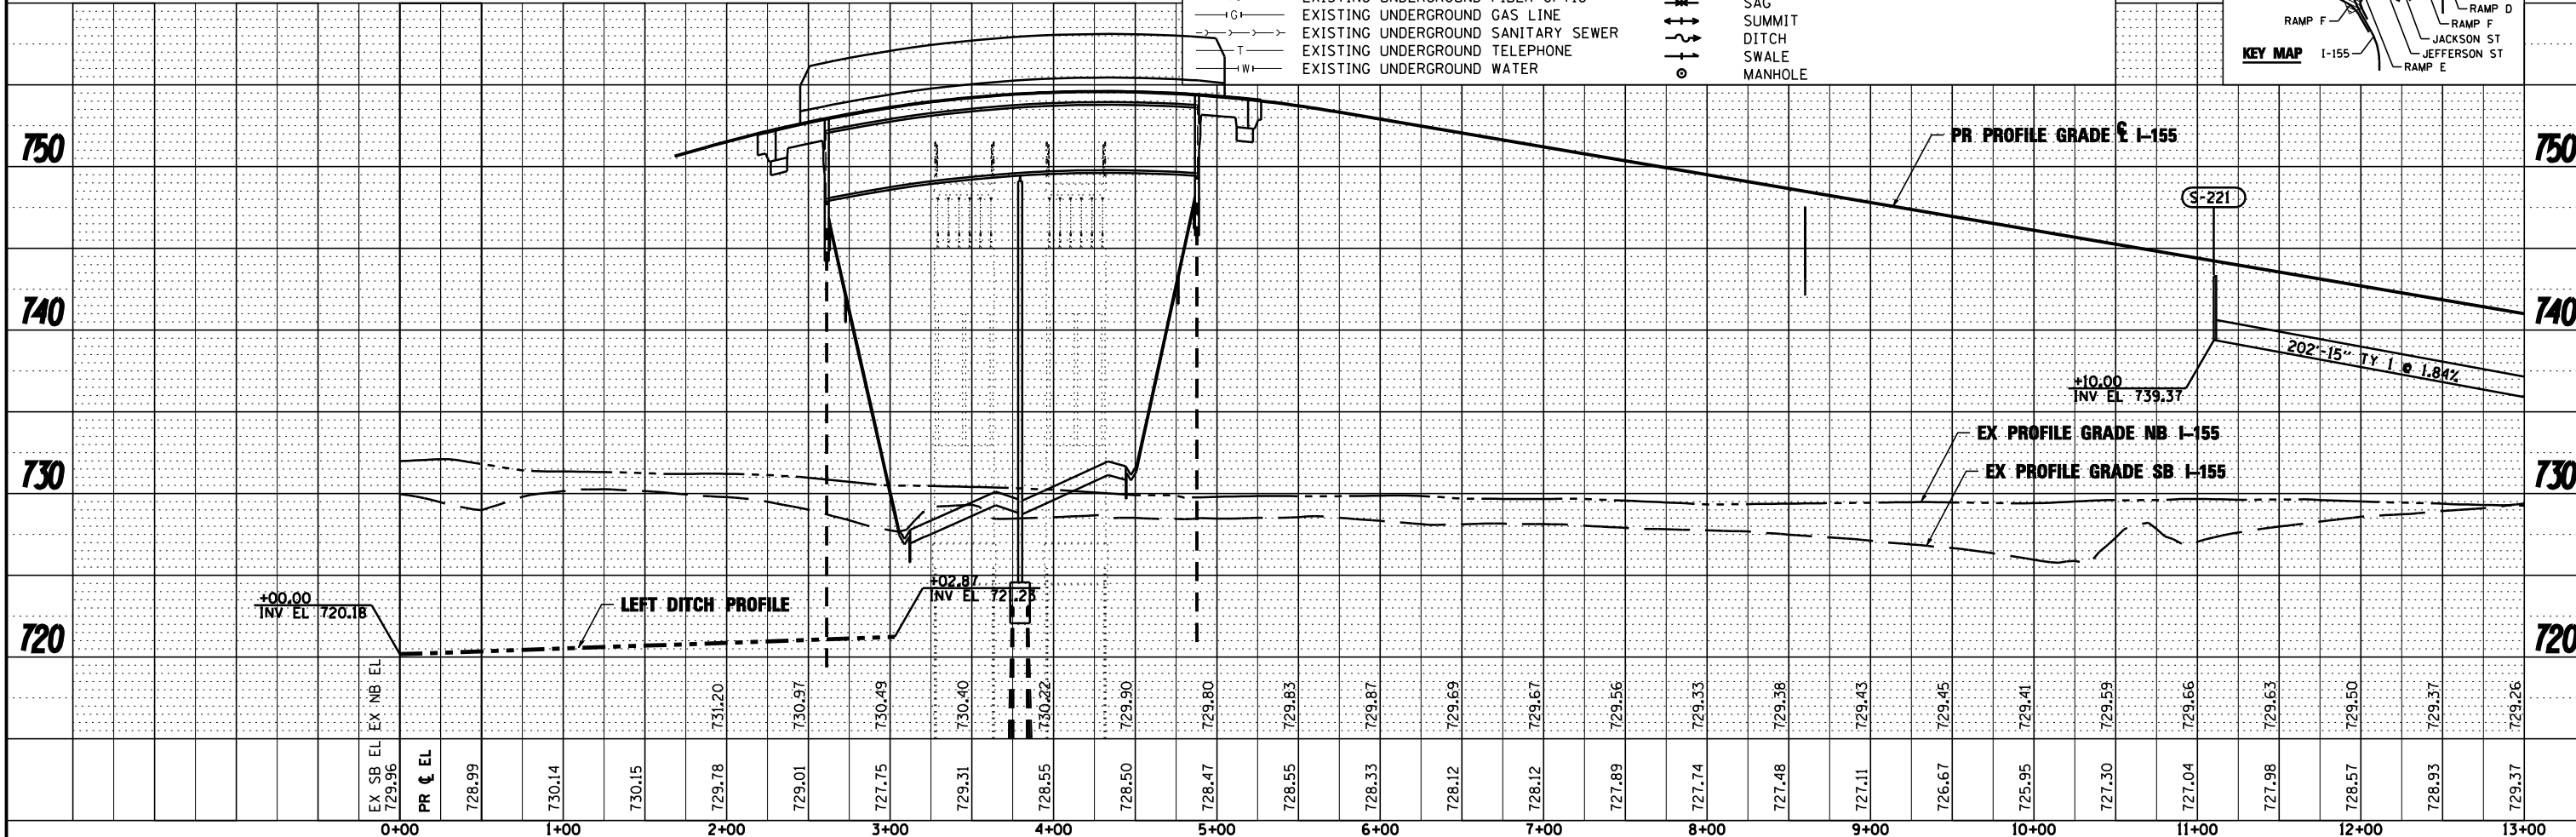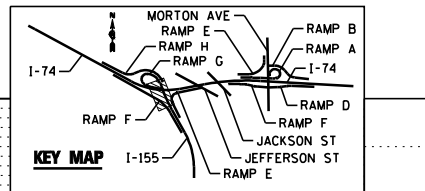

FILE NAME =	DESIGNED - AJP	REVISED -		STATE OF ILLINOIS DEPARTMENT OF TRANSPORTATION			DRAINAGE AND UTILITY PLAN AND PROFILE I-155			F.A.I. SHEET NO.	SECTION	COUNTY	TOTAL SHEETS	SHEET NO.
...D468620-sh1-1-155-drain13.dgn	DRAWN - TMB	REVISED -								90-114R(14HB-4,14,14HVB)BR	TAZEWELL	2433	1427	
USER NAME = toddbenk	CHECKED - JNR	REVISED -								CONTRACT NO. 68620				
PLOT DATE = 7/17/2012	DATE - JULY 20, 2012	REVISED -								ILLINOIS FED. AID PROJECT				