




PLAN	SURVEYED	DATE
	PLOTTED	BY
	CHECKED	
	AT	
	FILE NAME	
	NO.	

PROFILE	SURVEYED	DATE
	PLOTTED	BY
	CHECKED	
	AT	
	FILE NAME	
	NO.	

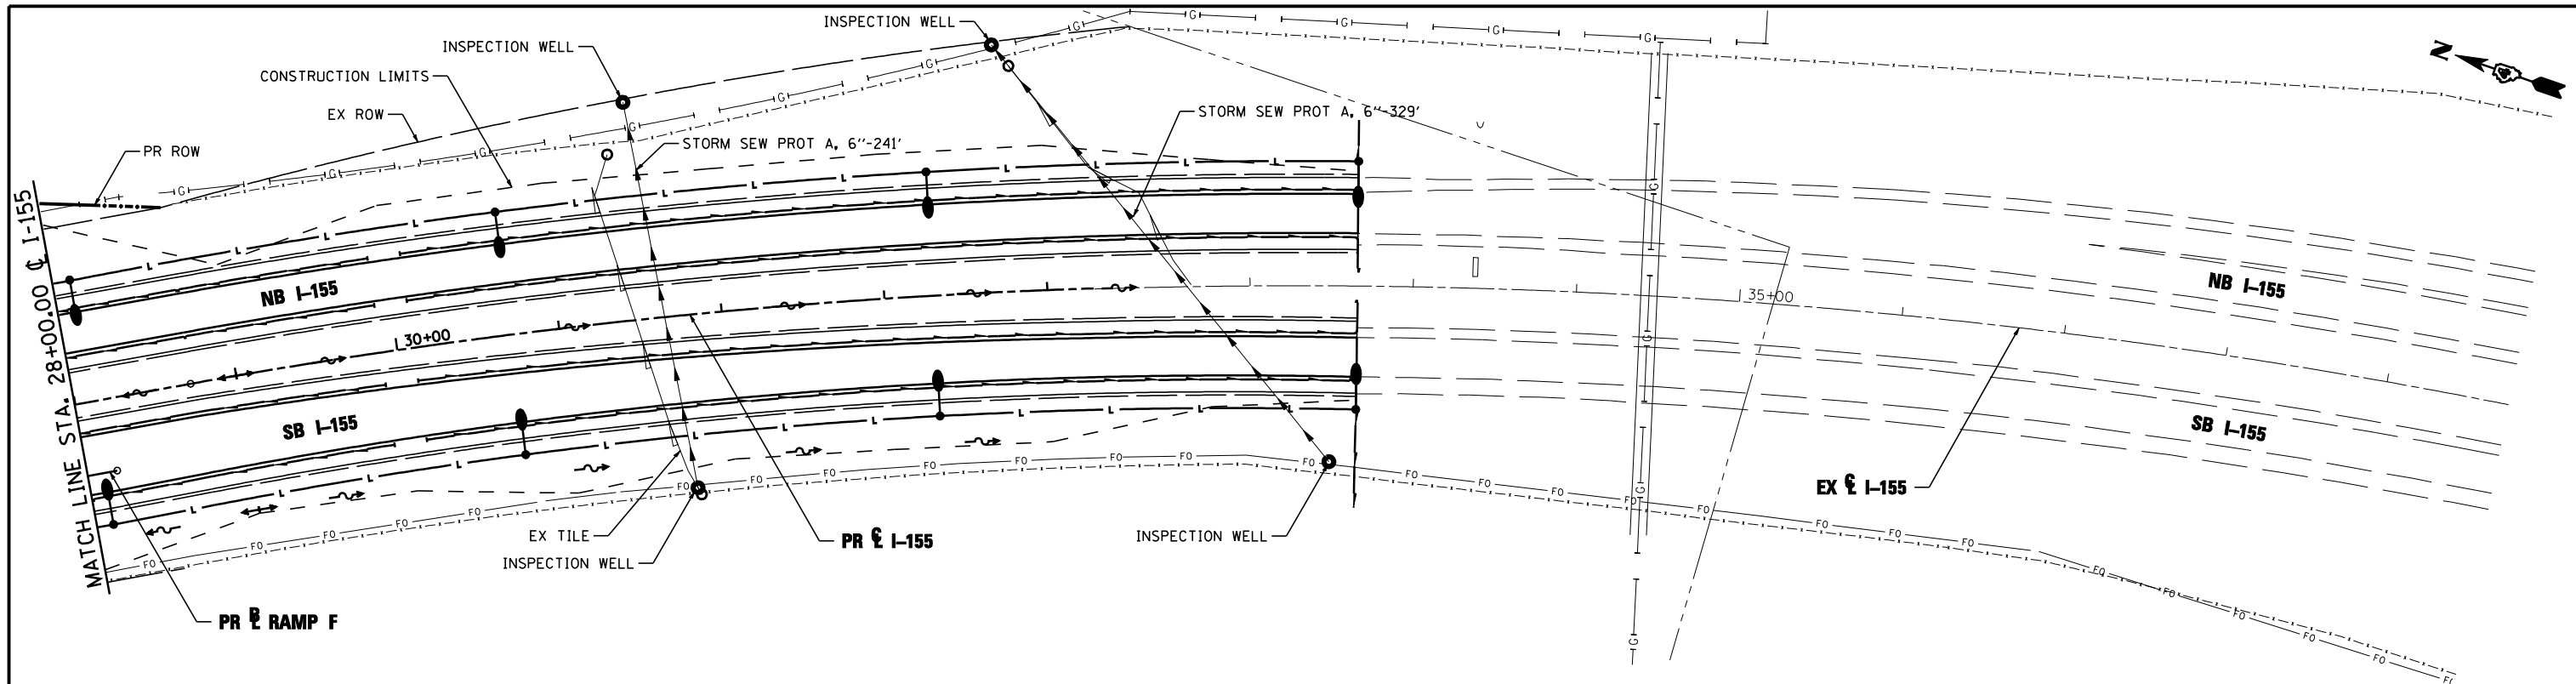

**LEGEND:**

— A —	EXISTING AERIAL LINE	— — —	PROPOSED STORM SEWER
— CTV —	EXISTING UNDERGROUND CABLE TV	— — —	PROPOSED PIPE UNDERDRAIN
— E —	EXISTING UNDERGROUND ELECTRIC	— — —	PROPOSED STORM SEWER STRUCTURE CALLOUTS
— FO —	EXISTING UNDERGROUND FIBER OPTIC	— — —	PROPOSED STORM SEWER PIPE CALLOUTS
— IG —	EXISTING UNDERGROUND GAS LINE	— — —	SAG
— T —	EXISTING UNDERGROUND SANITARY SEWER	— — —	SUMMIT
— TW —	EXISTING UNDERGROUND TELEPHONE	— — —	DITCH
— W —	EXISTING UNDERGROUND WATER	— — —	SWALE
		— — —	MANHOLE

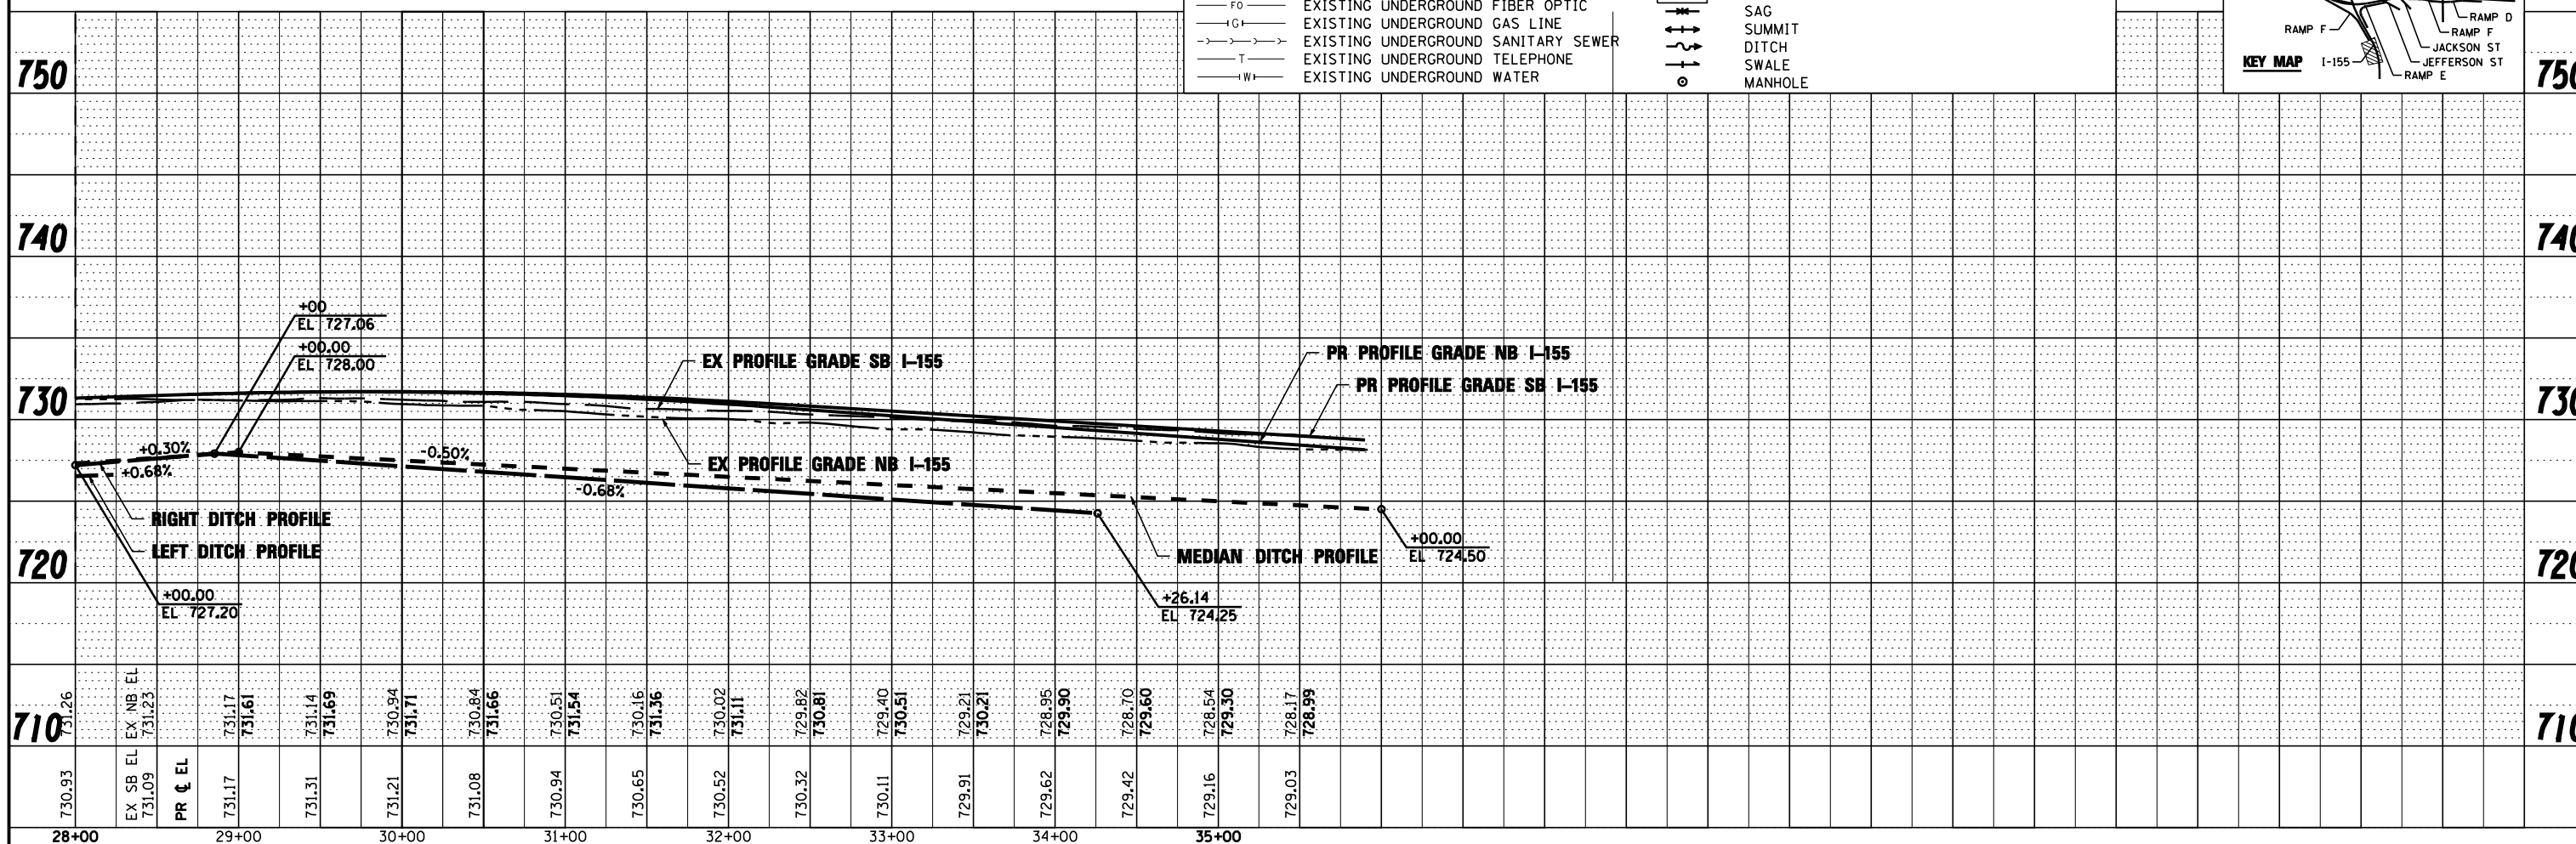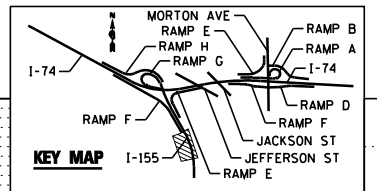

FILE NAME =	DESIGNED - AJP	REVISED -		<b>STATE OF ILLINOIS</b> <b>DEPARTMENT OF TRANSPORTATION</b>	<b>DRAINAGE AND UTILITY PLAN AND PROFILE</b> <b>I-155</b>		F.A.I. RTE.	SECTION	COUNTY	TOTAL SHEETS	SHEET NO.
...D468620-sht-1-155-drain15.dgn	DRAWN - TMB	REVISED -			90-114R(14HB-4,14,14HVB)BR	TAZEWELL	2433	1429			
USER NAME = toddbenk	CHECKED - JNR	REVISED -			<b>CONTRACT NO. 68620</b>						
PLOT DATE = 7/17/2012	DATE - JULY 20, 2012	REVISED -			ILLINOIS FED. AID PROJECT						