




PLAN	SURVEYED	DATE
	PLOTTED	BY
	CHECKED	
	ALIGNED	
	FILE NAME	
	NO.	

PROFILE	SURVEYED	DATE
	PLOTTED	BY
	CHECKED	
	STRUCTURE	
	NOT AT THIS OFFICE	
	NO.	

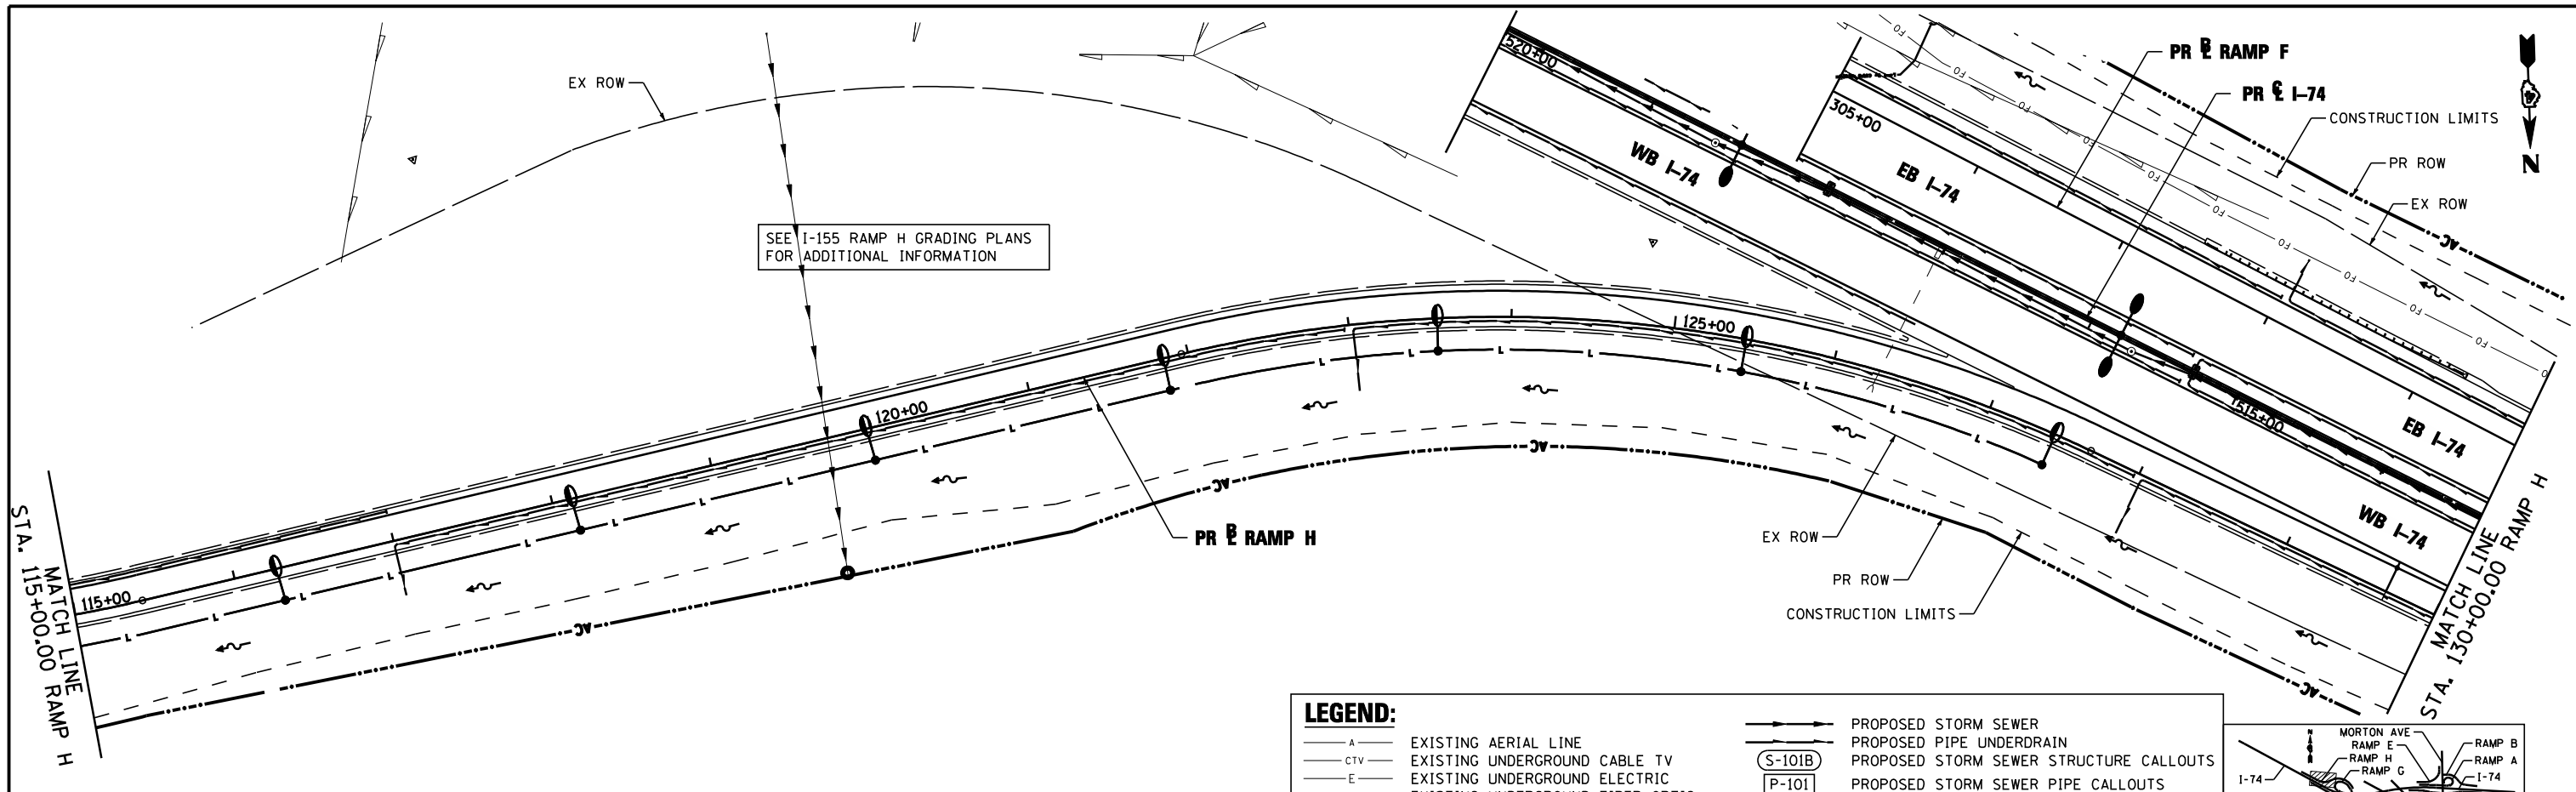

LEGEND:

— A —	EXISTING AERIAL LINE	— S —	PROPOSED STORM SEWER
— CTV —	EXISTING UNDERGROUND CABLE TV	(S-101B)	PROPOSED PIPE UNDERDRAIN
— E —	EXISTING UNDERGROUND ELECTRIC	(P-101)	PROPOSED STORM SEWER STRUCTURE CALLOUTS
— FO —	EXISTING UNDERGROUND FIBER OPTIC	— SAG —	PROPOSED STORM SEWER PIPE CALLOUTS
— IG —	EXISTING UNDERGROUND GAS LINE	— DITCH —	SUMMIT
— T —	EXISTING UNDERGROUND SANITARY SEWER	— SWALE —	DITCH
— W —	EXISTING UNDERGROUND TELEPHONE	— MANHOLE —	SWALE
	EXISTING UNDERGROUND WATER		MANHOLE

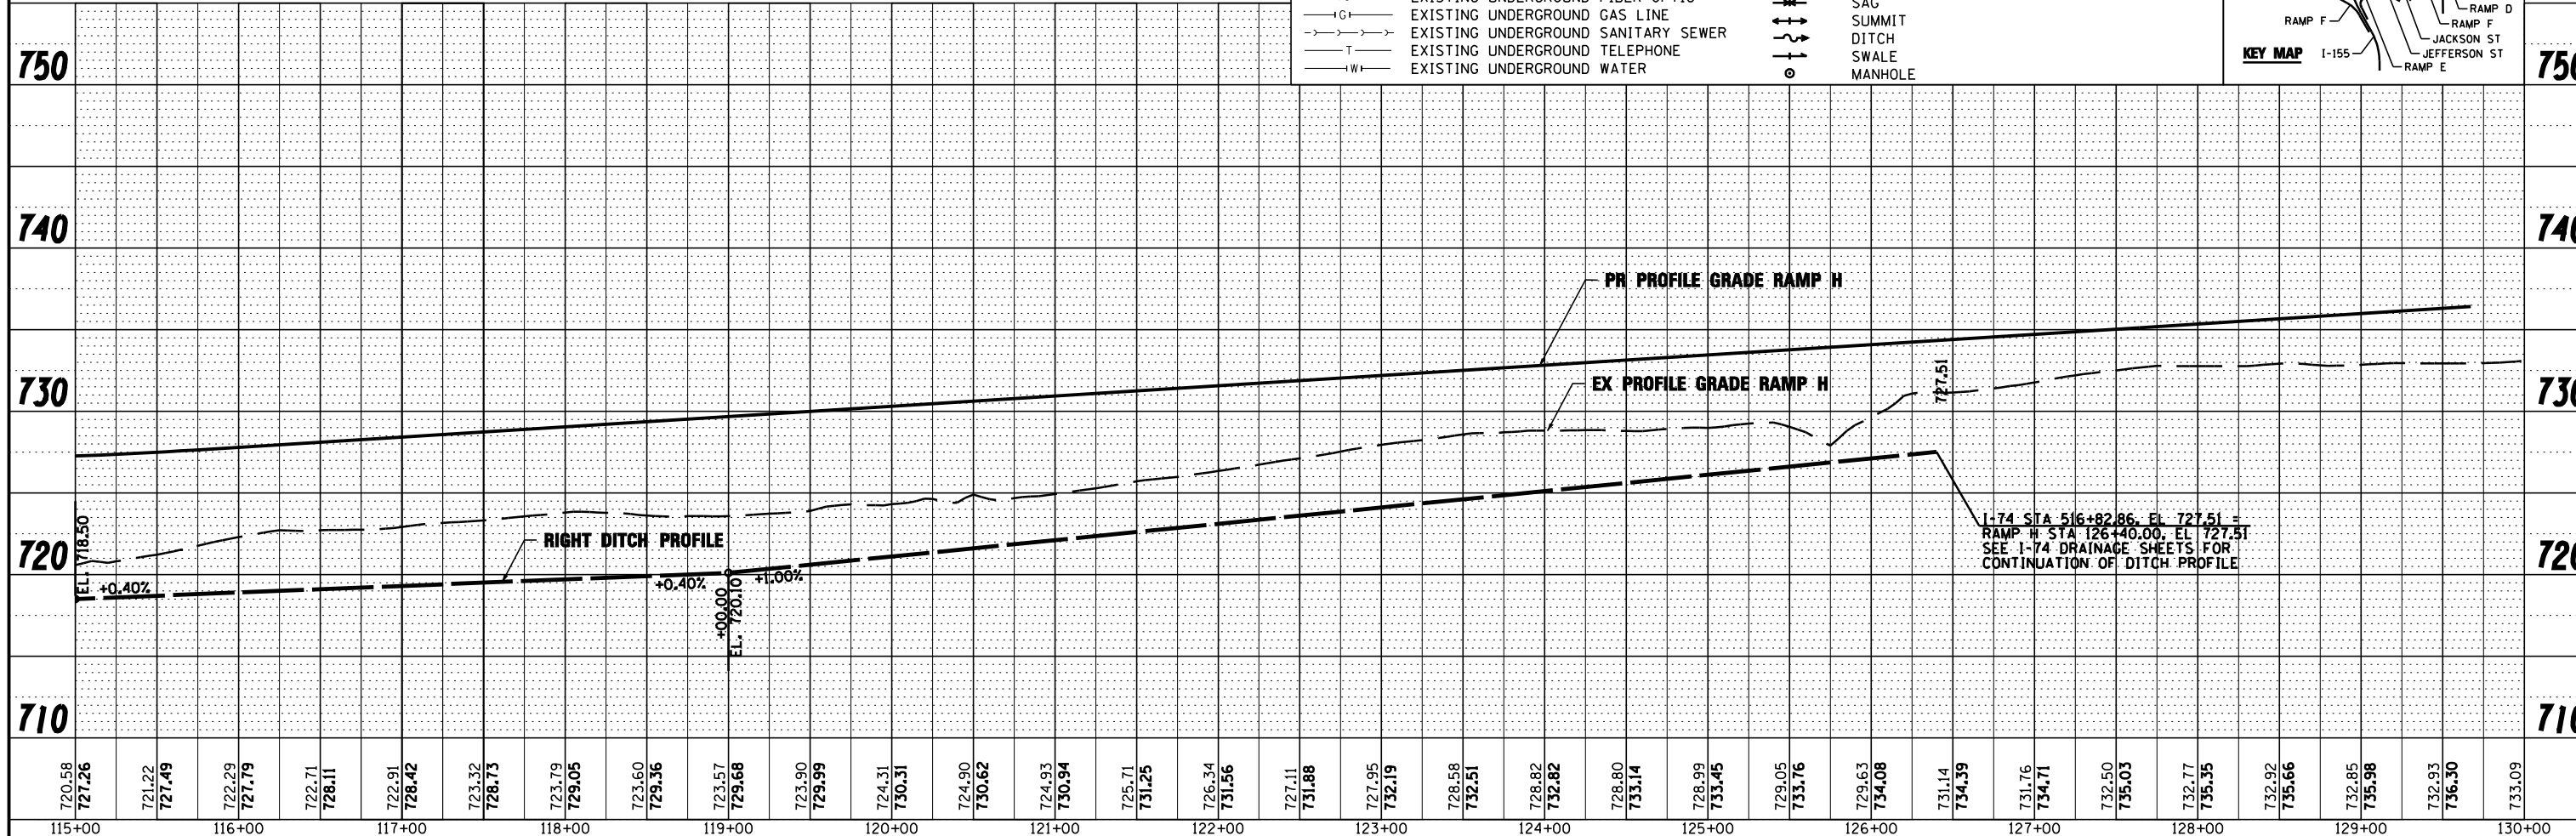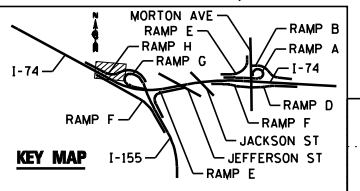

FILE NAME =	DESIGNED -	AJP	REVISED -
...D468620-sht-1-155-RampH-drain27.dgn	DRAWN -	TMB	REVISED -
USER NAME = toddbenk	CHECKED -	JNR	REVISED -
PLOT DATE = 7/17/2012	DATE -	JULY 20, 2012	REVISED -



**STATE OF ILLINOIS
DEPARTMENT OF TRANSPORTATION**

**DRAINAGE AND UTILITY PLAN AND PROFILE
I-155 RAMP H**
SCALE: 1"=50' SHEET NO. 8 OF 8 SHEETS STA. 113+00.00 TO STA. 128+00.00

F.A.I. RTE.	SECTION	COUNTY	TOTAL SHEETS	SHEET NO.
90-I14R(14HB-4,14,14HVB)BR	TAZEWELL	2433	1437	
CONTRACT NO. 68620			ILLINOIS FED. AID PROJECT	