




PLAN	SURVEYED	DATE
	PLOTTED	BY
	CHECKED	
	ALIGNED	
	FILE NAME	
	NO.	

PROFILE	SURVEYED	DATE
	PLOTTED	BY
	CHECKED	
	STRUCTURE	
	NOT AT THIS OFFICE	
	NO.	

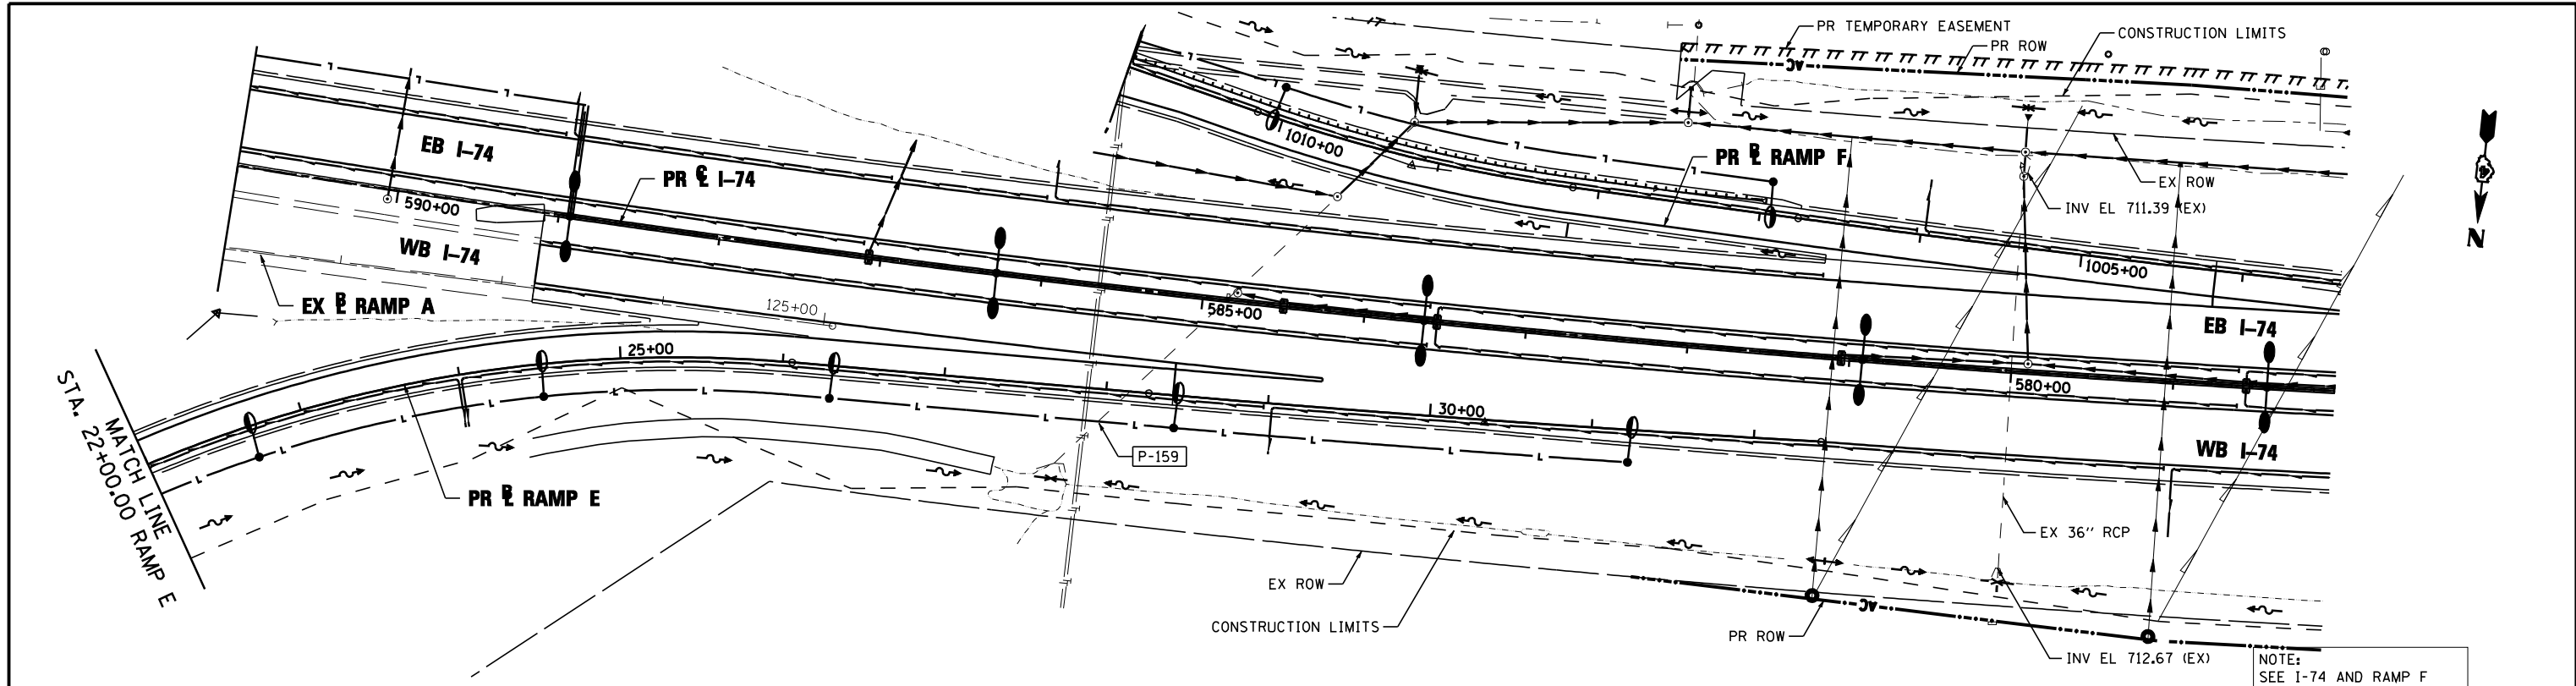

**LEGEND:**

— A —	EXISTING AERIAL LINE	— S —	PROPOSED STORM SEWER
— CTV —	EXISTING UNDERGROUND CABLE TV	— P —	PROPOSED PIPE UNDERDRAIN
— E —	EXISTING UNDERGROUND ELECTRIC	(S-101B)	PROPOSED STORM SEWER STRUCTURE CALLOUTS
— FO —	EXISTING UNDERGROUND FIBER OPTIC	(P-101)	PROPOSED STORM SEWER PIPE CALLOUTS
— G —	EXISTING UNDERGROUND GAS LINE	— SAG —	SAG
— T —	EXISTING UNDERGROUND SANITARY SEWER	— SUMMIT —	SUMMIT
— W —	EXISTING UNDERGROUND TELEPHONE	— DITCH —	DITCH
— W —	EXISTING UNDERGROUND WATER	— SWALE —	SWALE
		— M —	MANHOLE

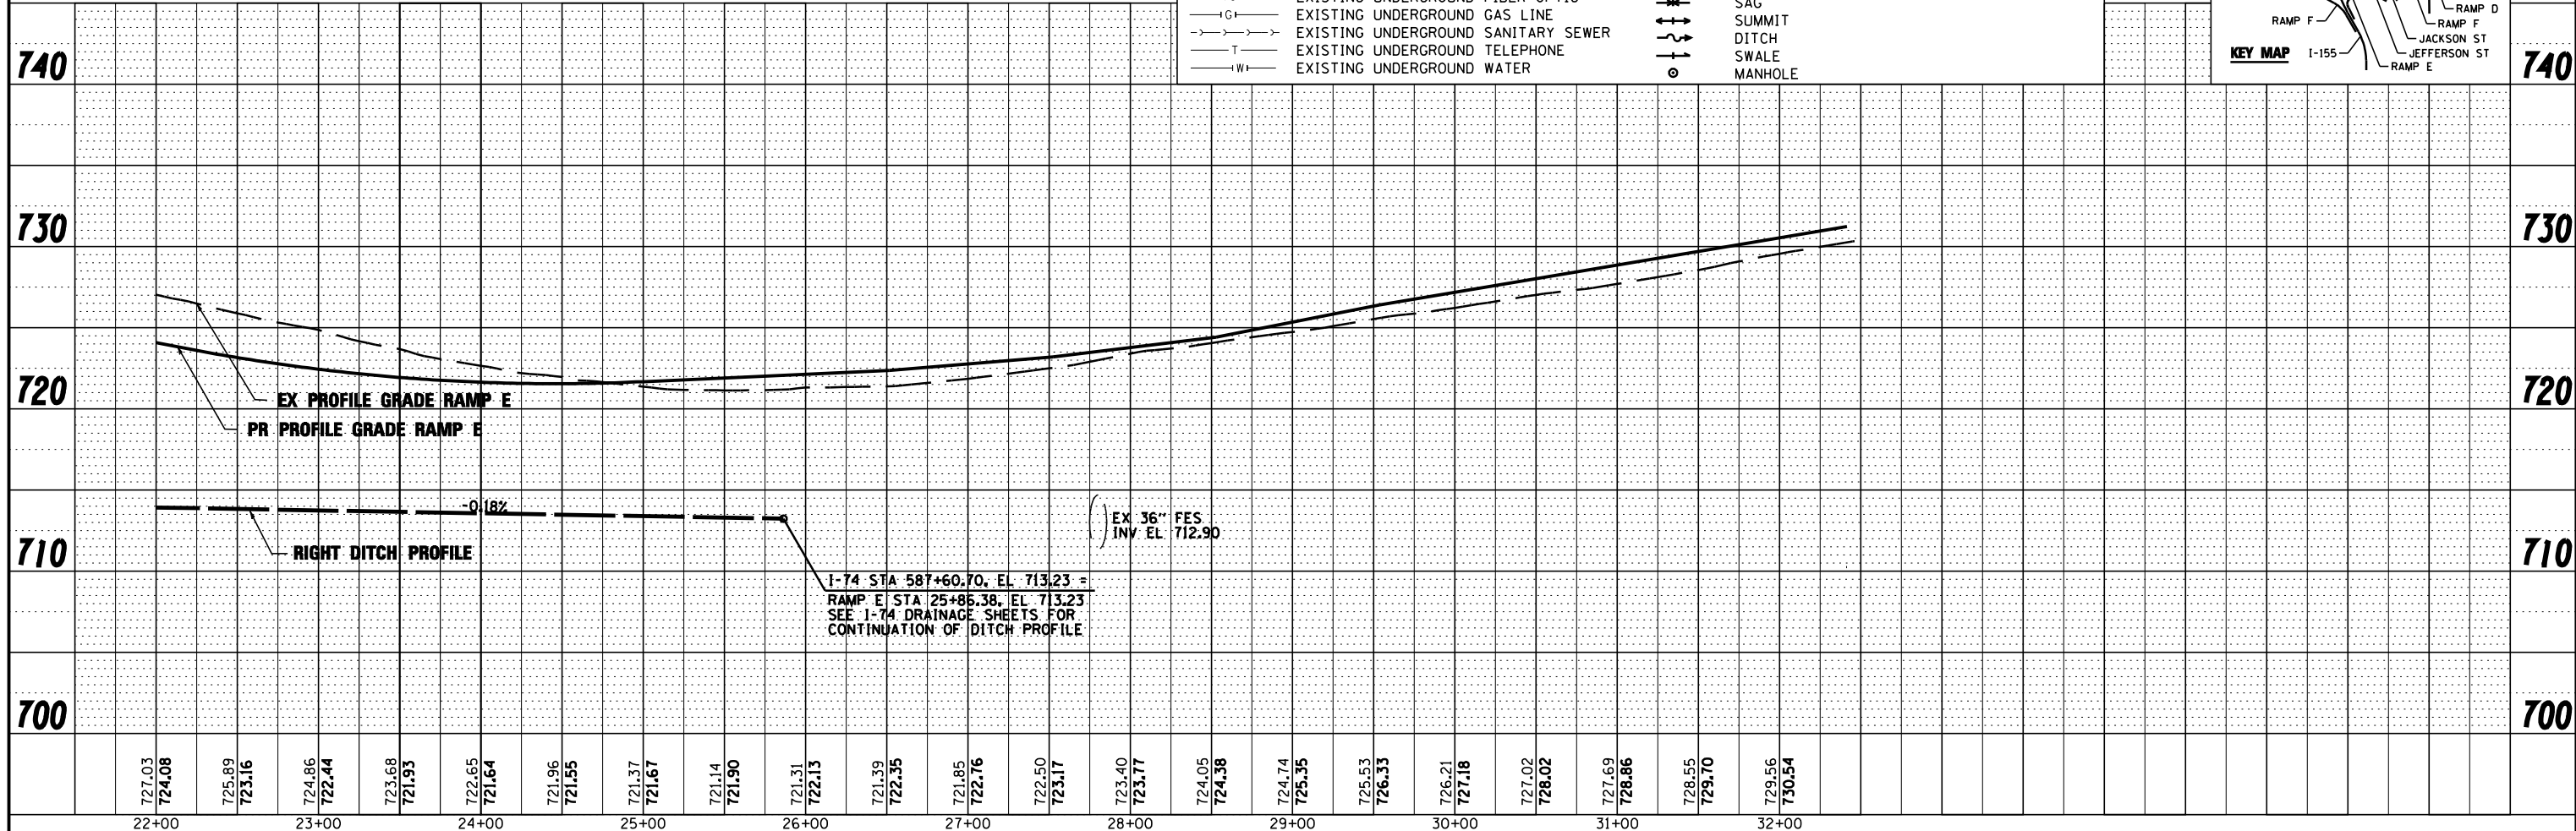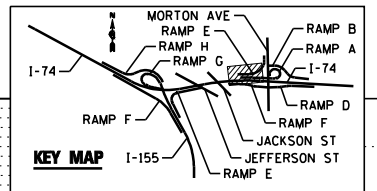

FILE NAME =	DESIGNED - I S	REVISED -
...D468620-sh1-rampE-Morton-drain39.dgn	DRAWN - TMB	REVISED -
USER NAME = toddbenk	CHECKED - JNR	REVISED -
PLOT DATE = 7/18/2012	DATE - JULY 20, 2012	REVISED -



**STATE OF ILLINOIS  
DEPARTMENT OF TRANSPORTATION**

**DRAINAGE AND UTILITY PLAN AND PROFILE  
RAMP E MORTON AVE**

SCALE: 1"=50'    SHEET NO. 2 OF 3 SHEETS    STA. 20+00.00 TO STA. POE

F.A.I. RTE.	SECTION	COUNTY	TOTAL SHEETS	SHEET NO.
90-114R(14HB-4,14,14HVB)BR	TAZEWELL	ILLINOIS	2433	1445
CONTRACT NO. 68620			ILLINOIS FED. AID PROJECT	