


SIGN DETAIL
1:100

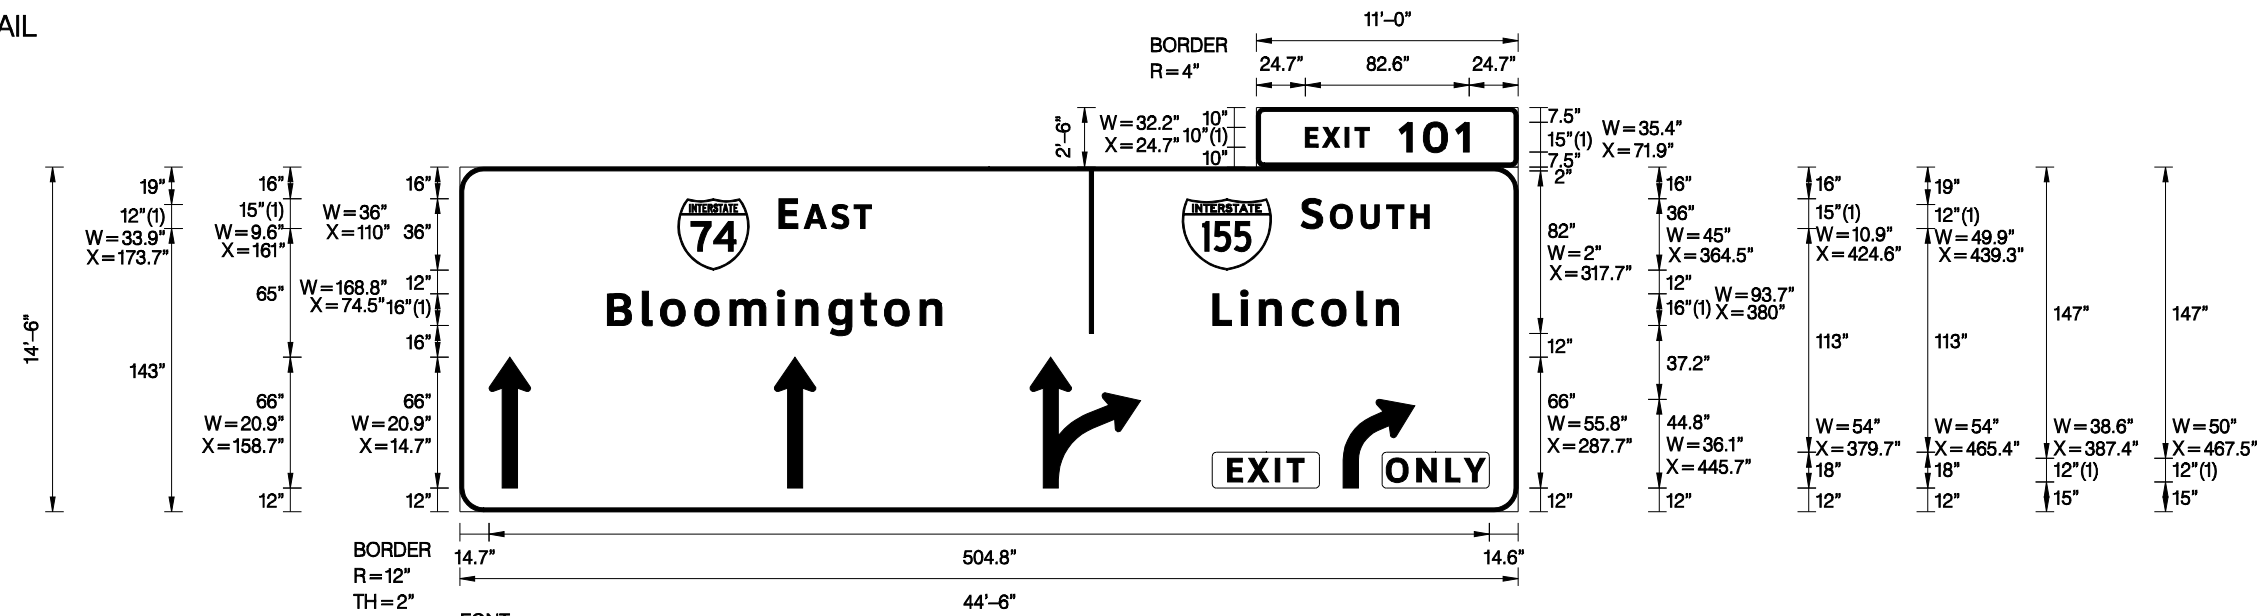

Panel Style: guide_fwy_overhead_arrow-per-lane_clearview.ssi
 Dimensions are in inches.tenths
 FONT: (1) ClearviewHwy-5-W
 M.U.T.C.D.: 2009 Edition

Letter locations are panel edge to lower left corner

SIGN NUMBER	4S0901074R100.3
WIDTH x HGHT.	44'-6" x 14'-6", 11'-0" x 2'-6"
BORDER WIDTH	2"
CORNER RADIUS	12"
MOUNTING	Overhead
BACKGROUND	TYPE: ZZ Retro Reflective COLOR: Color 24
LEGEND/BORDER	TYPE: ZZ Retro Reflective COLOR: Color 100 /Color 240

SYMBOL	ROT	X	Y	WID	HT
M1_1	0	110	122	36	36
M1_1	0	364.5	122	45	36
AR_THRU	0	14.7	12	20.9	66
AR_THRU	0	158.7	12	20.9	66
AR_THRU_RIGHT	0	287.7	12	55.8	66
AR_RIGHT_ONLY	0	445.7	12	36.1	44.8

LETTER POSITIONS (X)

LETTER	X	Y	WID	HT	LENGTH	SERIES	SIZE
E	24.7	143.0	33.3	12.0	82.6	ClearviewHwy-5-W	10,15
X	33.3	143.0	12.0	12.0			
I	44.7	143.0	9.6	12.0			
T	49.7	143.0	9.6	12.0			
1	71.9	143.0	20.9	12.0			
0	84.2	143.0	20.9	12.0			
1	100.5	143.0	20.9	12.0			
E	161.0	122.0	173.7	12.0	46.7	ClearviewHwy-5-W	15,12
A	173.7	122.0	18.5	12.0			
S	187.5	122.0	18.5	12.0			
T	199.0	122.0	18.5	12.0			
S	424.6	122.0	439.3	12.0	64.6	ClearviewHwy-5-W	15,12
O	439.3	122.0	45.8	12.0			
U	454.8	122.0	46.7	12.0			
T	467.7	122.0	46.7	12.0			
H	480.0	122.0	48.0	12.0			
B	74.5	12.0	92.1	12.0	168.8	ClearviewHwy-5-W	16/13
I	92.1	12.0	101.3	12.0			
o	101.3	12.0	118.5	12.0			
o	118.5	12.0	136.3	12.0			
m	160.2	12.0	169.7	12.0			
i	169.7	12.0	186.2	12.0			
n	186.2	12.0	202.3	12.0			
g	202.3	12.0	214.4	12.0			
t	214.4	12.0	232.2	12.0			
o	232.2	12.0		12.0			
n		12.0		12.0			
L	380.0	12.0	394.0	12.0	93.7	ClearviewHwy-5-W	16/13
i	394.0	12.0	403.5	12.0			
n	403.5	12.0	420.0	12.0			
c	420.0	12.0	434.9	12.0			
o	434.9	12.0	452.7	12.0			
l	452.7	12.0	462.6	12.0			
n	462.6	12.0		12.0			
E	387.4	12.0	397.7	12.0	38.6	ClearviewHwy-5-W	12
X	397.7	12.0	411.4	12.0			
I	411.4	12.0	417.4	12.0			
T	417.4	12.0		12.0			
O	467.5	12.0	482.9	12.0	50.0	ClearviewHwy-5-W	12
N	482.9	12.0	497.6	12.0			
L	497.6	12.0	506.9	12.0			
Y	506.9	12.0		12.0			

FILE NAME =	DESIGNED - SMS	REVISED -
...D468620-sh1-signdetail102.dgn	DRAWN - SMS	REVISED -
USER NAME = IDDT	CHECKED - LDC	REVISED -
PLOT DATE = 7/16/2012	DATE - JULY 20, 2012	REVISED -



STATE OF ILLINOIS
DEPARTMENT OF TRANSPORTATION

SIGN PANEL DETAILS

SCALE: SHEET NO. 2 OF 37 SHEETS STA. TO STA.

F.A.I. RTE.	SECTION	COUNTY	TOTAL SHEETS	SHEET NO.
90-[14R]14HB-4,14,14HB[BR]	TAZEWELL	ILLINOIS	2433	1585
CONTRACT NO. 68620			ILLINOIS FED. AID PROJECT	