


SOUTH ABUTMENT ELEVATION – SECTION – A-A

LOOKING SOUTH

NOTE: SEE LIGHTING PLAN SHEET 38 FOR
PLAN VIEW OF SECTION CUT LOCATIONS.

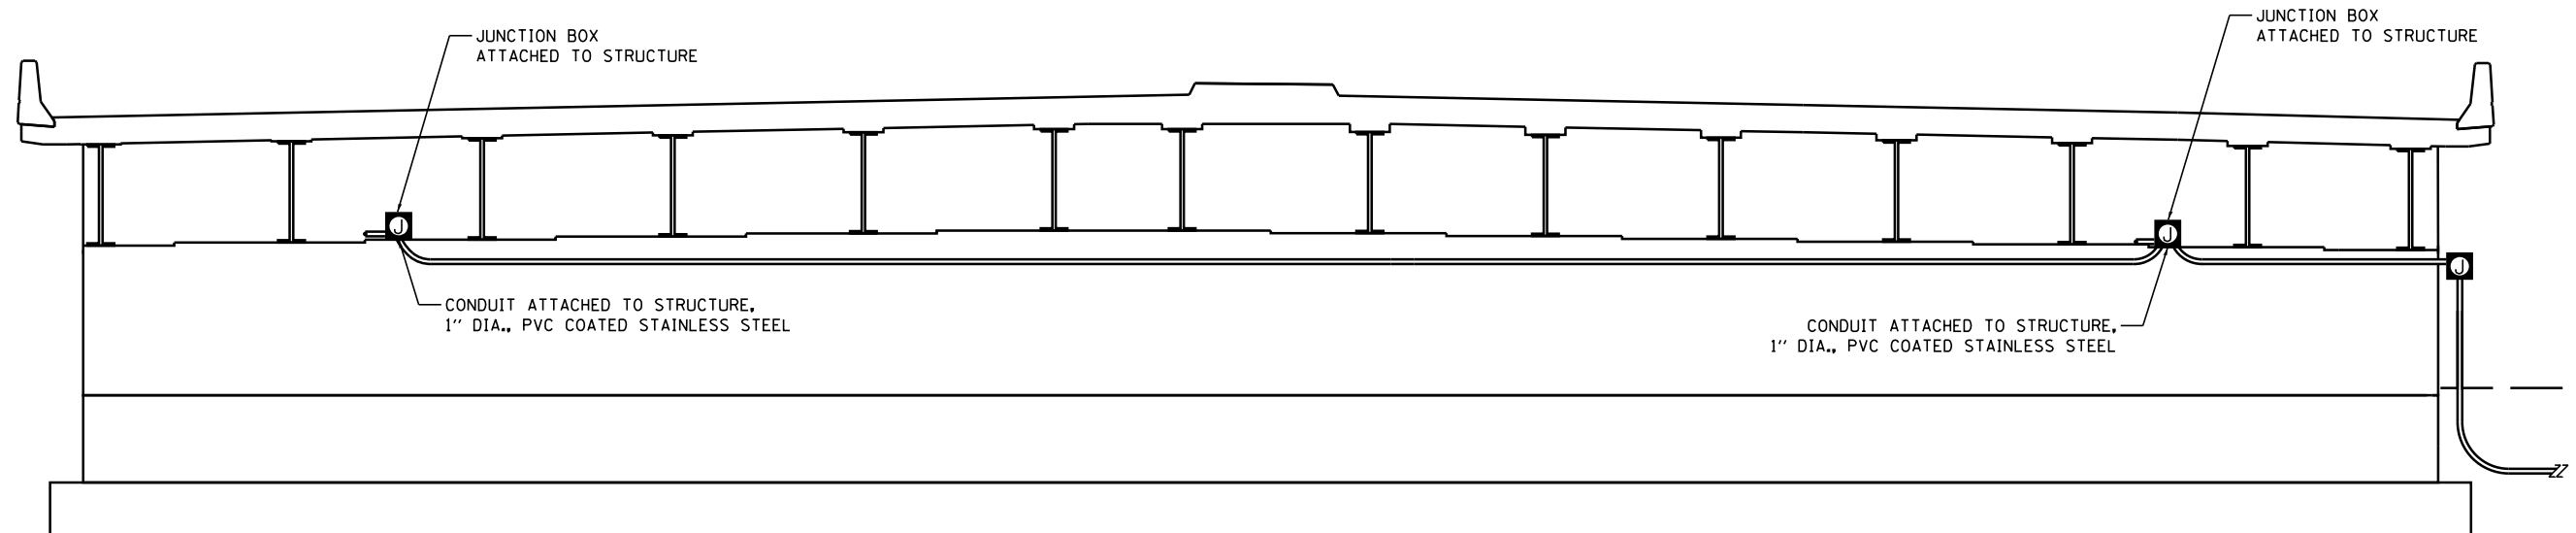

NORTH ABUTMENT ELEVATION – SECTION – B-B

LOOKING NORTH

NOTE: SEE LIGHTING PLAN SHEET 38 FOR
PLAN VIEW OF SECTION CUT LOCATIONS.

FILE NAME =	DESIGNED - BENESCH	REVISED -		STATE OF ILLINOIS DEPARTMENT OF TRANSPORTATION	I-74 UNDERDECK LIGHTING AT MORTON AVENUE		F.A.I. RT.	SECTION	COUNTY	TOTAL SHEETS	SHEET NO.
...\\D468620-shit-Lighting_Details-Underdeck01	DRAWN - NLH	REVISED -					90-[14R;(14HB-4,14,14HVB)BR]	TAZEWELL	2433	1754	
USER NAME = tblank	CHECKED - GHT	REVISED -					CONTRACT NO. 68620				
PLOT DATE = 9/5/2012	DATE - JULY 20, 2012	REVISED -					ILLINOIS FED. AID PROJECT				
					SCALE:	SHEET NO. 39 OF 138 SHEETS	STA.	TO STA.			