




CENTER ELECTRICAL PLAN - LIGHTING
1" = 20'-0"

GENERAL NOTES

 
1. CONTRACTOR SHALL LOCATE ALL EXISTING UTILITIES PRIOR TO BEGINNING CONSTRUCTION.
2. UNLESS NOTED OTHERWISE, ALL CONDUIT SHALL BE PVC.
3. ROUTE CONDUITS AROUND TREE PLANTING AREAS.
4. ALL LIGHTING SHALL REMAIN OPERATIONAL UNTIL NEW IS INSTALLED AND MADE OPERATIONAL.
5. ALL WORK ON EAST SIDE MUST BE COMPLETED PRIOR TO FESTIVAL (ART ON SQUARE).

KEYED NOTES

- 1 PROVIDE A 1 1/2" PVC CONDUIT WITH (2) #6, (1) #6N (1) #10G.
- 2 PROVIDE A 1" PVC CONDUIT WITH (2) #8, AND (1) #10G.
- 3 PROVIDE A 1 1/2" PVC CONDUIT WITH (2) #6, AND (1) #10G.
- 4 PROVIDE A 1" PVC CONDUIT WITH (2) #10, AND (1) #10G.
- 5 PROVIDE A 1" PVC CONDUIT WITH (2) #10, (1) #10N AND (1) #10G.
- 6 PROVIDE NEW HEAVY DUTY HANDHOLE. SEE DETAIL #6/E4.1.
- 7 SEE "SE PLAZA FLAG POLE-LIGHTING" DETAIL THIS SHEET FOR WIRING INFORMATION.
- 8 SEE "SE MONUMENT-LIGHTING" DETAIL THIS SHEET FOR WIRING INFORMATION.
- 9 SEE "NE MONUMENT-LIGHTING" DETAIL THIS SHEET FOR WIRING INFORMATION.
- 10 PROVIDE A 12"x12" HANDHOLE ROUTE CONDUIT AROUND EXISTING MONUMENTS.
- 11 PROVIDE A 2 1/2" PVC CONDUIT WITH (2) #8, AND (1) #10 GROUND FOR S.W. PLAZA LIGHTS; AND (2) #6, (1) #6 NEUTRAL, AND (1) #10 GROUND FOR S.W. STREET LIGHTS.

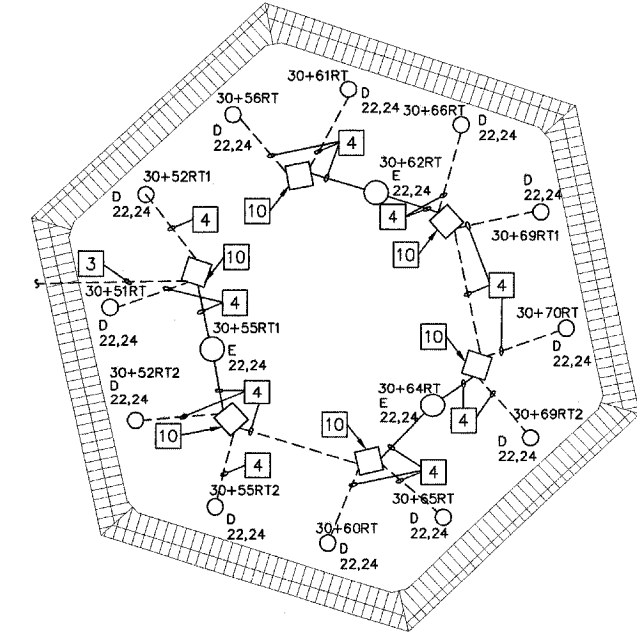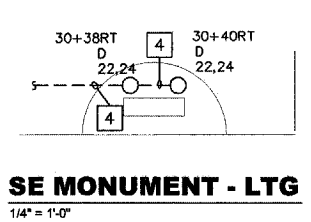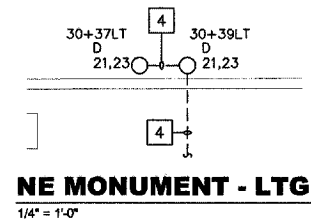

Kaskasia Engineering Group L.L.C.
23 Public Square Suite 404
Belleville, Illinois 62220
Office: (618)-233-9877 Fax: (618)-233-9977
www.kaskasieng.com
A Disadvantaged Business Enterprise

PREPARED BY: 
LANCE L. VANCE
PROFESSIONAL REGISTRATIONS
ILLINOIS PROFESSIONAL DESIGN FIRM
PROFESSIONAL ENGINEERING CORP.
20-000668

BRIC
PARTNERSHIP, LLC
CONSULTING ENGINEERS
100 EAST WASHINGTON, SUITE 220
ST. LOUIS, MISSOURI 63102
TEL: 618.277.5200 FAX: 618.277.9227

Signature: _____
Expiration Date: _____

REV.	DATE	DESCRIP

SHEET TITLE: **CENTER ELECTRICAL SITE PLAN - LIGHTING**
PROJECT TITLE: **BELLEVILLE SQUARE CITY OF BELLEVILLE ST. CLAIR COUNTY, ILLINOIS**

DESIGNED BY: ESP	SHEET
DRAWN BY: GYK/BSF	34
CHECKED BY: BEC	E2.1
DATE OF PRELIMINARY: 08/17/2007	
DATE OF FINAL: 	
SHEET NO. 3 OF 13 SHEETS	
PROJECT NUMBER 07-0041	