


**WEST ELECTRICAL PLAN - LIGHTING**  
1" = 20'-0"

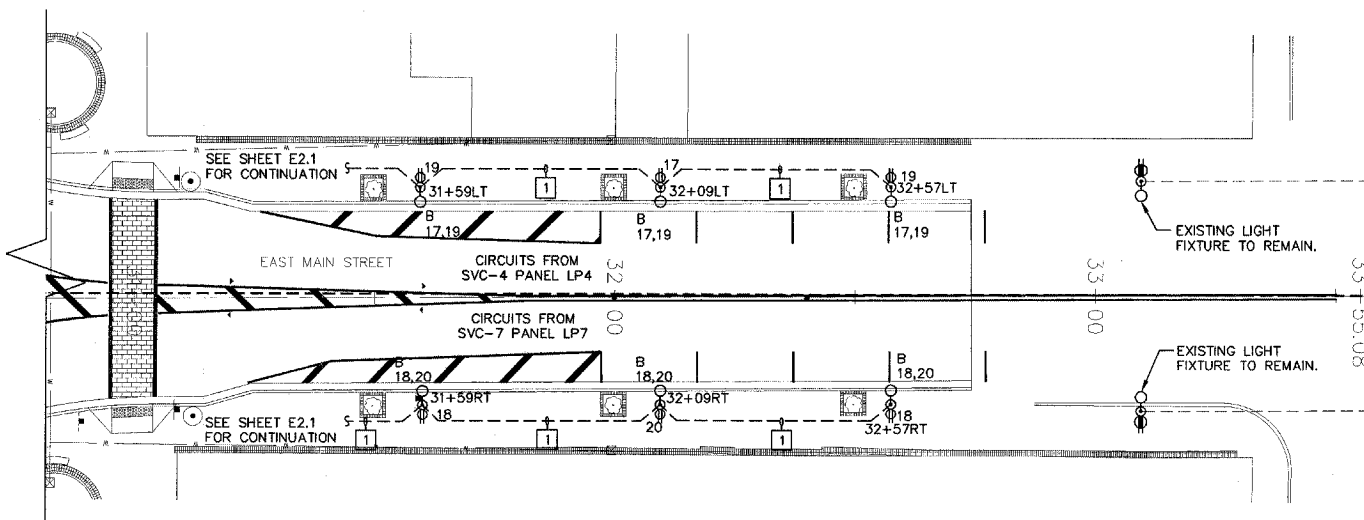

**EAST ELECTRICAL PLAN - LIGHTING**  
1" = 20'-0"

 
**GENERAL NOTES**

1. CONTRACTOR SHALL LOCATE ALL EXISTING UTILITIES PRIOR TO BEGINNING CONSTRUCTION.
2. UNLESS NOTED OTHERWISE, ALL CONDUIT SHALL BE PVC.
3. ROUTE CONDUITS AROUND TREE PLANTING AREAS.
4. ALL LIGHTING SHALL REMAIN OPERATIONAL UNTIL NEW IS INSTALLED AND MADE OPERATIONAL.
5. ALL WORK ON EAST SIDE MUST BE COMPLETED PRIOR TO FESTIVAL (ART ON SQUARE).

**KEYED NOTES**

1. PROVIDE A 1 1/2" PVC CONDUIT WITH (2) #6, (1) #6N (1) #10G
2. REPLACE EXISTING FIXTURE. USE EXISTING WIRING IN PLACE. PROVIDE NECESSARY ANCHOR BOLT ADJUSTMENT TEMPLATE TO ACCOMMODATE NEW FIXTURE ANCHOR BOLTS.
3. EXISTING FIXTURE TO REMAIN. PROTECT EXISTING FIXTURE, WIRE, AND CONDUIT THROUGHOUT CONSTRUCTION.
4. CIRCUITING TO LIGHTING FIXTURES IN THIS AREA IS EXISTING TO REMAIN.
5. PROVIDE A 2 1/2" PVC CONDUIT WITH (2) #8, AND (1) #10 GROUND FOR S.W. PLAZA LIGHTS; AND (2) #6, (1) #6 NEUTRAL, AND (1) #10 GROUND FOR S.W. STREET LIGHTS. BORE UNDER WEST MAIN STREET.
6. PROVIDE A 2 1/2" PVC CONDUIT WITH (2) #8, AND (1) #10 GROUND FOR S.W. PLAZA LIGHTS; AND (2) #6, (1) #6 NEUTRAL, AND (1) #10 GROUND FOR S.W. STREET LIGHTS.

**Kaskasia Engineering Group L.L.C.**  
23 Public Square Suite 404  
Belleville, Illinois 62220  
Office: (618) 233-5877 Fax: (618) 233-5977  
www.kaskasiaeng.com  
A Disadvantaged Business Enterprise

PREPARED BY:   
LICENSE NO. 184-0473  
20-386688  
PROFESSIONAL REGISTRATIONS  
ILLINOIS PROFESSIONAL DESIGN FIRM  
PROFESSIONAL ENGINEERING CORP.

**BRIC**  
PARTNERSHIP, LLC  
CONSULTING ENGINEERS  
100 EAST WASHINGTON SUITE 220  
BELLEVILLE, ILLINOIS 62202  
TEL. 618.277.5200 FAX 618.277.5227

SEAL

Signature: \_\_\_\_\_  
Expiration Date: \_\_\_\_\_

REV	DATE	DESCRIP

SHEET TITLE: **EAST AND WEST ELECTRICAL PLANS - LIGHTING**

PROJECT TITLE: **BELLEVILLE SQUARE CITY OF BELLEVILLE ST. CLAIR COUNTY, ILLINOIS**

DESIGNED BY: ESP	SHEET
DRAWN BY: GYK/ESP	36
CHECKED BY: BEC	E2.3
DATE OF PRELIMINARY: 08/17/2007	
DATE OF FINAL:	
SHEET NO. 5 OF 13 SHEETS	
PROJECT NUMBER 07-0041	