


F.A.P. RTE.	SECTION	COUNTY	TOTAL SHEETS	SHEET NO.
1517	03-00247-00-BR	KANE	121	28
STA. 122+50		TO STA. 125+00		
FED. ROAD DIST. NO. 1		ILLINOIS	HIGHWAY PROJECT	
CONTRACT #: 83867				


FINAL SURVEY NO.	BY	DATE
SURVEYED PLOTTED		
NOTE BOOK TEMPLATE AREAS CHECKED		

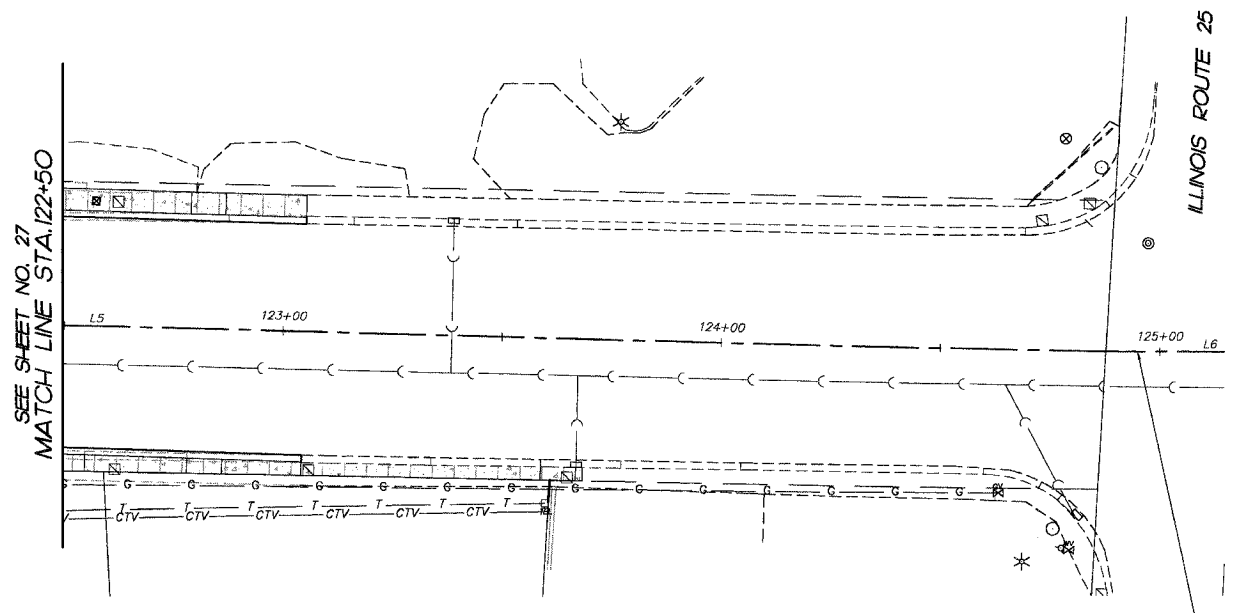

END ILLINOIS AVENUE
IMPROVEMENTS
STA. 124+95

LEGEND

- DENOTES EXISTING STORM SEWER TO BE REMOVED, SIZE AS INDICATED.
- DENOTES STRUCTURE TO BE REMOVED (MANHOLE, VALVE VAULT, CATCH BASIN OR INLET)
- DENOTES PROPOSED DRAINAGE STRUCTURE OR STORM SEWER
- DENOTES PROPOSED WATERMAIN, OR FIRE HYDRANT
- DENOTES EXISTING STRUCTURE TO BE ADJUSTED WITH NEW TYPE 1 FRAME AND GRATE, CLOSED LID
- DENOTES PROPOSED SANITARY STRUCTURE

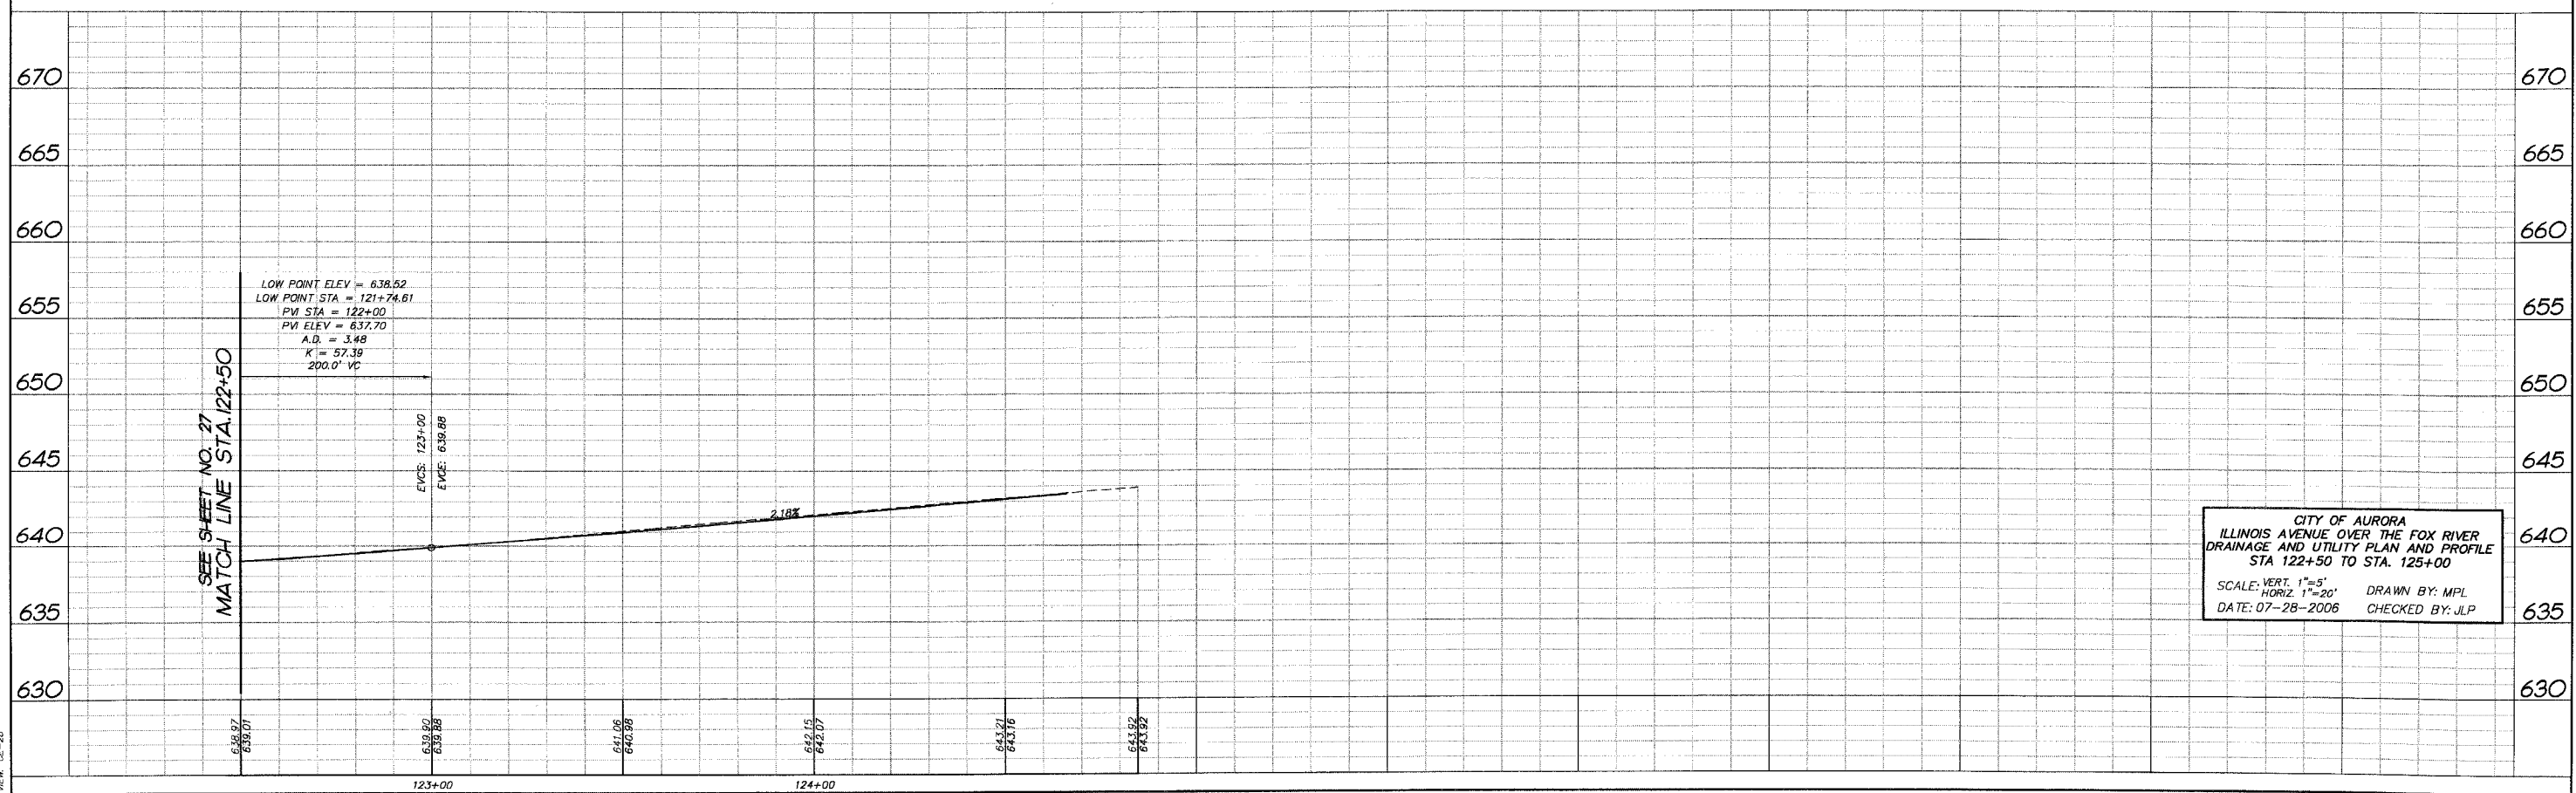

CITY OF AURORA
ILLINOIS AVENUE OVER THE FOX RIVER
DRAINAGE AND UTILITY PLAN AND PROFILE
STA 122+50 TO STA. 125+00
SCALE: VERT. 1"=5'
HORIZ. 1"=20'
DATE: 07-28-2006
DRAWN BY: MPL
CHECKED BY: JLP

DRAWN FILE: 0507181-60226.dwg
DATE: 07-28-06