
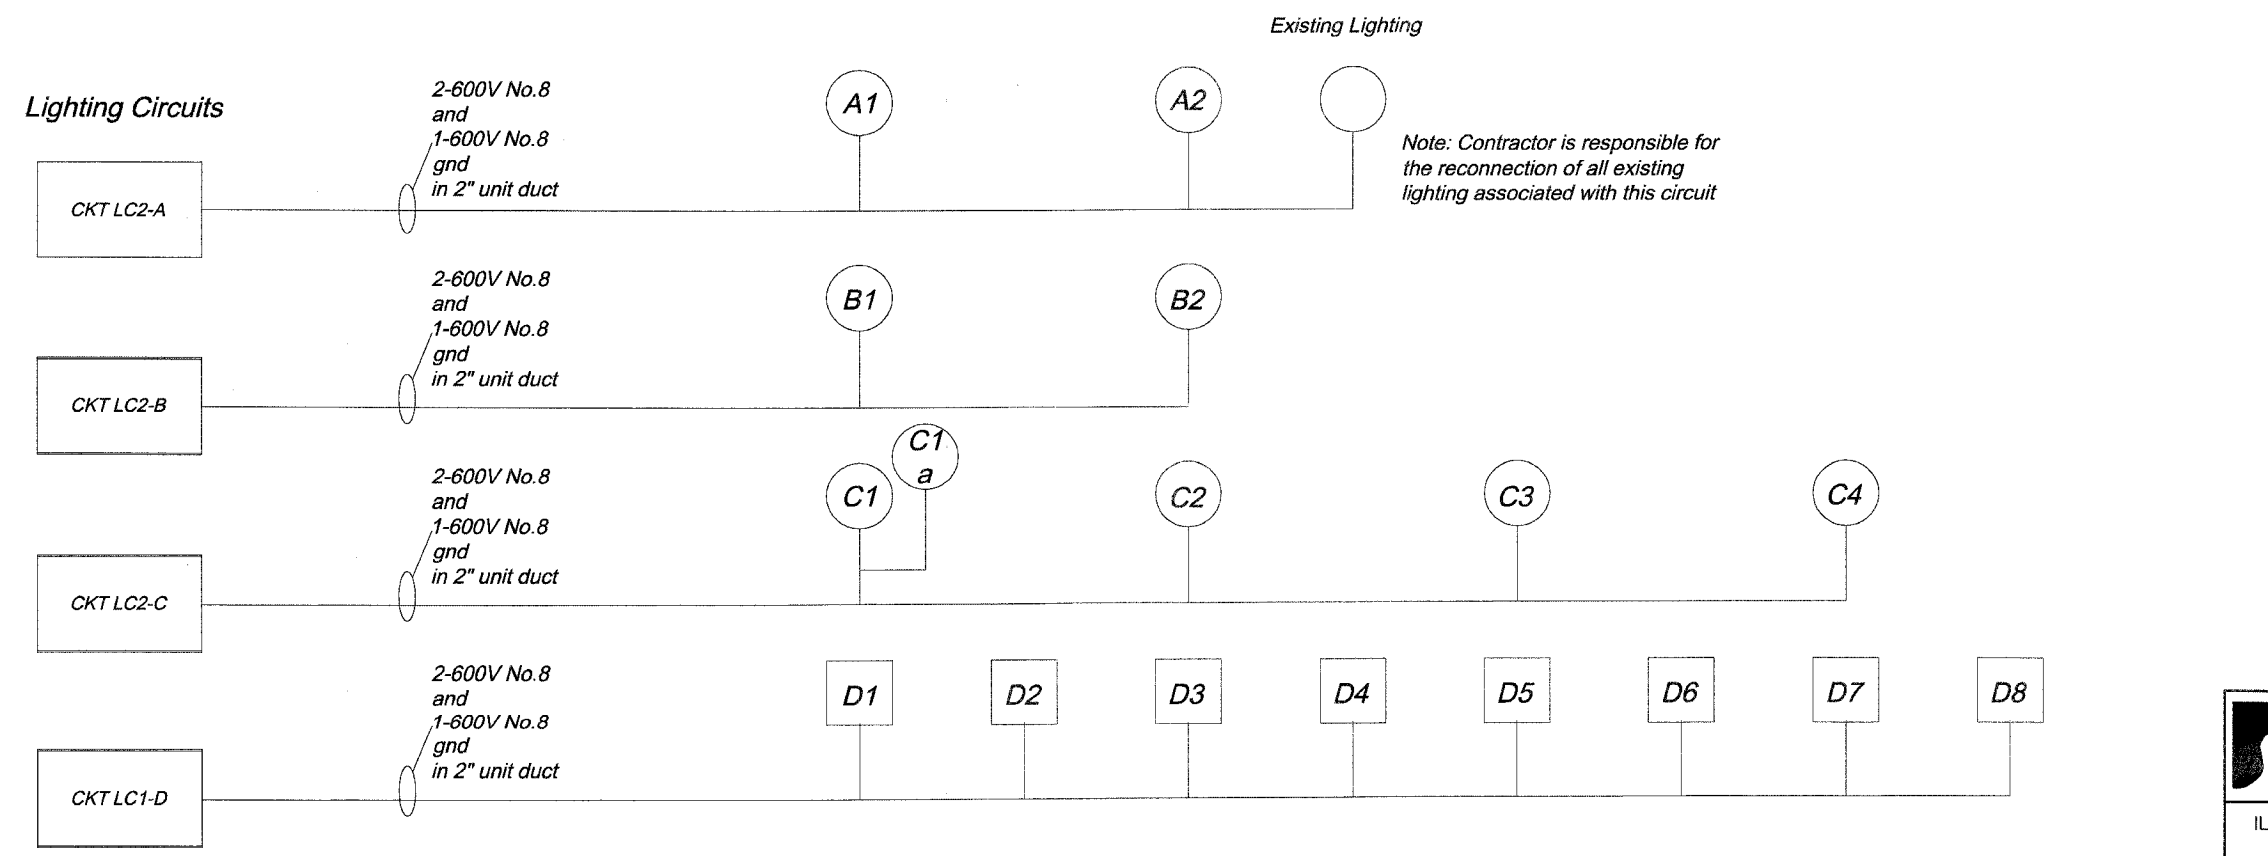


F.A.P. RTE.	SECTION	COUNTY	TOTAL SHEETS	SHEET NO.
1517	03-00247-00-BR	KANE	121	39
STA.		TO STA.		
FED. ROAD DIST. NO. 1		ILLINOIS	HIGHWAY PROJECT	

E-07 OF E-09

CONTRACT #: 83867

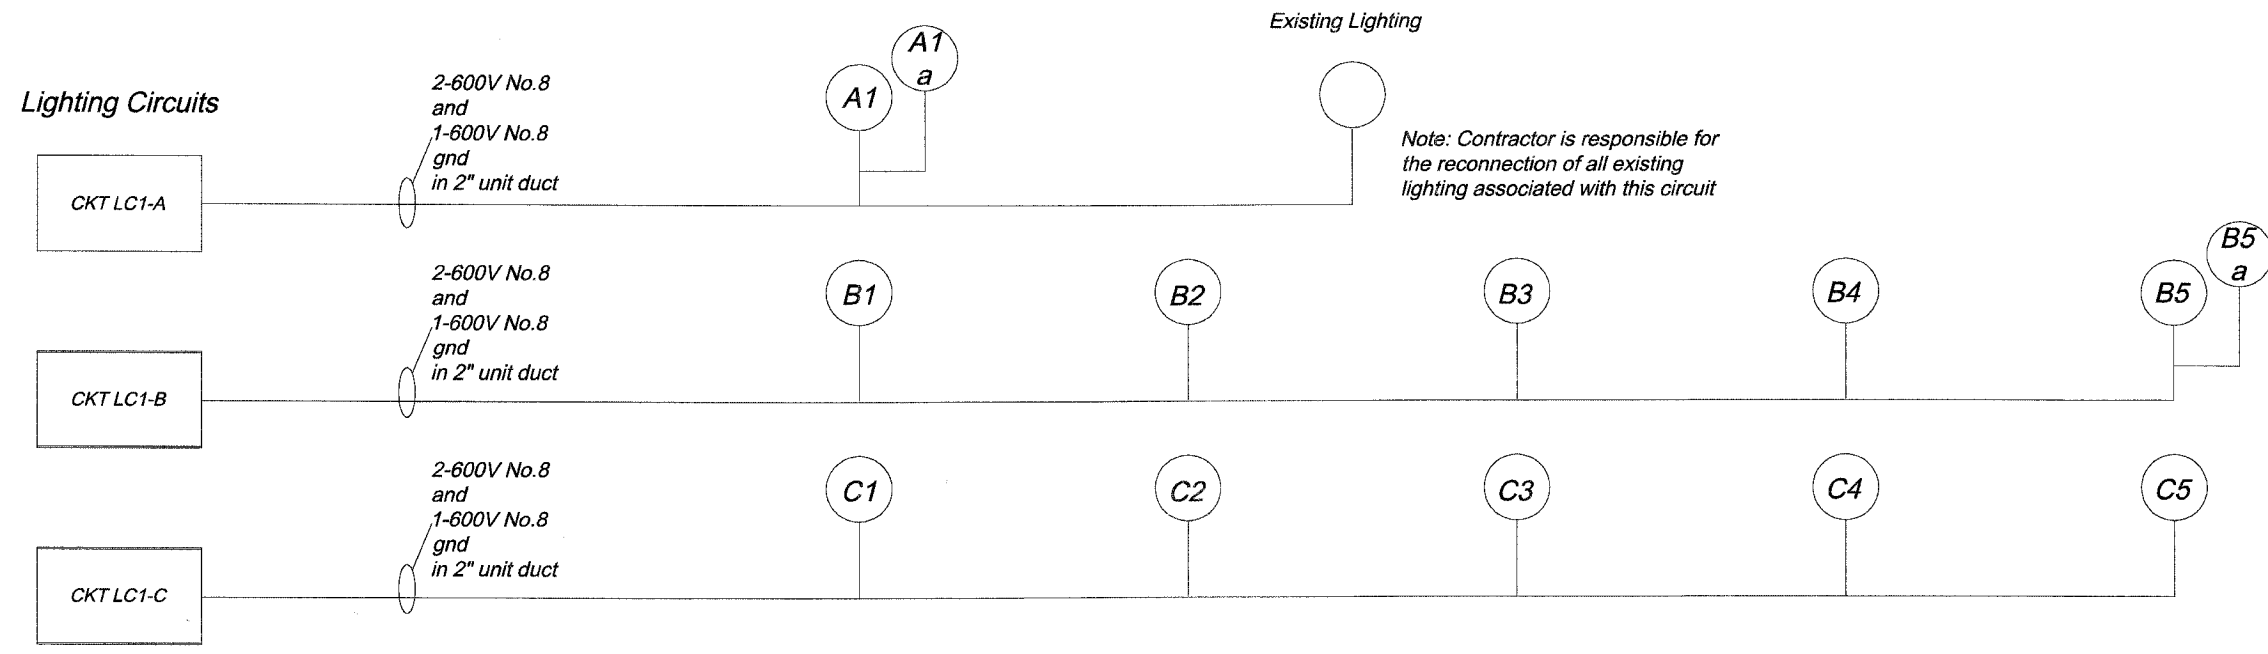

PLOT FILE: STANDARD  
C:\P\03-00247-00-BR  
COMP. FILE: 030101-00-100-100.dwg

REVISIONS		
NO.	NAME	DATE
7.		
6.		
5.		
4.		
3.		
2.		
1.		

**SMITH ENGINEERING CONSULTANTS, INC.**  
 CIVIL/STRUCTURAL ENGINEERS AND SURVEYORS  
 4500 PRIME PARKWAY SUITE 201  
 MOHENTY, ILLINOIS 60060  
 PH: 815-386-1778 FAX: 815-386-1781  
 www.smithengineering.com E-MAIL: sec@smithengineering.com  
 \*McHENRY \*HUNTLEY \*YORKVILLE  
 ILLINOIS PROFESSIONAL DESIGN FIRM # 184-000108

ILLINOIS DEPARTMENT OF TRANSPORTATION

CITY OF AURORA  
 ILLINOIS AVENUE OVER THE FOX RIVER  
 LIGHTING PLANS AND DETAILS  
 ONE LINE DIAGRAM

SCALE: N.T.S. DRAWN BY  
 DATE 07-28-05 CHECKED BY GB