 



NOTE

1. INSTALL 2" P.V.C. CONDUIT RACEWAY IN PROPOSED FOUNDATION FOR FUTURE EXPANSION OF LIGHTING SYSTEM, EXTEND 2' OUT FROM FOUNDATION, CAP AND SEAL. COST OF CONDUIT RACEWAY SHALL BE CONSIDERED INCLUDED IN COST OF "LIGHT POLE FOUNDATION".

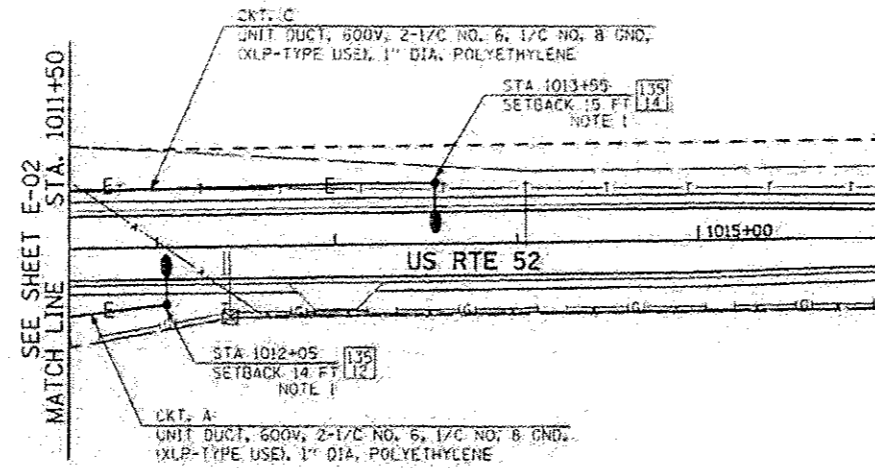

E-03

FILE NAME: \\30516884-04\sh\Sections\CADD\Sheet\036684-ent-light 3.dwg	USER NAME: bdschane	DESIGNED: - 30	EJM ENGINEERING, INC. 411 South Wells Street Suite 1000 Chicago, Illinois 60607	STATE OF ILLINOIS DEPARTMENT OF TRANSPORTATION	ILLINOIS ROUTE 47 AT US 52 LIGHTING PLAN	P&P (REV):	SECTION:	COUNTY:	TOTAL SHEETS:	SHEET NO.:
PILOT SCALE: 1/8"=8'-0"	CHECKED: - VR	306				1109, 1108, 1105R & BR-1	GRANDY	619	366	
PILOT DATE: 7/14/2014	DATE: 7/01/2014	SCALE: 1"=50'				SHEET: 3 OF 4 SHEETS		STA. 6442+40 TO STA. 6459+05		PRELIMINARY ILLINOIS TCO. A10 PROJECT
						CONTRACT NO. 66884				