 



PLAN	REVISIONS	DATE
NO.	PLOTTED	
	ALIGNED	
	CHECKED	
	CAD FILE NAME	

PROFILE	REVISIONS	DATE
NO.	PLOTTED	
	GRADES CHECKED	
	STRUCTURE NOTINGS CHECKED	

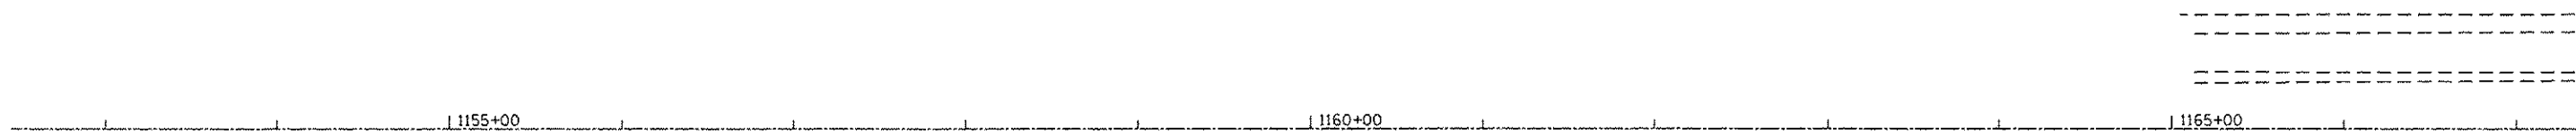

Station	Profile	Grade	Notes
680			BM 1167: STA. 1167+47, C I-57 POT PLUG ELEV. - 671.60
675			
670			
665			
680			
675			
670			
665			

FILE NAME : c:\pwork\p1dot\dunacomb\d8315542\036653-plansheet.dgn	USER NAME : dunacomb	DESIGNED -	REVISIONS -	<b>STATE OF ILLINOIS</b> <b>DEPARTMENT OF TRANSPORTATION</b>	<b>PLAN AND PROFILE</b>	F.A.I. RTE. 57	SECTION (38-3)RS-2	COUNTY IROQUOIS	TOTAL SHEETS 186	SHEET NO. 23
PLOT SCALE = 100.0000' / 1" =		CHECKED -	REVISIONS -			CONTRACT NO. 66C53				
PLOT DATE = 6/10/2014		DRAWN -	REVISIONS -			SCALE: 1"=50'	SHEET NO. 1 OF 31 SHEETS	STA. TO STA. 100+00	FED. ROAD DIST. NO. ILLINOIS FED. AID PROJECT	
		CHECKED -	REVISIONS -							